



ALL KEYED NOTES APPLY TO THIS SHEET ONLY.

KEYED NOTES:

1. REMOVE COBRA HEAD LIGHT FIXTURE FROM POLE AND REPLACE WITH NEW TYPE F3 FIXTURE.
2. 2" CONDUIT, 2*6 AND 1*6 GND FOR CIRCUIT LC6-4.

- NOTES:
1. STATIONS AND OFFSETS SHOWN ON THIS SHEET ARE TO THE CENTER OF HANDHOLE AND LIGHT POLE FOUNDATIONS.
 2. COORDINATE INSTALLATION OF UNDERGROUND CONDUIT AND LIGHT FIXTURES WITH ALL EXISTING UNDERGROUND SYSTEMS AND PROPOSED LANDSCAPE FEATURES AND PLANTINGS.
 3. SEE IRRIGATION PLANS FOR UNDERGROUND CONDUIT AND PIPING. COORDINATE INSTALLATION OF UNDERGROUND FACILITIES.
 4. 'F' DESIGNATIONS OF LIGHT FIXTURES SHOWN ON LIGHTING DETAILS SHEET.

WW CRAINGER

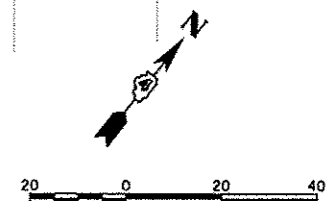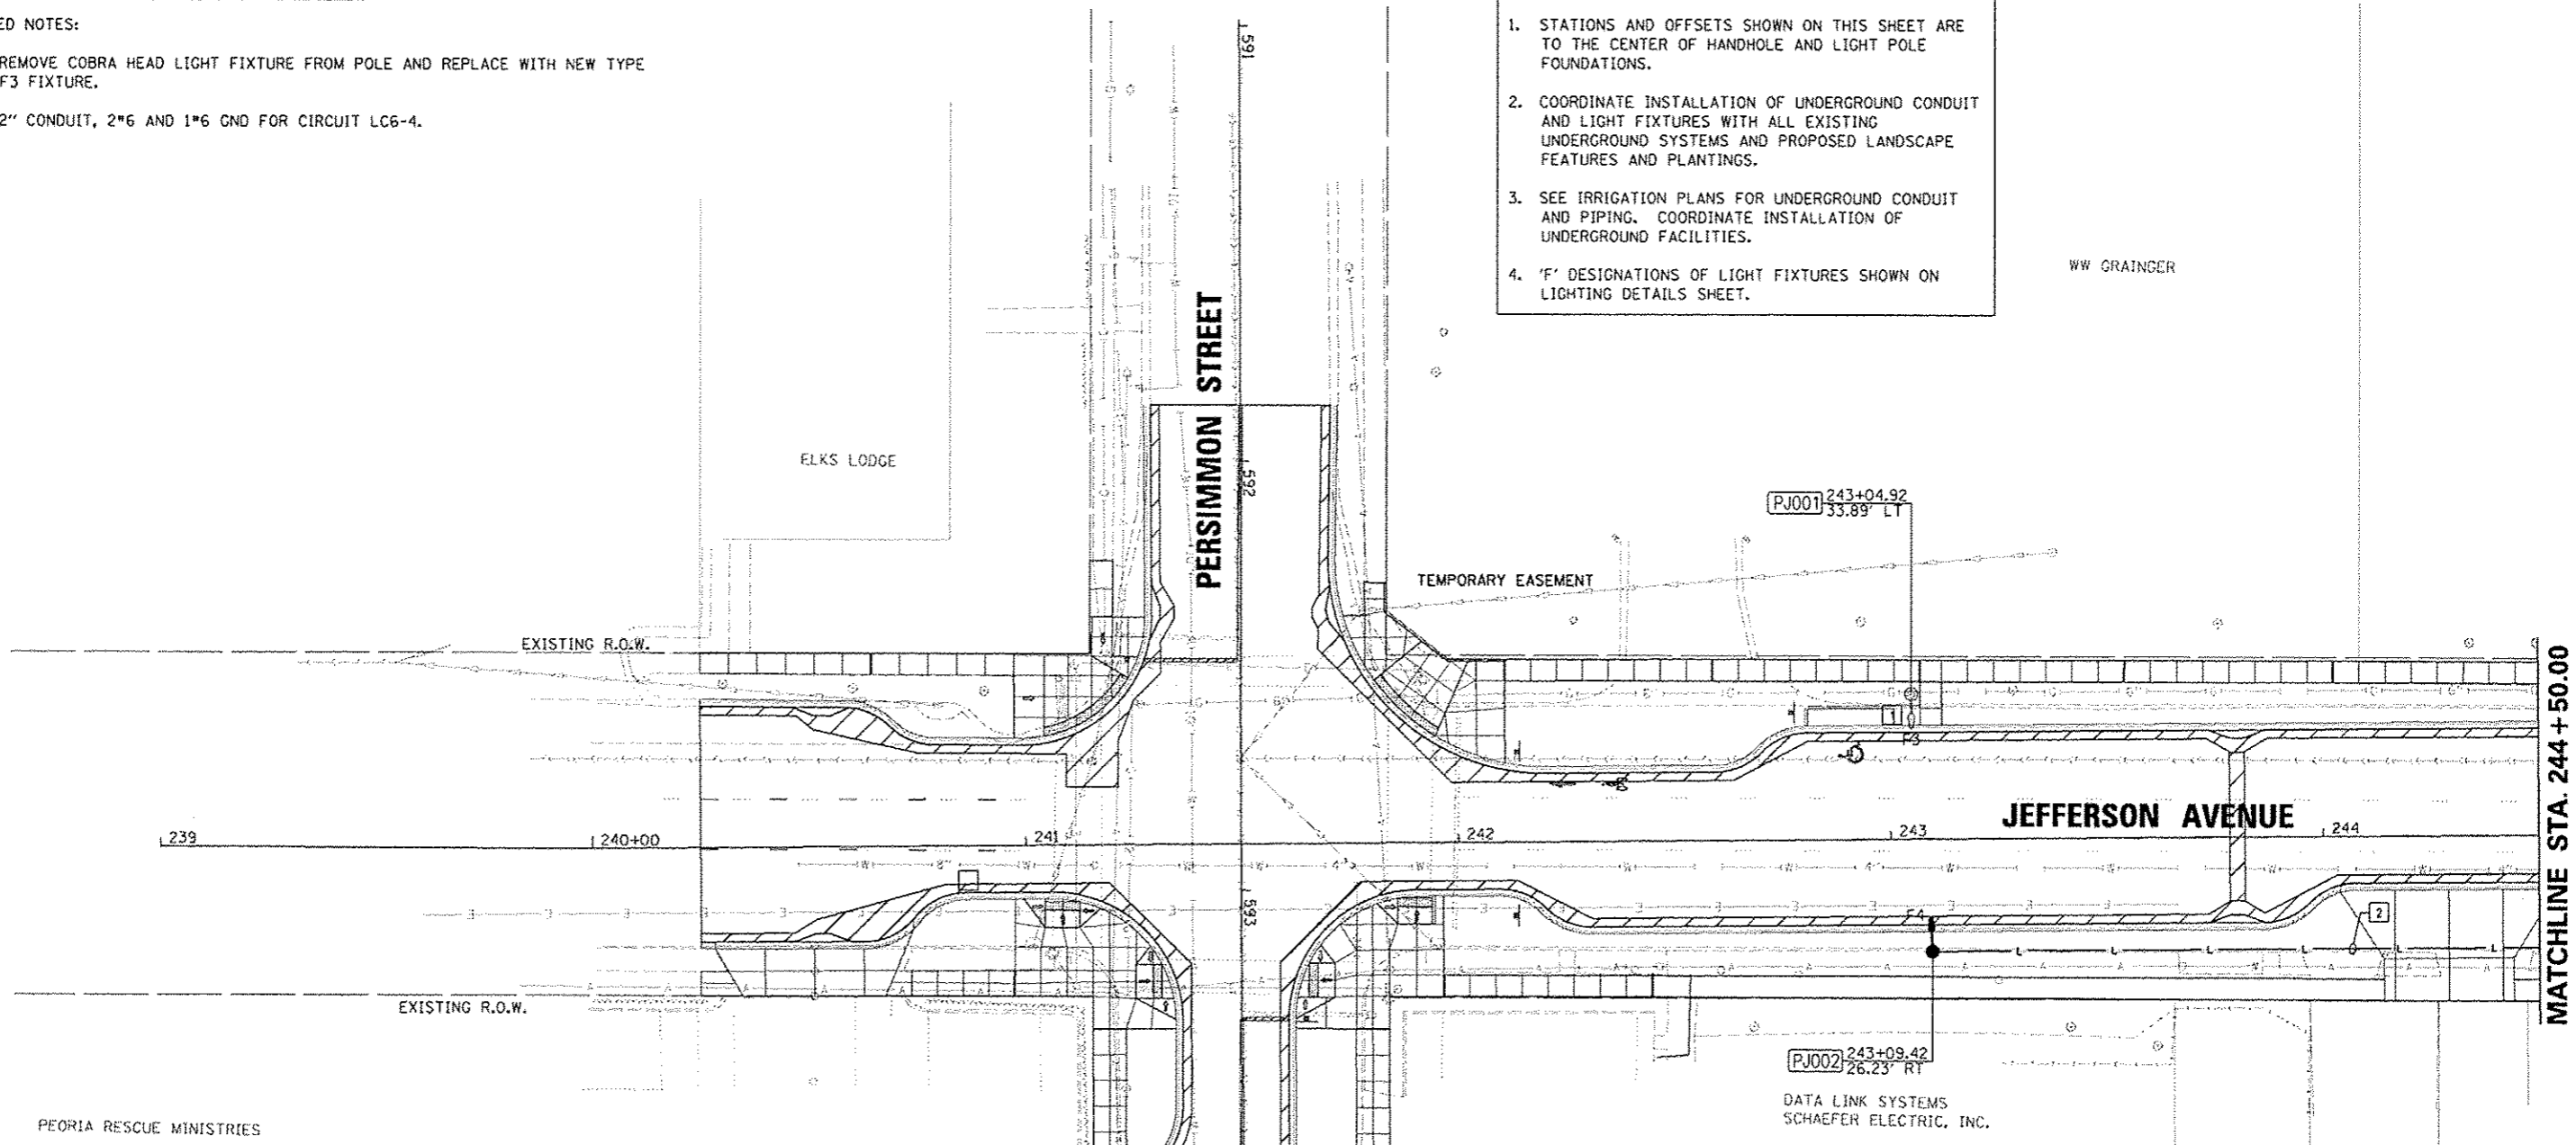

FILE NAME * o:\p\cei\work\do_not_delete\dms73318\041	USER NAME * monsk81399	DESIGNED - JDE	REVISED -	STATE OF ILLINOIS DEPARTMENT OF TRANSPORTATION	JEFFERSON AVENUE LIGHTING PLAN	F.A.U. RTE. 12	SECTION 12-00356-01-PV	COUNTY PEORIA	TOTAL SHEETS	SHEET NO.
	PLOT SCALE * 39.9999' / 1" IN.	DRAWN - TMT	REVISED -						519	359
	PLOT DATE * 07/23/2012	CHECKED - BMS	REVISED -	SCALE: 1"=20'	SHEET NO. OF SHEETS	STA. 240+25.00 TO STA. 244+50.00	CONTRACT NO. 89626		ILLINOIS FED. AID PROJECT	TIG-50931(58)
		DATE - 7/18/12	REVISED -							

Farnsworth GROUP
 7707 N. KNOXVILLE AVE, SUITE 100
 PEORIA, ILLINOIS 61614
 (309) 699-8888 / (309) 699-9820 Fax
 www.Fw.com