
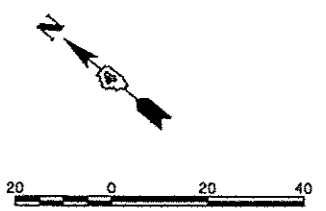


- NOTES:
1. STATIONS AND OFFSETS SHOWN ON THIS SHEET ARE TO THE CENTER OF HANDHOLE AND LIGHT POLE FOUNDATIONS.
 2. COORDINATE INSTALLATION OF UNDERGROUND CONDUIT AND LIGHT FIXTURES WITH ALL EXISTING UNDERGROUND SYSTEMS AND PROPOSED LANDSCAPE FEATURES AND PLANTINGS.
 3. SEE IRRIGATION PLANS FOR UNDERGROUND CONDUIT AND PIPING. COORDINATE INSTALLATION OF UNDERGROUND FACILITIES.
 4. 'F' DESIGNATIONS OF LIGHT FIXTURES SHOWN ON LIGHTING DETAILS SHEET.

ALL KEYED NOTES APPLY TO THIS SHEET ONLY.

- KEYED NOTES:
1. 2" CONDUIT, 2#6 AND 1#6 GND FOR CIRCUIT LC6-3.
 2. 2" CONDUIT, 2#6 AND 1#6 GND FOR CIRCUIT LC4-3.

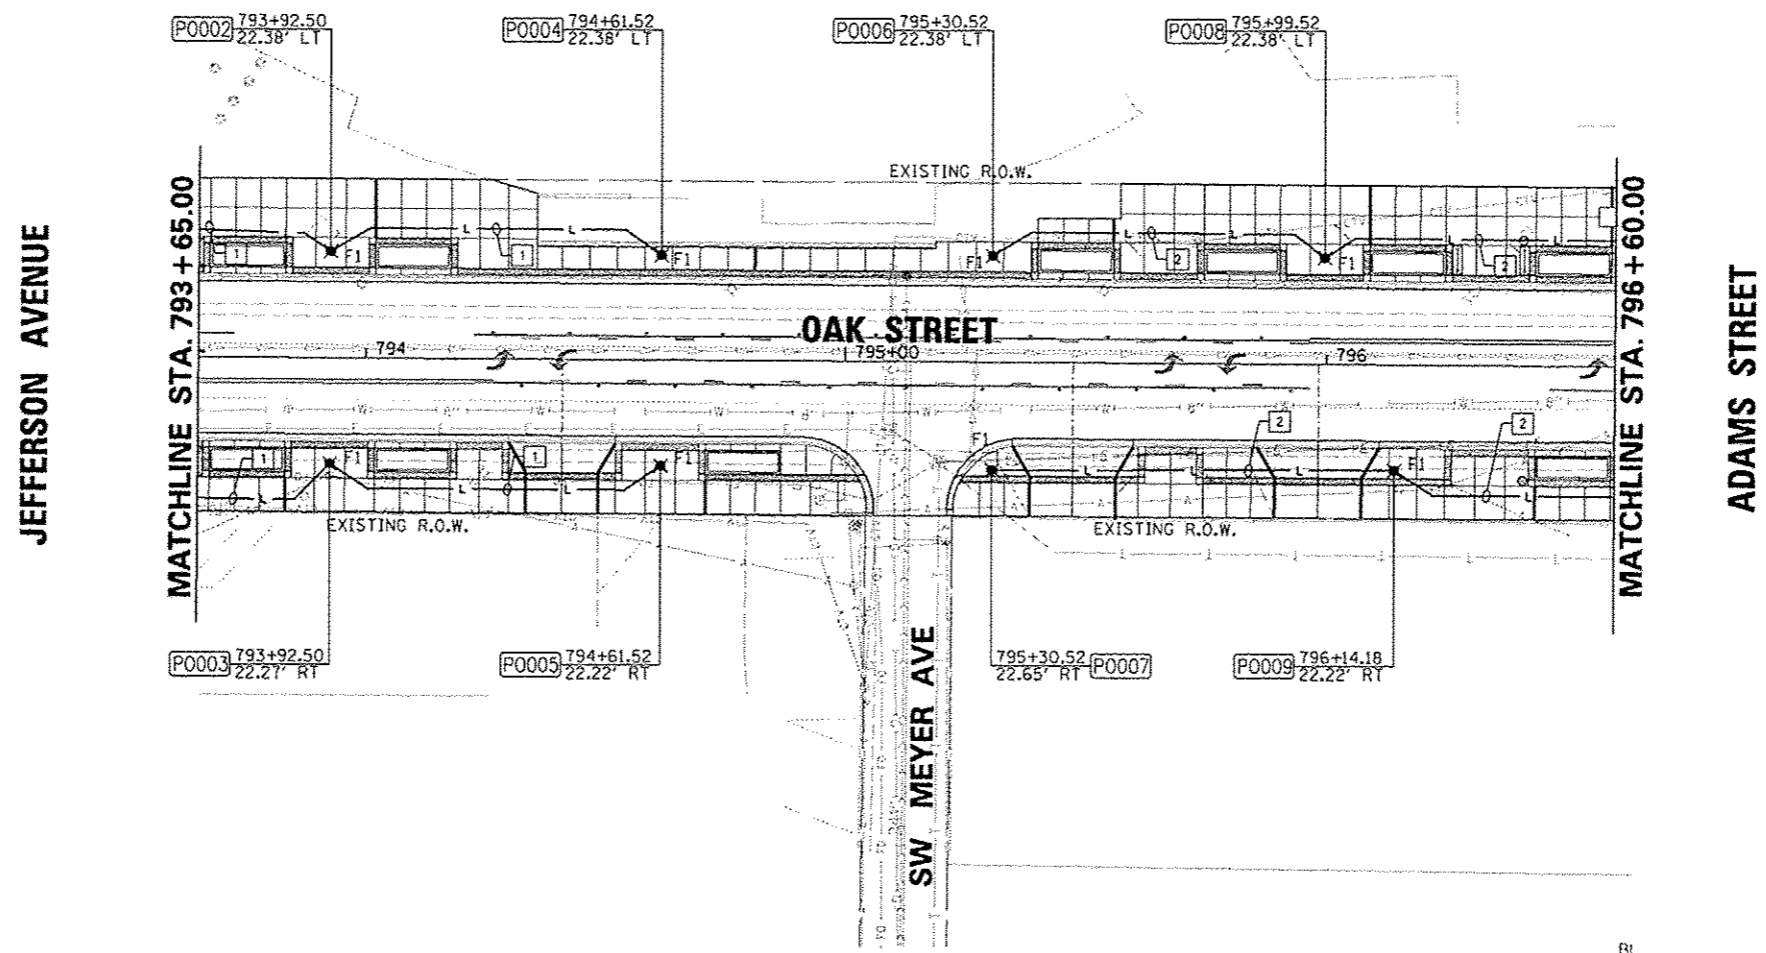

| | | | | | | | | | | | | |
|--|-------------------------------|-------------------|----------------|---|--|---------------------|----------------------------------|-----------------------|---------------------------|------------------|------------------------|---------------------|
| FILE NAME = c:\pwise_work\do_not_delete\dms7338\041 | USER NAME = monak81390 | DESIGNED = JDE | REVISED = - | STATE OF ILLINOIS DEPARTMENT OF TRANSPORTATION | OAK STREET LIGHTING PLAN | | | F.A.U. RTE. 663 | SECTION 12-00356-01-PV | COUNTY PEORIA | TOTAL SHEETS 519 | SHEET NO. 366 |
| | PL0T SCALE = 3/8" = 1' in. | CHECKED = BMS | REVISED = - | | SCALE: 1"=20' | SHEET NO. OF SHEETS | STA. 793+65.00 TO STA. 796+60.00 | CONTRACT NO. 89626 | | | | |
| | PL0T DATE = 07/23/2012 | DATE = 7/18/12 | REVISED = - | | ILLINOIS FED. AID PROJECT TIC-50931591 | | | | | | | |
| | | | | | | | | | | | | |

Farnsworth GROUP
7707 N. KNOXVILLE AVE, SUITE 100
PEORIA, ILLINOIS 61614
(309) 699-0888 / (309) 699-9820 Fax
www.fwg.com