
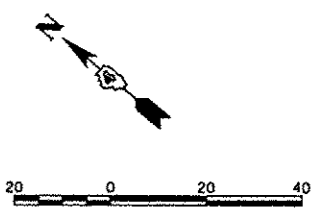


- NOTES:
1. STATIONS AND OFFSETS SHOWN ON THIS SHEET ARE TO THE CENTER OF HANDHOLE AND LIGHT POLE FOUNDATIONS.
 2. COORDINATE INSTALLATION OF UNDERGROUND CONDUIT AND LIGHT FIXTURES WITH ALL EXISTING UNDERGROUND SYSTEMS AND PROPOSED LANDSCAPE FEATURES AND PLANTINGS.
 3. SEE IRRIGATION PLANS FOR UNDERGROUND CONDUIT AND PIPING. COORDINATE INSTALLATION OF UNDERGROUND FACILITIES.
 4. 'F' DESIGNATIONS OF LIGHT FIXTURES SHOWN ON LIGHTING DETAILS SHEET.

ALL KEYED NOTES APPLY TO THIS SHEET ONLY.

- KEYED NOTES:
1. 2" CONDUIT, 2*6 AND 1*6 GND FOR CIRCUIT LC4-4.

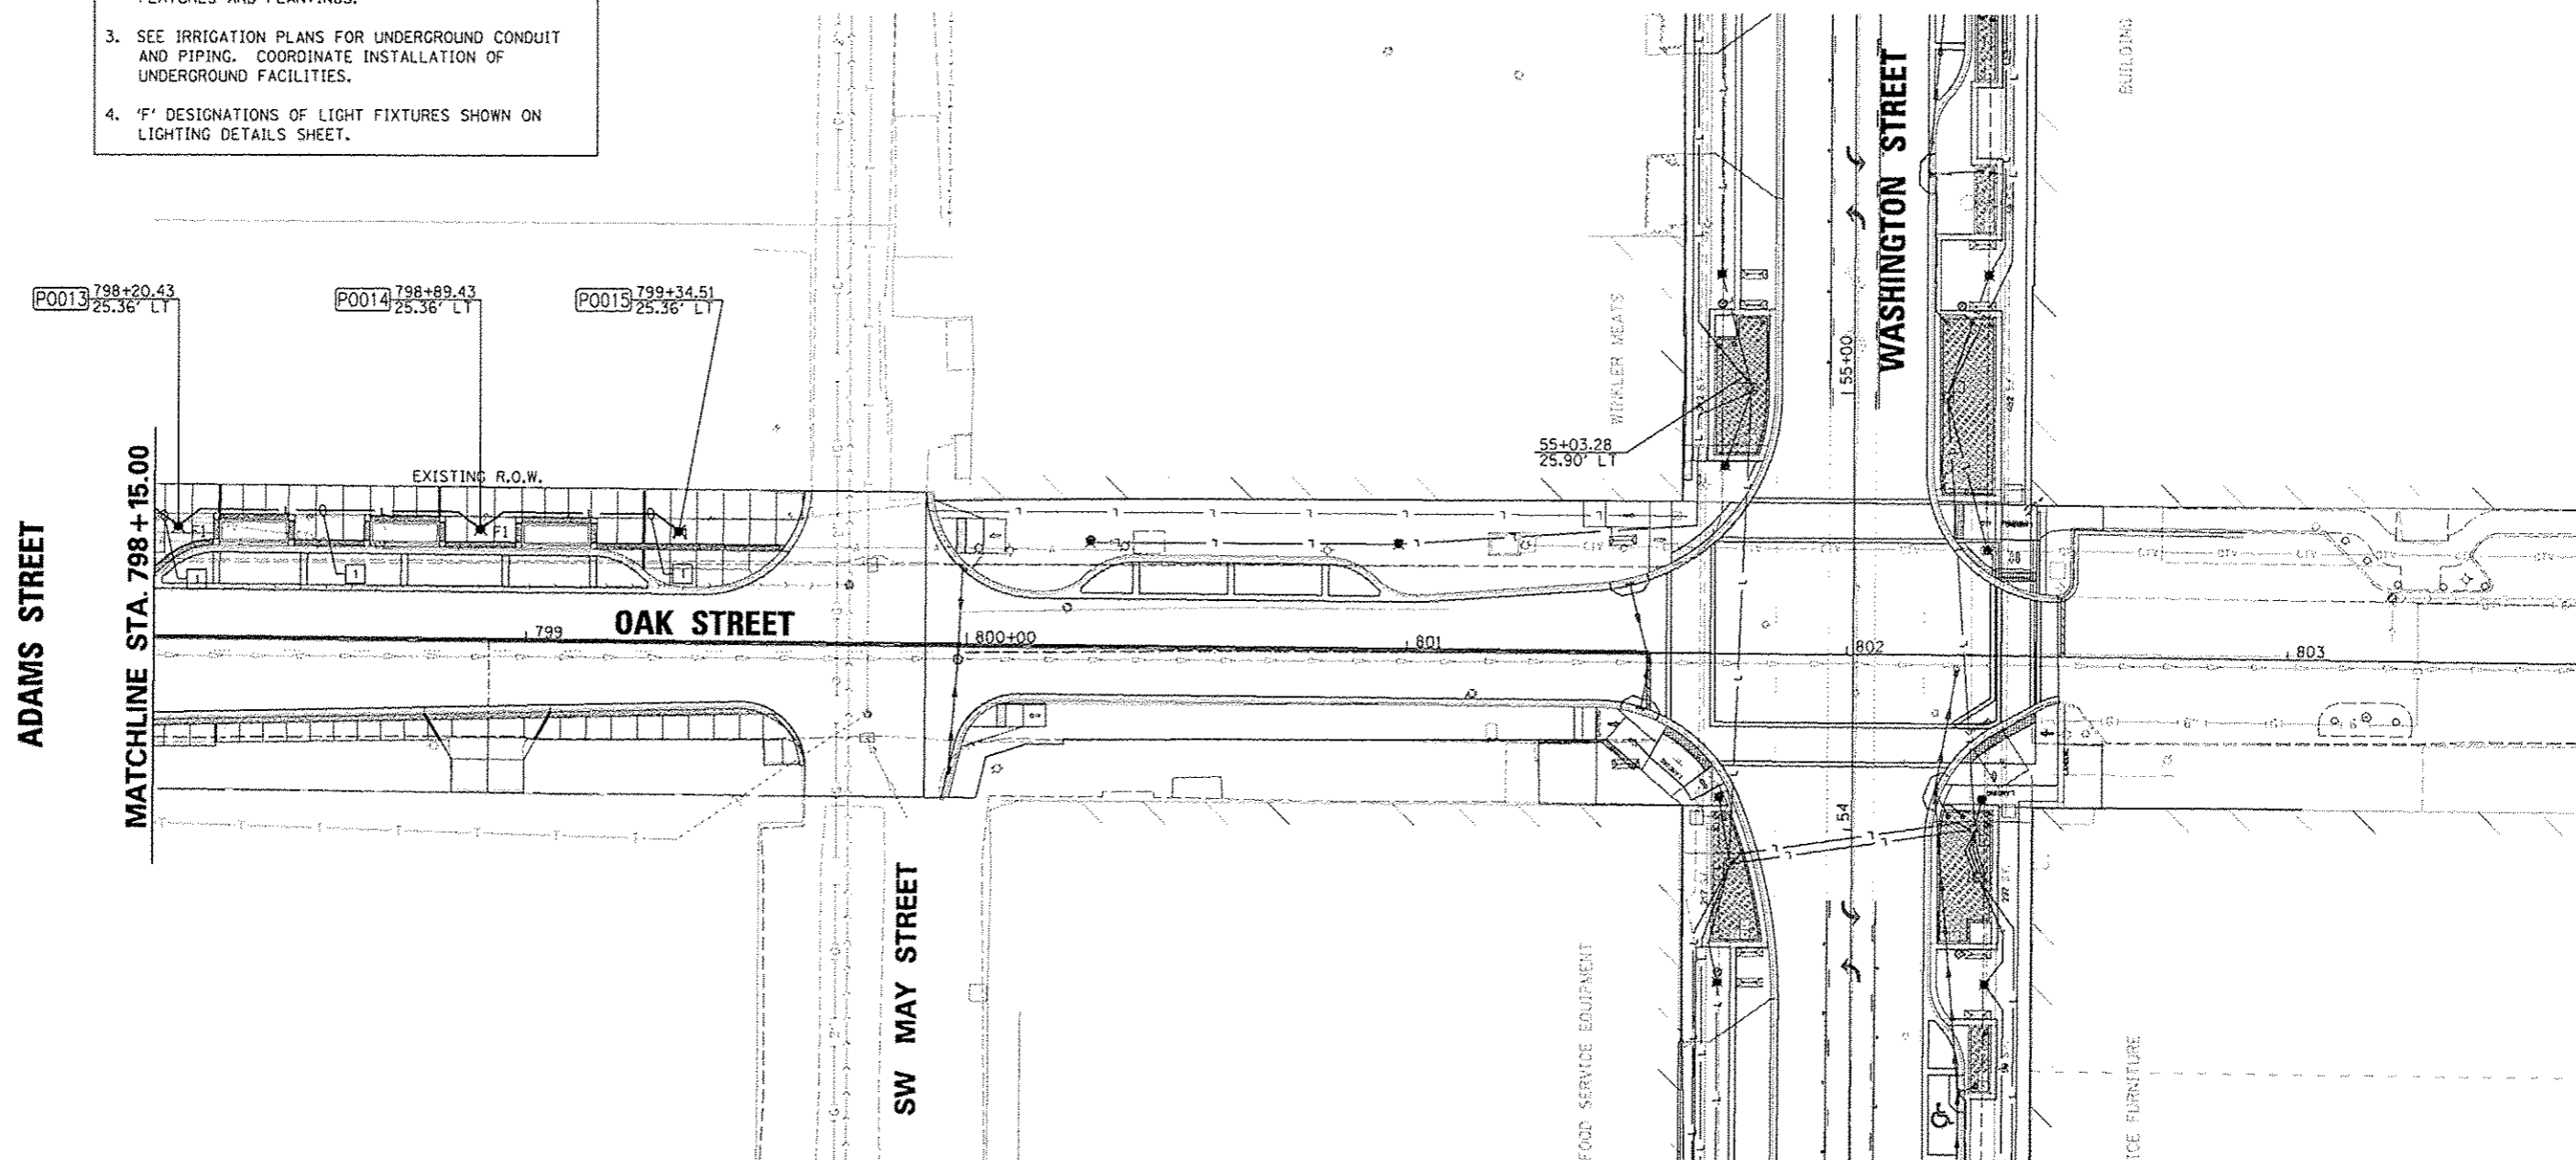

FILE NAME * c:\pwise_work\do_not_delete\dms73316\04	USER NAME * mgnek01390	DESIGNED - JDE	REVISED - -
	DRAWN - TMT	REVISED - -	
	CHECKED - BMS	REVISED - -	
	DATE - 7/18/12	REVISED - -	

**STATE OF ILLINOIS
DEPARTMENT OF TRANSPORTATION**

**OAK STREET
LIGHTING PLAN**

SCALE: 1"=20' SHEET NO. OF SHEETS STA. 798+15.00 TO STA. 803+65.00

F.A.J. RTE.	SECTION	COUNTY	TOTAL SHEETS	SHEET NO.
62	12-00356-01-PV	PEORIA	519	367
CONTRACT NO. 89626				
ILLINOIS FED. AID PROJECT TIG-509315B1				

Farnsworth GROUP
7707 N. KNOXVILLE AVE, SUITE 100
PEORIA, ILLINOIS 61614
(309) 699-8888 / (309) 699-9820 Fax
www.fsg.com