
 


F.A.P. RTE.	SECTION	COUNTY	TOTAL SHEETS	SHEET NO.
840	123 BR-2	IROQUOIS	67	13
FED. ROAD DIST. NO. 7		ILLINOIS	FED. AID PROJECT	
CONTRACT NO. 66612				

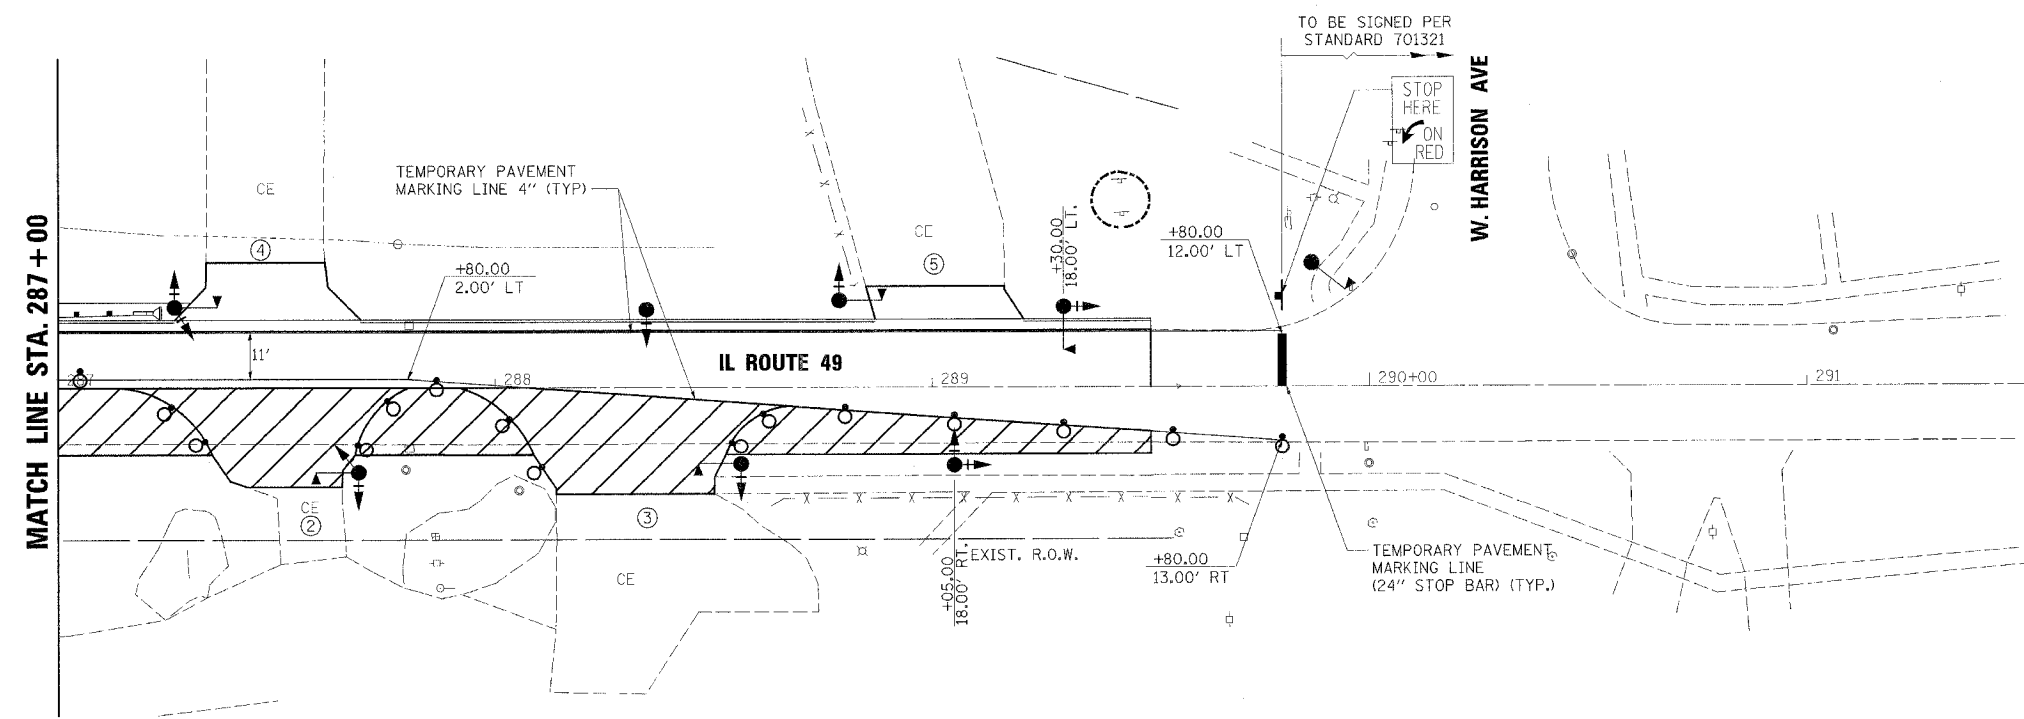

- LEGEND
- WORK AREA
 - TEMPORARY PAVEMENT
 - SIGN
 - TRAFFIC SIGNAL WITH BACKPLATE
 - DRUM WITH STEADY BURNING LIGHT
 - TYPE C BIDIRECTIONAL REFLECTOR
 - DOUBLE VERTICAL PANEL
 - TEMPORARY CONCRETE BARRIER
 - IMPACT ATTENUATOR, TEMPORARY (NON-REDIRECTIVE) TEST LEVEL 3
 - STEADY BURNING LIGHTS AND DOUBLE VERTICAL PANELS
 - TYPE III BARRICADE
 - TEMPORARY SHEET PILING
 - MICROWAVE DETECTOR
 - ENTRANCE DESIGNATION

SEQUENCE OF OPERATIONS															
PHASE	A			B			C			D			E		
INTERVAL	1	2	3	4	5	6	7	8	9	10	11	12	13	14	15
NORTHBOUND IL ROUTE 49 SIGNALS	G	Y	R	R	R	R	R	R	R	R	R	R	R	R	R
SOUTHBOUND IL ROUTE 49 SIGNALS	R	R	R	G	Y	R	R	R	R	R	R	R	R	R	R
WESTBOUND CLAYTONVILLE/ GOODWINE SIGNALS	R	R	R	R	R	R	G	Y	R	R	R	R	R	R	R
ENTRANCES ① ② & ③	R	R	R	R	R	R	R	R	R	G	Y	R	R	R	R
ENTRANCES ④ & ⑤	R	R	R	R	R	R	R	R	R	R	R	R	R	G	Y



PLOT SCALE: 1/2" = 40'
 PLOT TIME: 8:39:20 AM
 PLOTTED BY: Jiracek
 A:\2007\road\design\2007_Stage2_Acjob
 MODEL NAME: D0-F04T

rjngroup
 Excellence through Ownership
 200 West Front Street
 Wheaton, IL 60187

REVISIONS	
NAME	DATE

ILLINOIS DEPARTMENT OF TRANSPORTATION
 F.A.P. ROUTE 840 (IL-49)
TRAFFIC CONTROL
CONSTRUCTION STAGING
STAGE II
STA. 287+00 TO STA. 291+50
 SCALE: 1" = 20' DRAWN BY: JMC
 DATE: AUGUST 7, 2007 CHECKED BY: DWB