

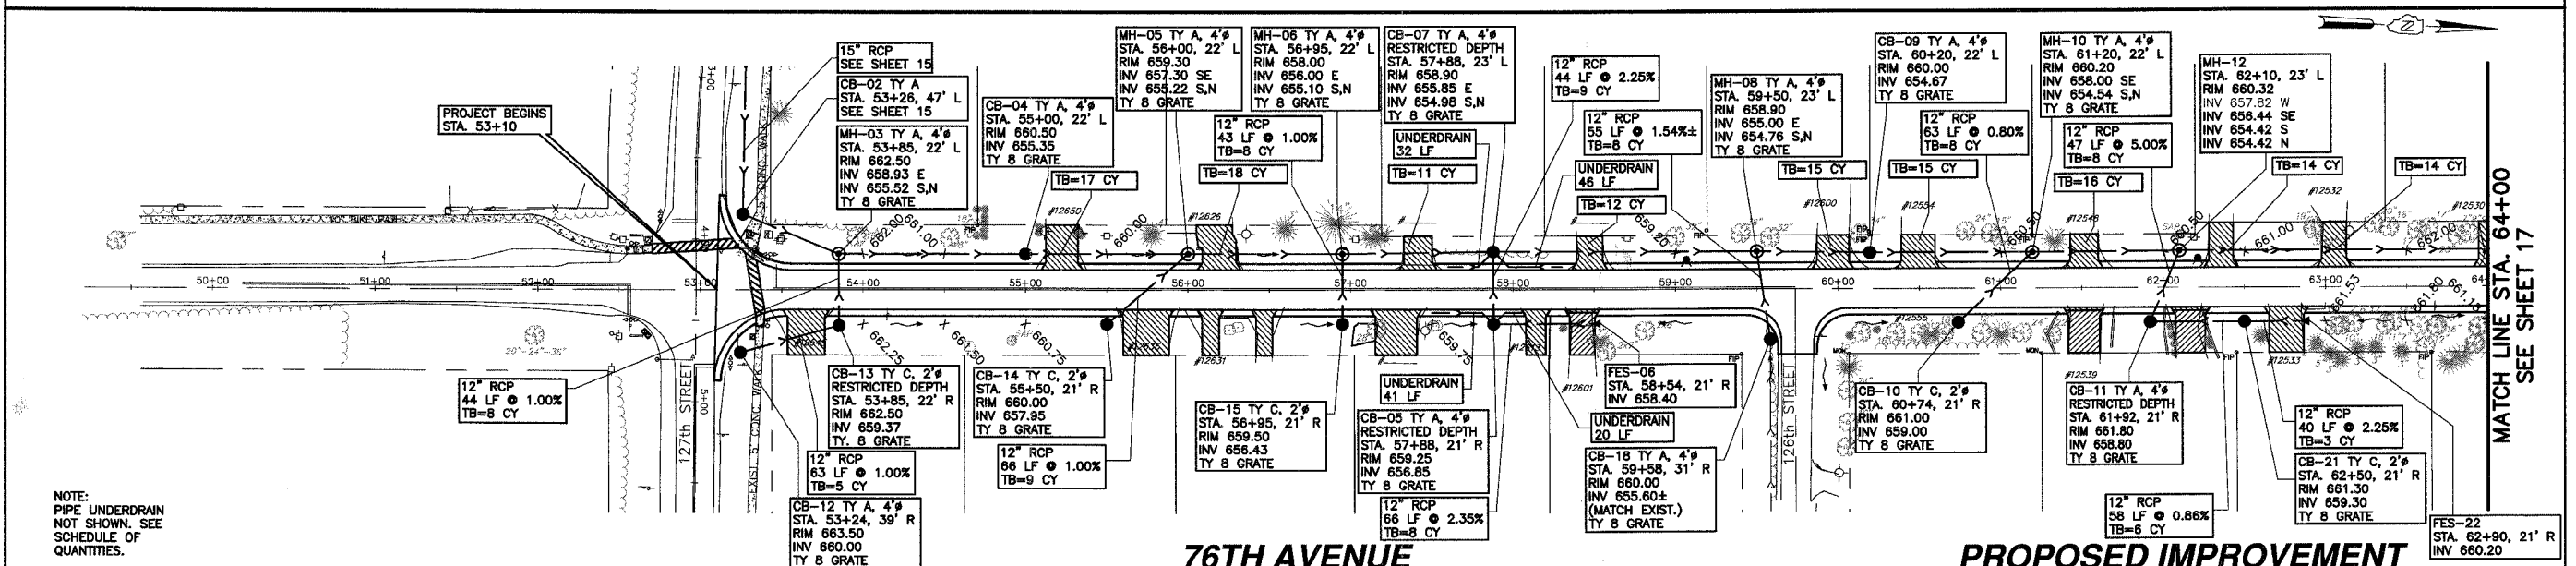


FAU RTE.	SECTION	COUNTY	TOTAL SHEETS	SHEET NO.
3791	02-00037-00-WR	COOK	40	16
F.H.W.A. REG.	ILLINOIS	PROJECT:		
83957				

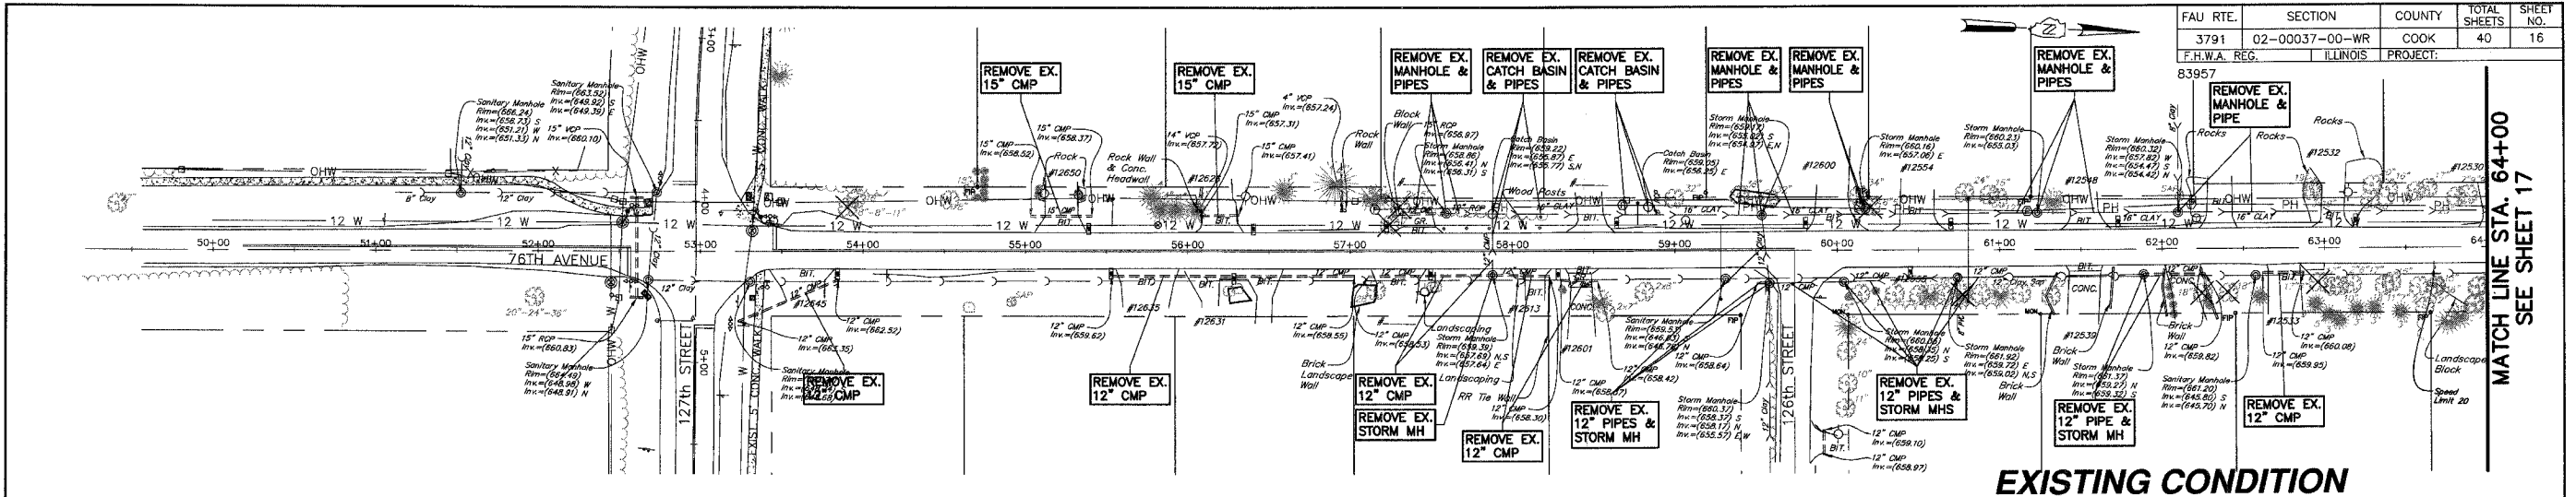

NOTE:
PIPE UNDERDRAIN
NOT SHOWN. SEE
SCHEDULE OF
QUANTITIES.

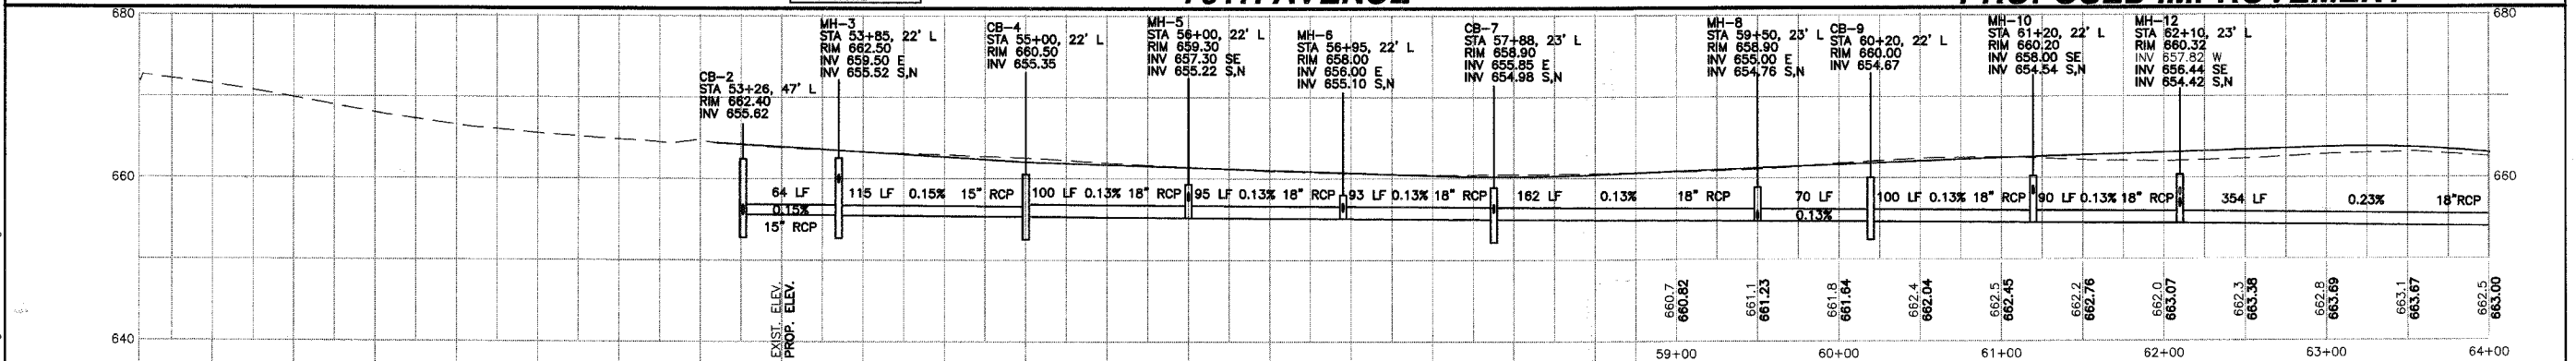

PLAN DATE: 05/07/2007
 DRAWING: 3003-00037-00-WR-SHEET-3003-R&P.dwg

MORRIS ENGINEERING, INC.
 5100 LINCOLN AVE LISLE, ILLINOIS 60532
 PHONE: (630) 271-0770 WEBSITE: ECIVIL.COM

**76TH AVENUE RECONSTRUCTION
 127TH STREET TO ILLINOIS ROUTE 83
 DRAINAGE PLAN & PROFILE - 76TH AVENUE
 STA. 53+00 TO STA. 64+00**

LOCATION: H:\04-PH\3003\PLANS-ENG\REV-3\dwg\SHEET-3003-R&P.dwg
 DRAWN BY: CJS DESIGN BY: RAC CHECKED BY: JJV
 JOB NO.: 04-PH-3003 SCALE: 1"=50' H 1"=10' V

DATE	REVISIONS	BY	SHEET
1 5-09-07	PER IDOT REVIEW	RAC	16
2 5-24-07	PER IDOT REVIEW	RAC	
3 9-04-07	PER IDOT REVIEW	RAC	
4			

OF 40 SHEETS