

 

F.A.U. RTE.	SECTION	COUNTY	TOTAL SHEETS	SHEET NO.
	05-00054-00-WR	MADISON	110	42
FED. ROAD DIST. NO.		ILLINOIS	FED. AID PROJECT	

CONTRACT NO. 93220


FINAL SURVEY	DATE
SURVEY PLOTTED	
NOTE BOOK	
TEMPLATE	
AREAS CHECKED	
NO.	

MATCH LINE STA. 104+40.00

MATCH LINE STA. 110+00.00

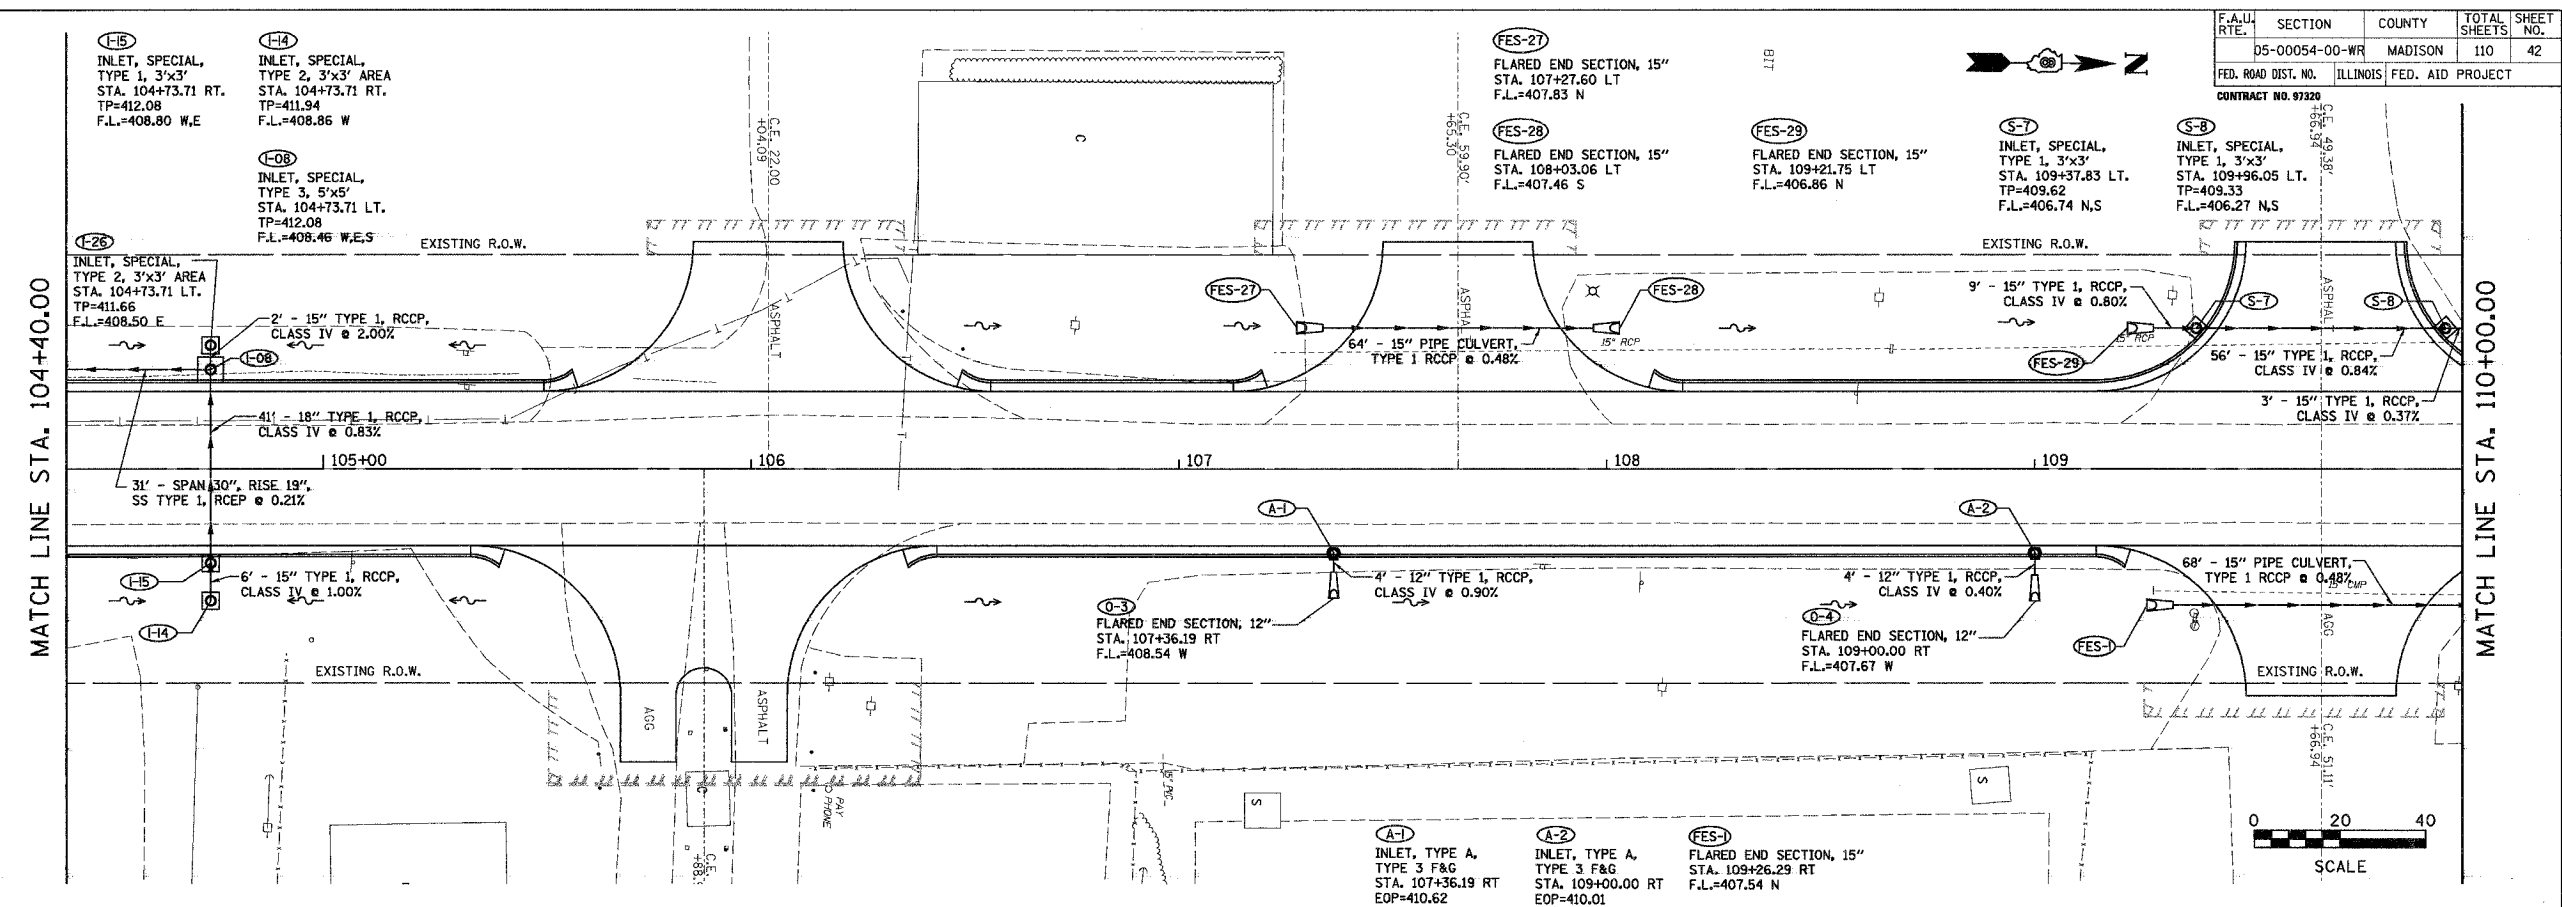

ORIGINAL SURVEY	DATE
SURVEY PLOTTED	
NOTE BOOK	
TEMPLATE	
AREAS CHECKED	
NO.	

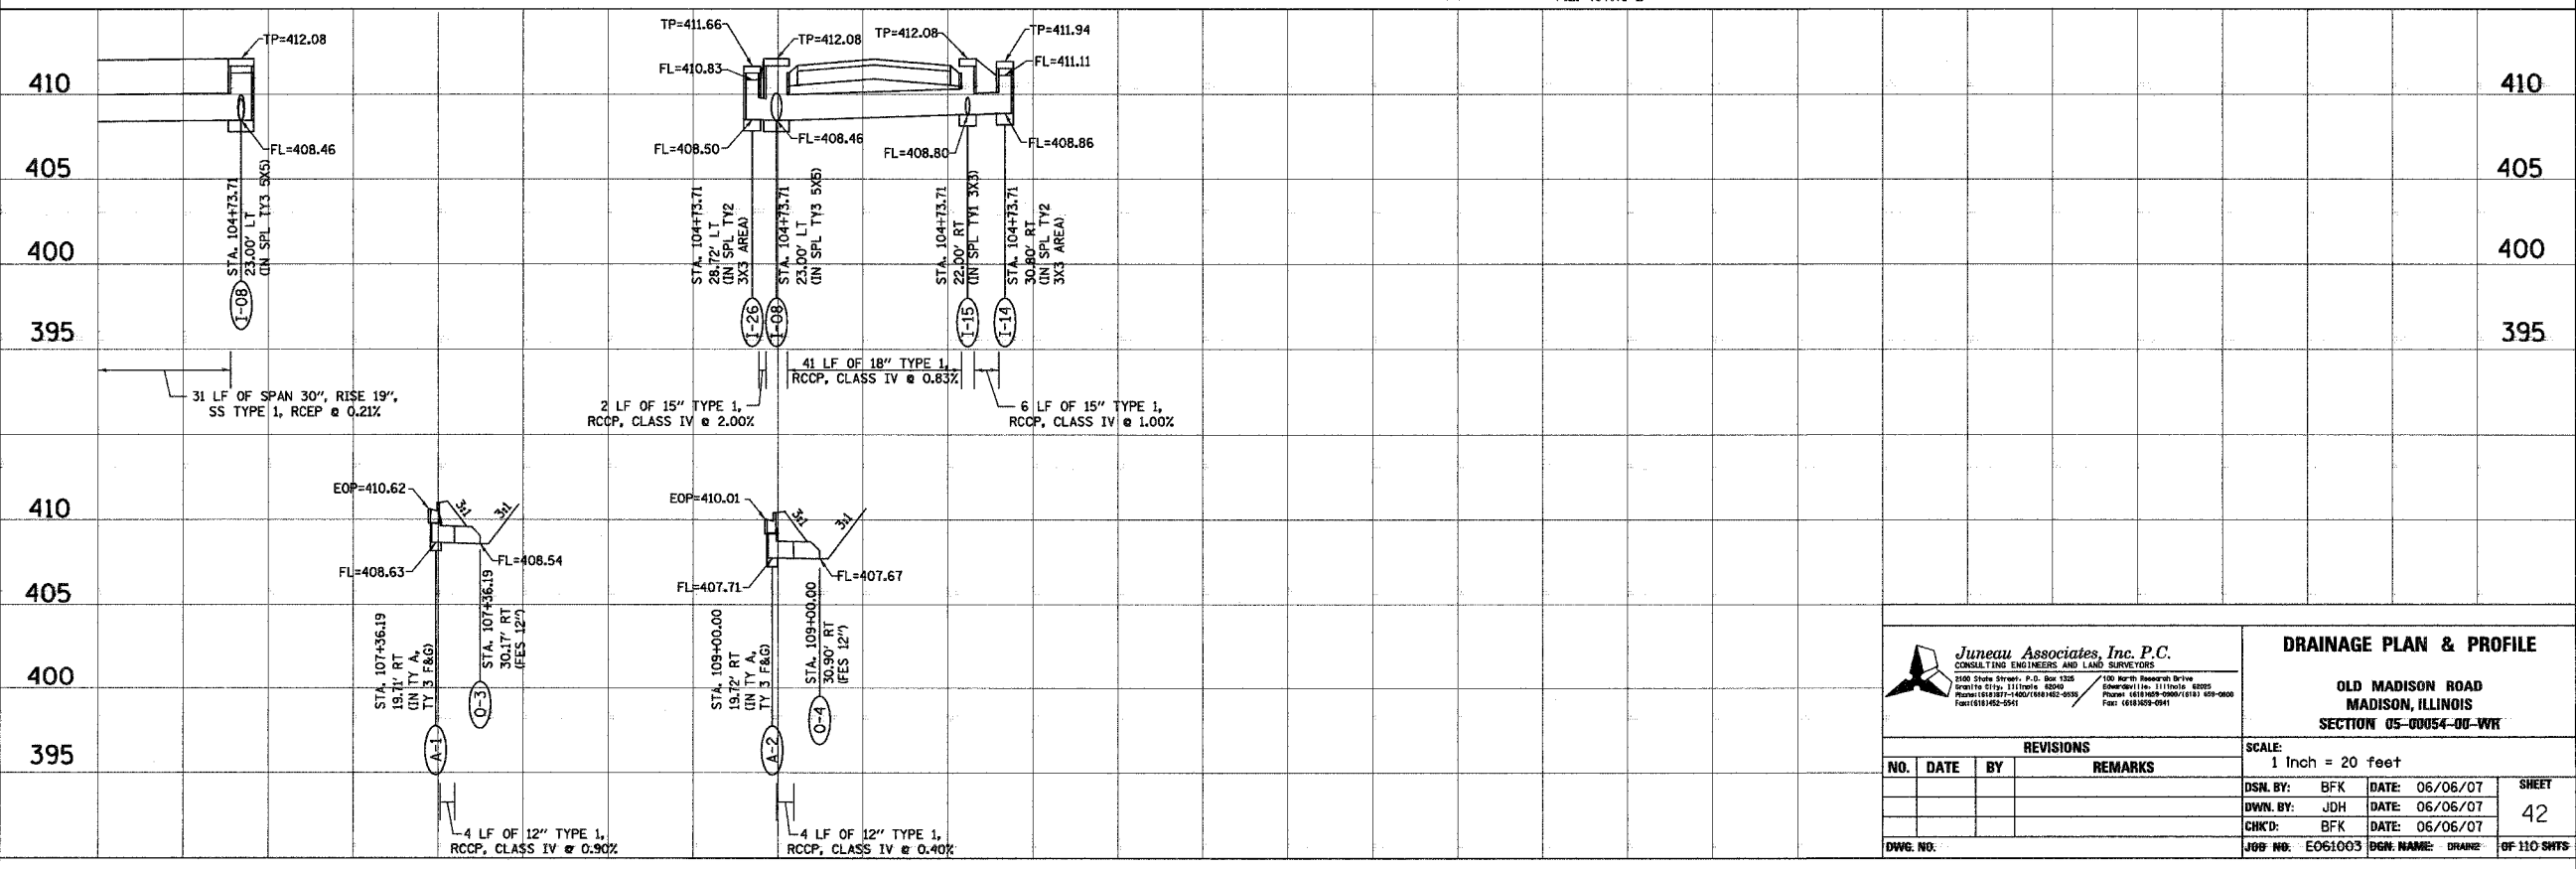

Juneau Associates, Inc. P.C.
CONSULTING ENGINEERS AND LAND SURVEYORS
2100 State Street, P.O. Box 1205
Madison, IL 61704-0205
Phone: (618) 939-1800 Fax: (618) 939-0000
FAX: (618) 939-0541

DRAINAGE PLAN & PROFILE
OLD MADISON ROAD
MADISON, ILLINOIS
SECTION 05-00054-00-WR

REVISIONS			
NO.	DATE	BY	REMARKS

SCALE: 1 Inch = 20 feet	
DSM BY: BFK	DATE: 06/06/07
DWN BY: JDH	DATE: 06/06/07
CHK'D: BFK	DATE: 06/06/07
DWG. NO.:	JOB NO.: E061003
	DGN. NAME: DRAINAGE
	OF 110 SHEETS

SHEET
42