



F.A.U. RTE.	SECTION	COUNTY	TOTAL SHEETS	SHEET NO.
	D5-00054-00-WR	MADISON	110	44
FED. ROAD DIST. NO.	ILLINOIS	FED. AID PROJECT		
CONTRACT NO. 97320				

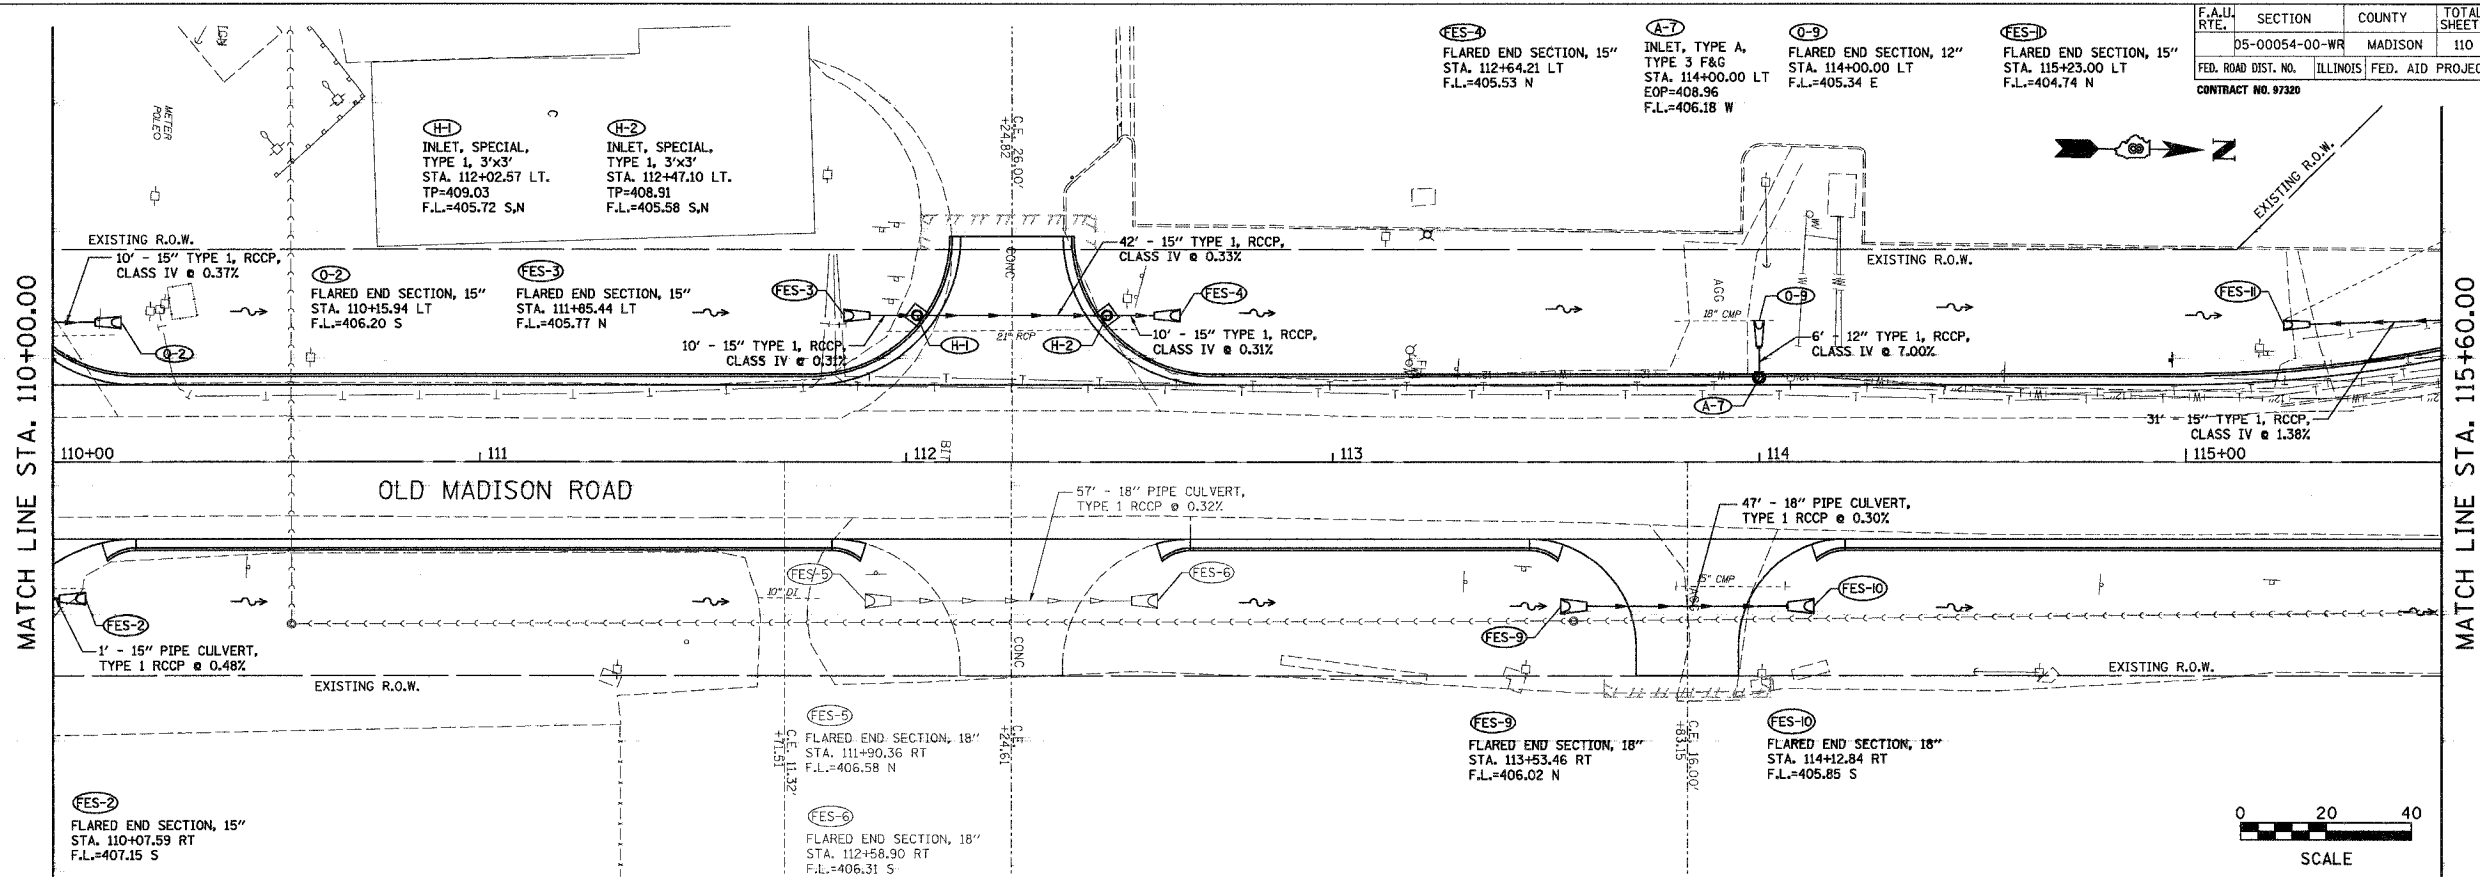

BY	DATE
FINAL SURVEY PLOTTED	
NOTE BOOK TEMPLATE	
AREAS CHECKED	
NO.	

BY	DATE
ORIGINAL SURVEY PLOTTED	
NOTE BOOK TEMPLATE	
AREAS CHECKED	
NO.	

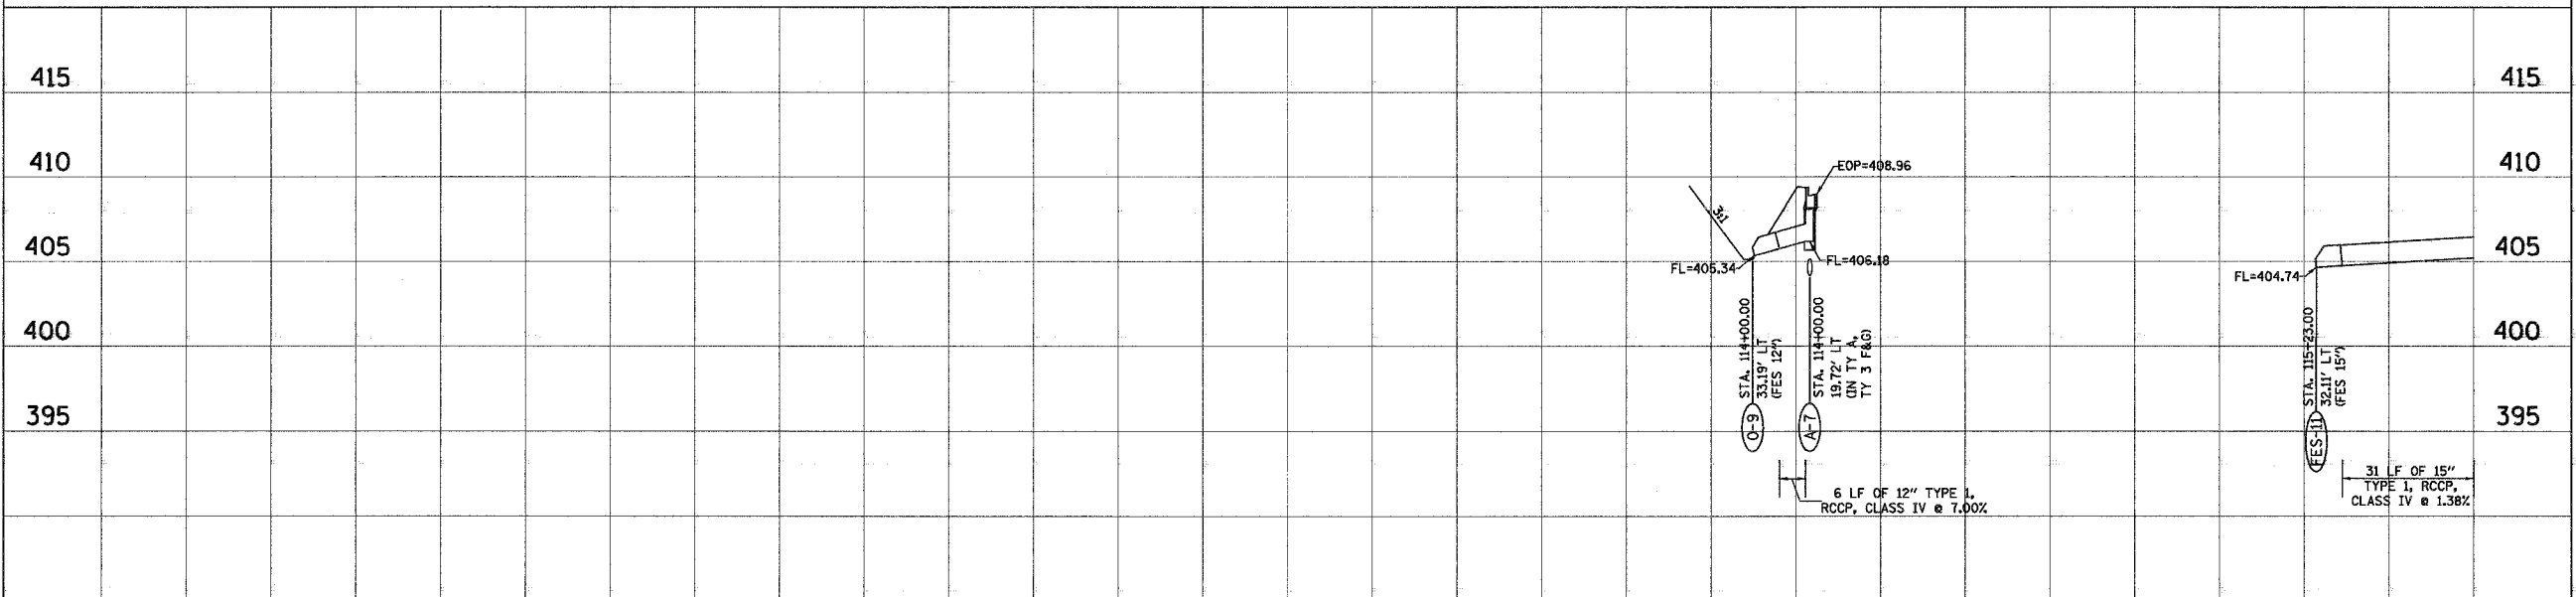

**JunEAU Associates, Inc. P.C.**  
CONSULTING ENGINEERS AND LAND SURVEYORS

2100 State Street, P.O. Box 1305  
Madison, IL 61702-1305  
Phone: (618) 937-7400 / (618) 937-8333  
Fax: (618) 937-8347

100 North Research Drive  
Springfield, IL 62702  
Phone: (618) 266-0200 / (618) 633-0800  
Fax: (618) 266-0911

REVISIONS			
NO.	DATE	BY	REMARKS
DWN. NO.:			

DRAINAGE PLAN & PROFILE			
OLD MADISON ROAD MADISON, ILLINOIS SECTION 05-00054-00-WR			
SCALE: 1 Inch = 20 feet			
DSN. BY: BFK	DATE: 06/06/07	SHEET	
DWN. BY: JDH	DATE: 06/06/07	44	
CHK'D: BFK	DATE: 06/06/07		
JOB NO: E061003	DGN. NAME: DRANS	OF 110 SHEETS	