


NORTH ELECTRICAL PLAN - LIGHTING
1" = 20'-0"

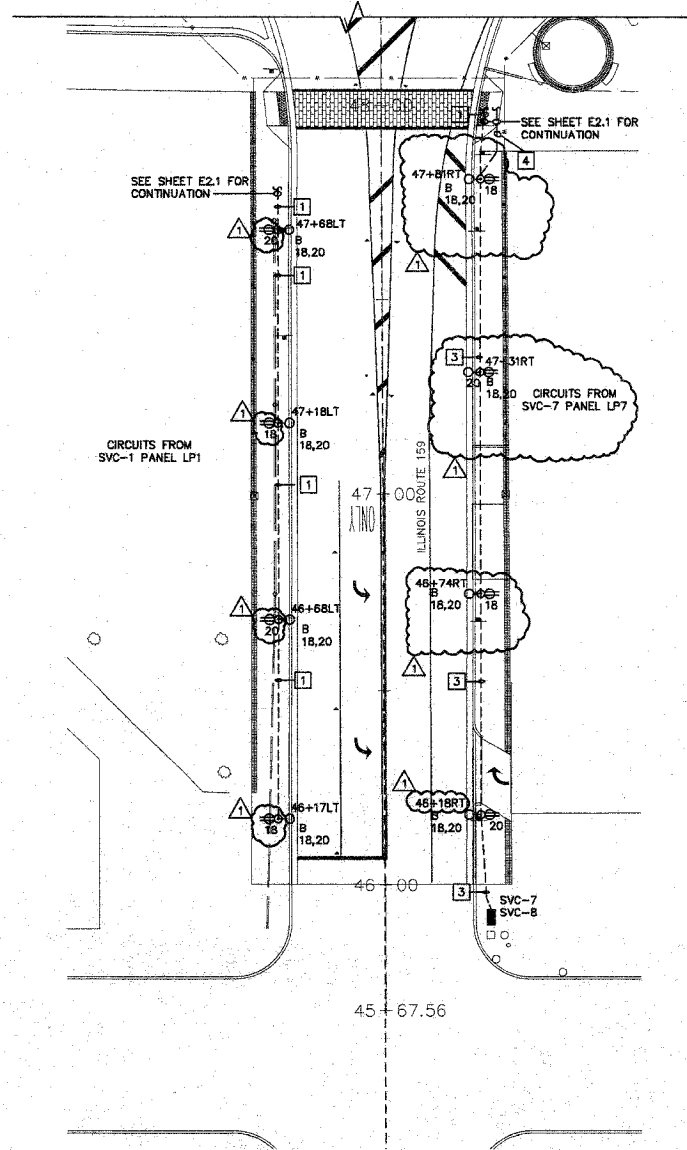

SOUTH ELECTRICAL PLAN - LIGHTING
1" = 20'-0"

- GENERAL NOTES**
1. CONTRACTOR SHALL LOCATE ALL EXISTING UTILITIES PRIOR TO BEGINNING CONSTRUCTION.
 2. UNLESS NOTED OTHERWISE, ALL CONDUIT SHALL BE PVC.
 3. ROUTE CONDUITS AROUND TREE PLANTING AREAS.
 4. ALL LIGHTING SHALL REMAIN OPERATIONAL UNTIL NEW IS INSTALLED AND MADE OPERATIONAL.
 5. SEE THE ELECTRICAL SCHEDULE ON SHEET E5.1 FOR LIGHT LOCATIONS.

- KEYED NOTES**
1. PROVIDE A 1 1/2" PVC CONDUIT WITH (2) #6, (1) #6N AND (1) #10G.
 2. PROVIDE A 1" PVC CONDUIT WITH (2) #10, (1) #10N AND (1) #10G.
 3. PROVIDE A 2 1/2" PVC CONDUIT WITH (2) #6, AND (1) #10 GROUND FOR S.E. PLAZA LIGHTS; AND (2) #6, (1) #6 NEUTRAL, AND (1) #10 GROUND FOR S.E. STREET LIGHTS.
 4. PROVIDE A 1 1/2" PVC CONDUIT WITH (2) #6, AND (1) #10G.

Kaskaskia Engineering Group L.L.C.
23 Public Square, Suite 404
Belleville, Illinois 62220
Office: (618) 253-9777 Fax: (618) 253-5977
www.kaskaskiaeng.com
A Disadvantaged Business Enterprise

PREPARED BY:
BRUCE J. BRICE
PROFESSIONAL ENGINEER
LICENSE NO. MA00073
STATE OF ILLINOIS

BRIC
PARTNERSHIP, LLC
CONSULTING ENGINEERS
100 EAST WASHINGTON, SUITE 220
BELLEVILLE, ILLINOIS 62220
TEL: 618.277.6300 FAX: 618.277.6327

Signature: _____
Expiration Date: _____

REV	DATE	DESCRIP
Δ	10/25/07	REVISION #1

SHEET TITLE: **NORTH AND SOUTH ELECTRICAL PLANS - LIGHTING**
PROJECT TITLE: **BELLEVILLE SQUARE CITY OF BELLEVILLE ST. CLAIR COUNTY, ILLINOIS**

DESIGNED BY: ESF	SHEET
DRAWN BY: GYN/ESF	35
CHECKED BY: BEC	E2.2
DATE OF PRELIMINARY: 08/17/2007	
DATE OF FINAL: _____	
SHEET NO. 4	OF 13 SHEETS
PROJECT NUMBER: 07.0041	

Δ Revised 11-5-07