


WEST ELECTRICAL PLAN - LIGHTING
1" = 20'-0"

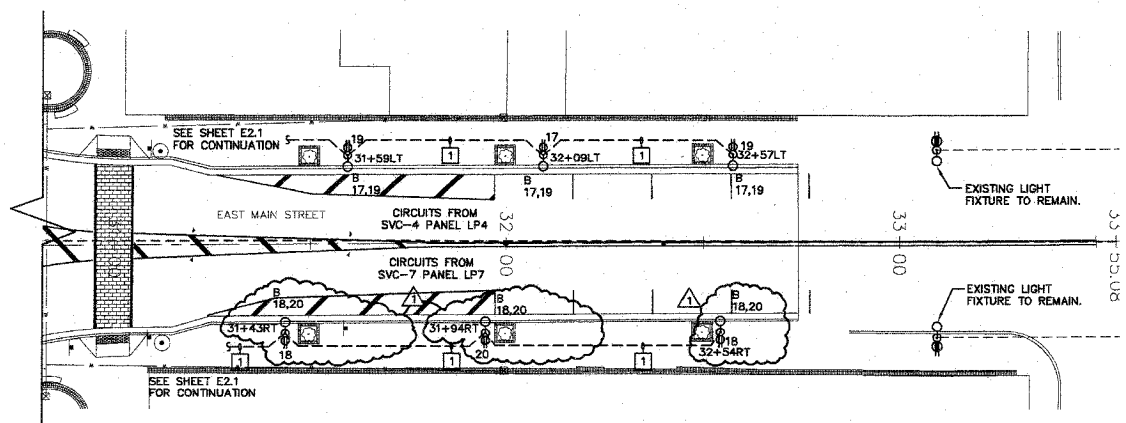

EAST ELECTRICAL PLAN - LIGHTING
1" = 20'-0"

GENERAL NOTES

1. CONTRACTOR SHALL LOCATE ALL EXISTING UTILITIES PRIOR TO BEGINNING CONSTRUCTION.
2. UNLESS NOTED OTHERWISE, ALL CONDUIT SHALL BE PVC.
3. ROUTE CONDUITS AROUND TREE PLANTING AREAS.
4. ALL LIGHTING SHALL REMAIN OPERATIONAL UNTIL NEW IS INSTALLED AND MADE OPERATIONAL.
5. ALL WORK ON EAST SIDE MUST BE COMPLETED PRIOR TO FESTIVAL (ART ON SQUARE).
6. SEE THE ELECTRICAL SCHEDULE ON SHEET E5.1 FOR LIGHT LOCATIONS.

KEYED NOTES

- 1 PROVIDE A 1 1/2" PVC CONDUIT WITH (2) #6, (1) #8N (1) #10G
- 2 REPLACE EXISTING FIXTURE. USE EXISTING WIRING IN PLACE. PROVIDE NECESSARY ANCHOR BOLT ADJUSTMENT TEMPLATE TO ACCOMMODATE NEW FIXTURE ANCHOR BOLTS.
- 3 EXISTING FIXTURE TO REMAIN. PROTECT EXISTING FIXTURE, WIRE, AND CONDUIT THROUGHOUT CONSTRUCTION.
- 4 CIRCUITING TO LIGHTING FIXTURES IN THIS AREA IS EXISTING TO REMAIN.
- 5 PROVIDE A 2 1/2" PVC CONDUIT WITH (2) #6, AND (1) #10 GROUND FOR S.W. PLAZA LIGHTS; AND (2) #6, (1) #6 NEUTRAL, AND (1) #10 GROUND FOR S.W. STREET LIGHTS. BORE UNDER WEST MAIN STREET.
- 6 PROVIDE A 2 1/2" PVC CONDUIT WITH (2) #6, AND (1) #10 GROUND FOR S.W. PLAZA LIGHTS; AND (2) #6, (1) #6 NEUTRAL, AND (1) #10 GROUND FOR S.W. STREET LIGHTS.

Kaskaskia Engineering Group L.L.C.
23 Public Square, Suite 404
Belleville, Illinois 62220
Office: (618) 235-5877 Fax: (618) 235-5977
www.kaskaskiaeng.com
A Division of Business Enterprise

PREPARED BY: [Signature]
PROFESSIONAL REGISTERED ENGINEER
ILLINOIS PROFESSIONAL ENGINEER NO. 14100773
EXPIRES 03/31/2008

BRIC
PARTNERSHIP LLC
CONSULTING ENGINEERS
100 EAST WASHINGTON, SUITE 220
ST. LOUIS, MISSOURI 63102
TEL: 618.277.5227

Signature: _____
Expiration Date: _____

REV	DATE	DESCRIP
1	10/25/07	REVISION #1

SHEET TITLE: **EAST AND WEST ELECTRICAL PLANS - LIGHTING**
PROJECT TITLE: **BELLEVILLE SQUARE CITY OF BELLEVILLE ST. CLAIR COUNTY, ILLINOIS**

DESIGNED BY: EST	SHEET
DRAWN BY: GY&JES	
CHECKED BY: BEC	36
DATE OF PRELIMINARY: 08/17/2007	E2.3
DATE OF FINAL:	
SHEET NO. 3	OF 13 SHEETS
PROJECT NUMBER: 07-0041	

△ Revised 11-5-07