


F.A. RTE.	SECTION	COUNTY	TOTAL SHEETS	SHEET NO.
		ST. CLAIR	10	5
STA.	TO STA.			
FED. ROAD DIST. NO.	ILLINOIS	FED. AID PROJECT		
CONTRACT NO. 44910				

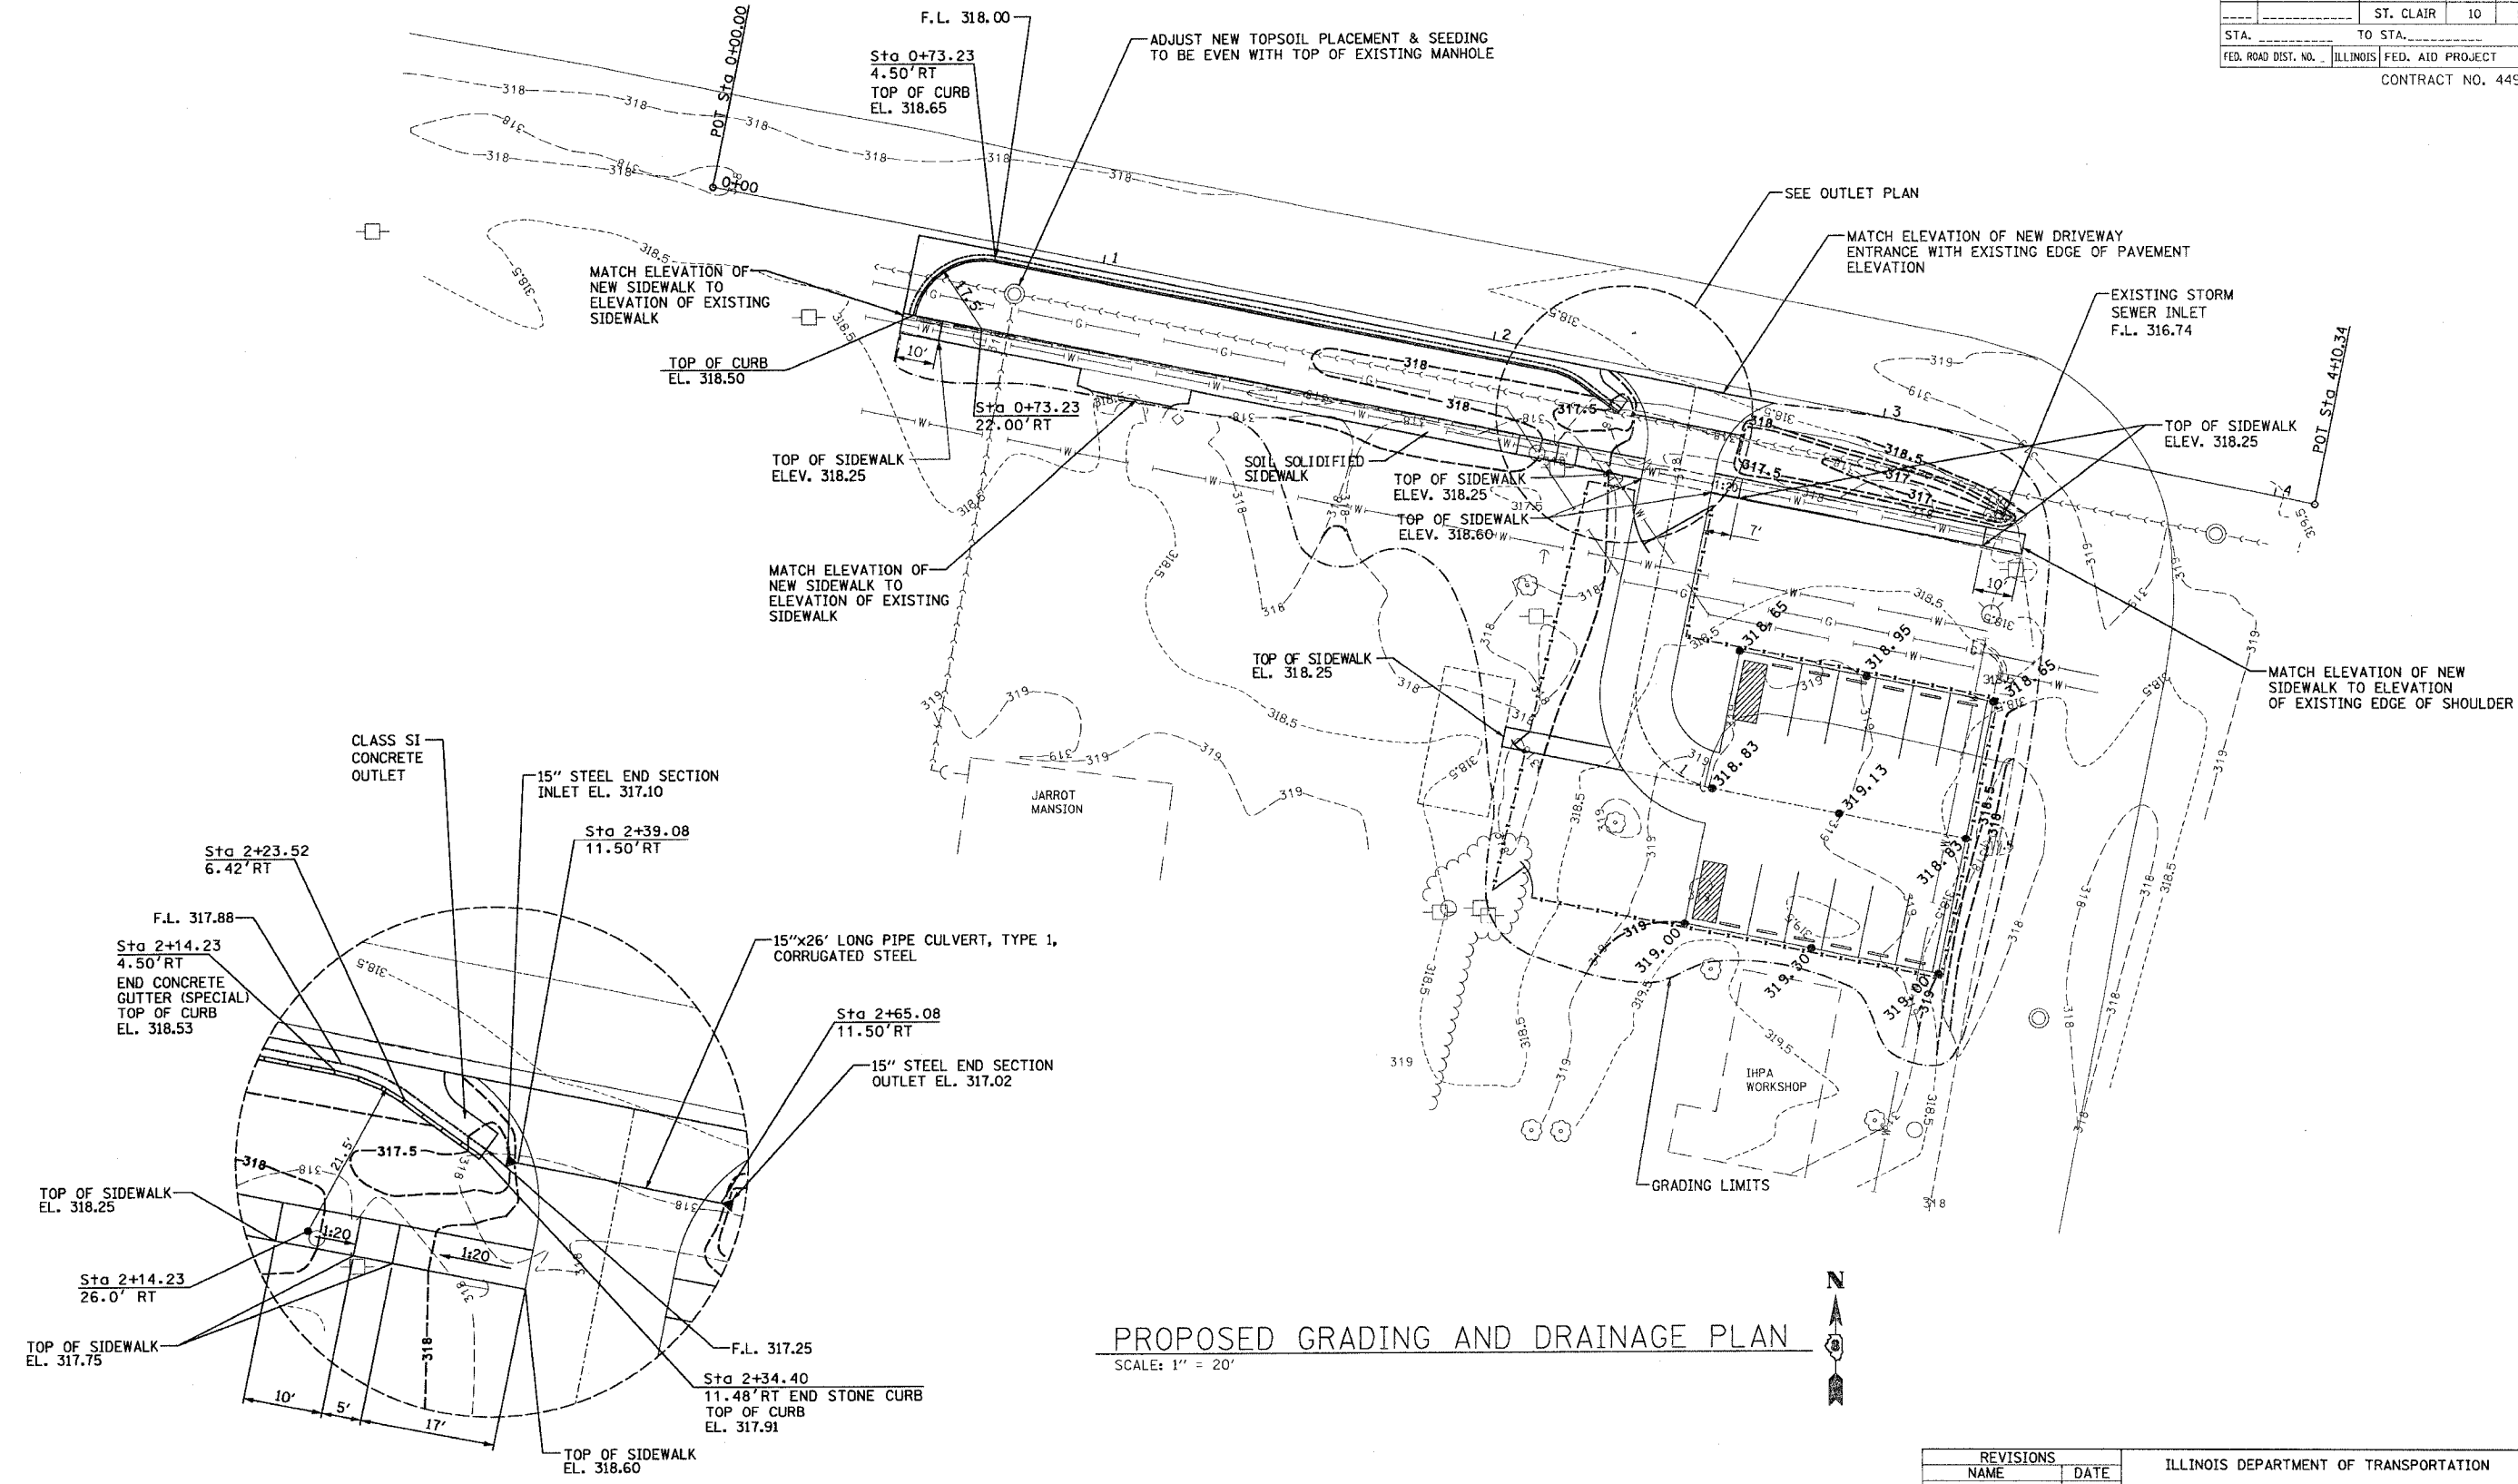

PROPOSED GRADING AND DRAINAGE PLAN
SCALE: 1" = 20'



ENLARGED PLAN
SCALE: 1" = 10'



REVISIONS	
NAME	DATE

ILLINOIS DEPARTMENT OF TRANSPORTATION
PROPOSED DRAINAGE PLAN
IDOT / IHPA
JARROT MANSION SITE
HISTORIC SITE
SCALE: 1:20
DATE: 4-12-06
DRAWN BY: EJR
CHECKED BY: KCM

DISTRICT PROJECT ENGINEER - LANCE KIDD