



STATE OF ILLINOIS  
DEPARTMENT OF TRANSPORTATION

ROUTE NO.	SECTION	COUNTY	TOTAL SHEETS	SHEET	SHEET NO. 100
F.A.I. 39	50-4B	LASALLE		122	313 SHEETS
FED. ROAD DIST. NO. 7	ILLINOIS	FED. AID PROJECT	Contract # 66586		

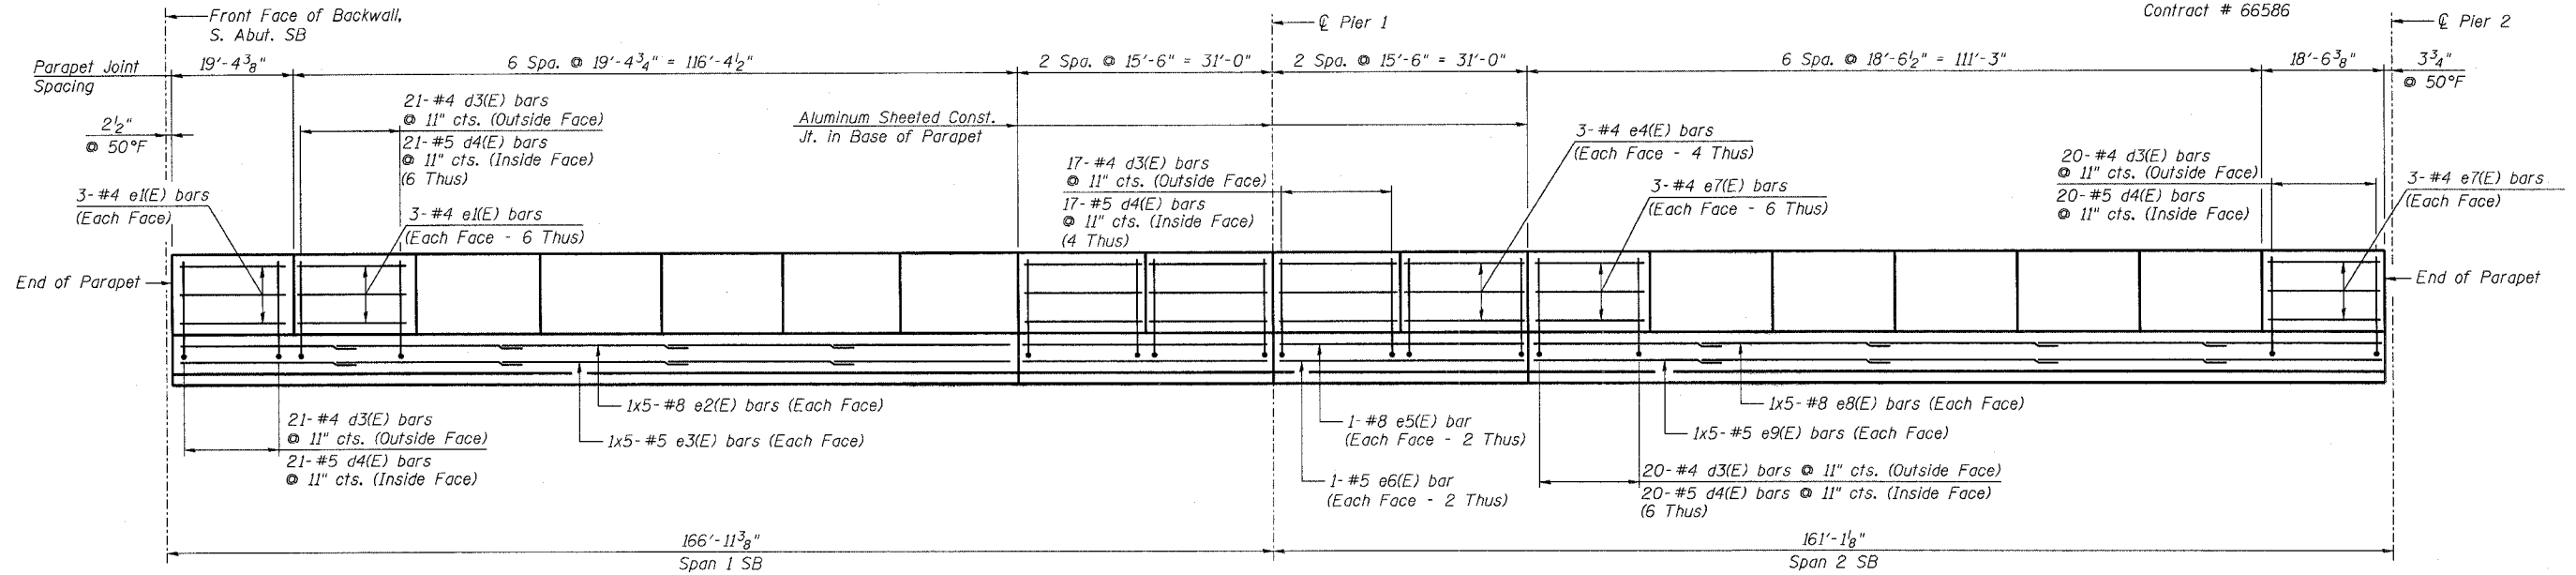

INSIDE ELEVATION OF OUTSIDE PARAPET - SB

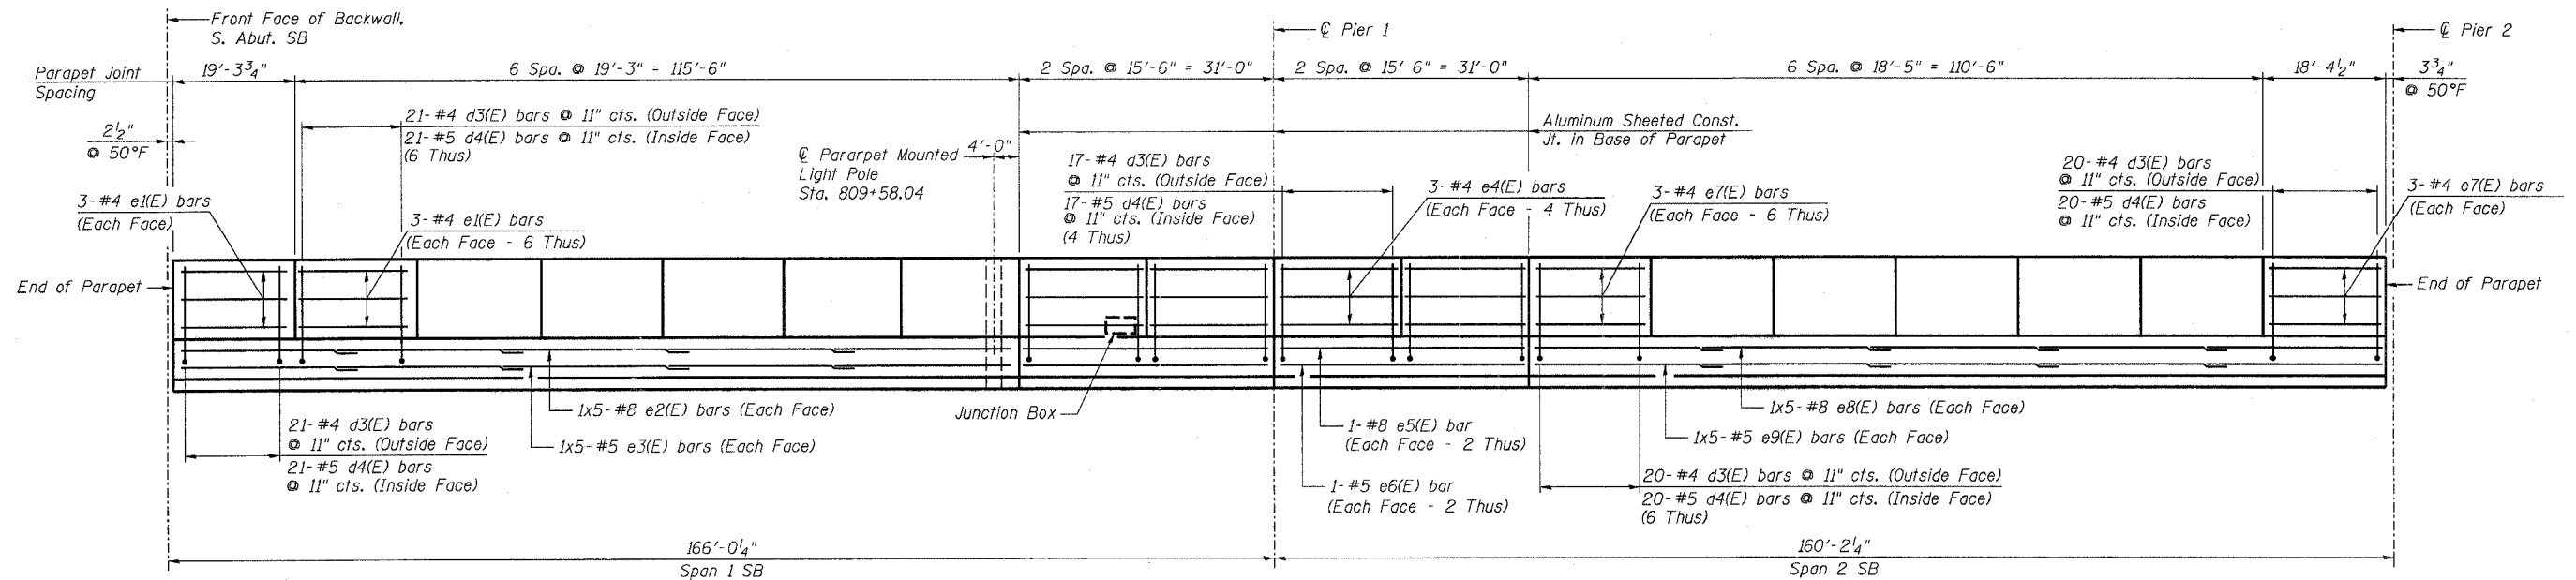

REFLECTED INSIDE ELEVATION OF MEDIAN PARAPET - SB

NOTES:

1. Reinforcement bars designated (E) shall be epoxy coated.
2. Bars indicated thus 3x4 - #4 etc. indicates 3 lines of bars with 4 lengths per line.
3. Use the following minimum lap lengths unless otherwise noted:
  - #4 - 1'-8"
  - #5 - 2'-2"
  - #8 - 4'-6"
4. For Bill of Material and Reinforcement schedule see sheet 102.
5. All edges have 3/4" chamfer.
6. For section through parapet see sheets 166 and 168.
7. For Parapet Mounted Light Pole detail and additional reinforcement see sheet 169.
8. Longitudinal dimensions and joint spacing are measured along the edge of slab.
9. For Junction Box locations, see Electrical Plans.
10. For additional rebar at Junction Box, see sheet 169.

DESIGNED -	AJK
CHECKED -	KWS
DRAWN -	AR
CHECKED -	MRB

PARAPET ELEVATION - SPANS 1 AND 2 SB  
ABRAHAM LINCOLN MEMORIAL BRIDGE OVER  
THE ILLINOIS RIVER (PUBLIC WATERS)  
F.A.I. ROUTE 39 SEC. (50-4B) BR  
LASALLE COUNTY  
STATION 863+16.00  
STRUCTURE NO. 050-0191 (SB & NB)

**benesch**  
alfred benesch & company  
Engineers - Surveyors - Planners  
205 North Michigan Avenue, Suite 2400  
Chicago, Illinois 60601  
312-565-0450  
Job # 3856

x:\3800s\3856\structures\lincoln memorial\final\plans\AL-dkpp0102.sht

9:01:31 AM

8/30/2006