


STATE OF ILLINOIS
DEPARTMENT OF TRANSPORTATION

ROUTE NO. F.A.I. 39	SECTION 50-4B	COUNTY LASALLE	SHEET 136	SHEET NO. 114 313 SHEETS
FED. ROAD DIST. NO. 7		ILLINOIS	FED. AID PROJECT-	

Contract # 66586

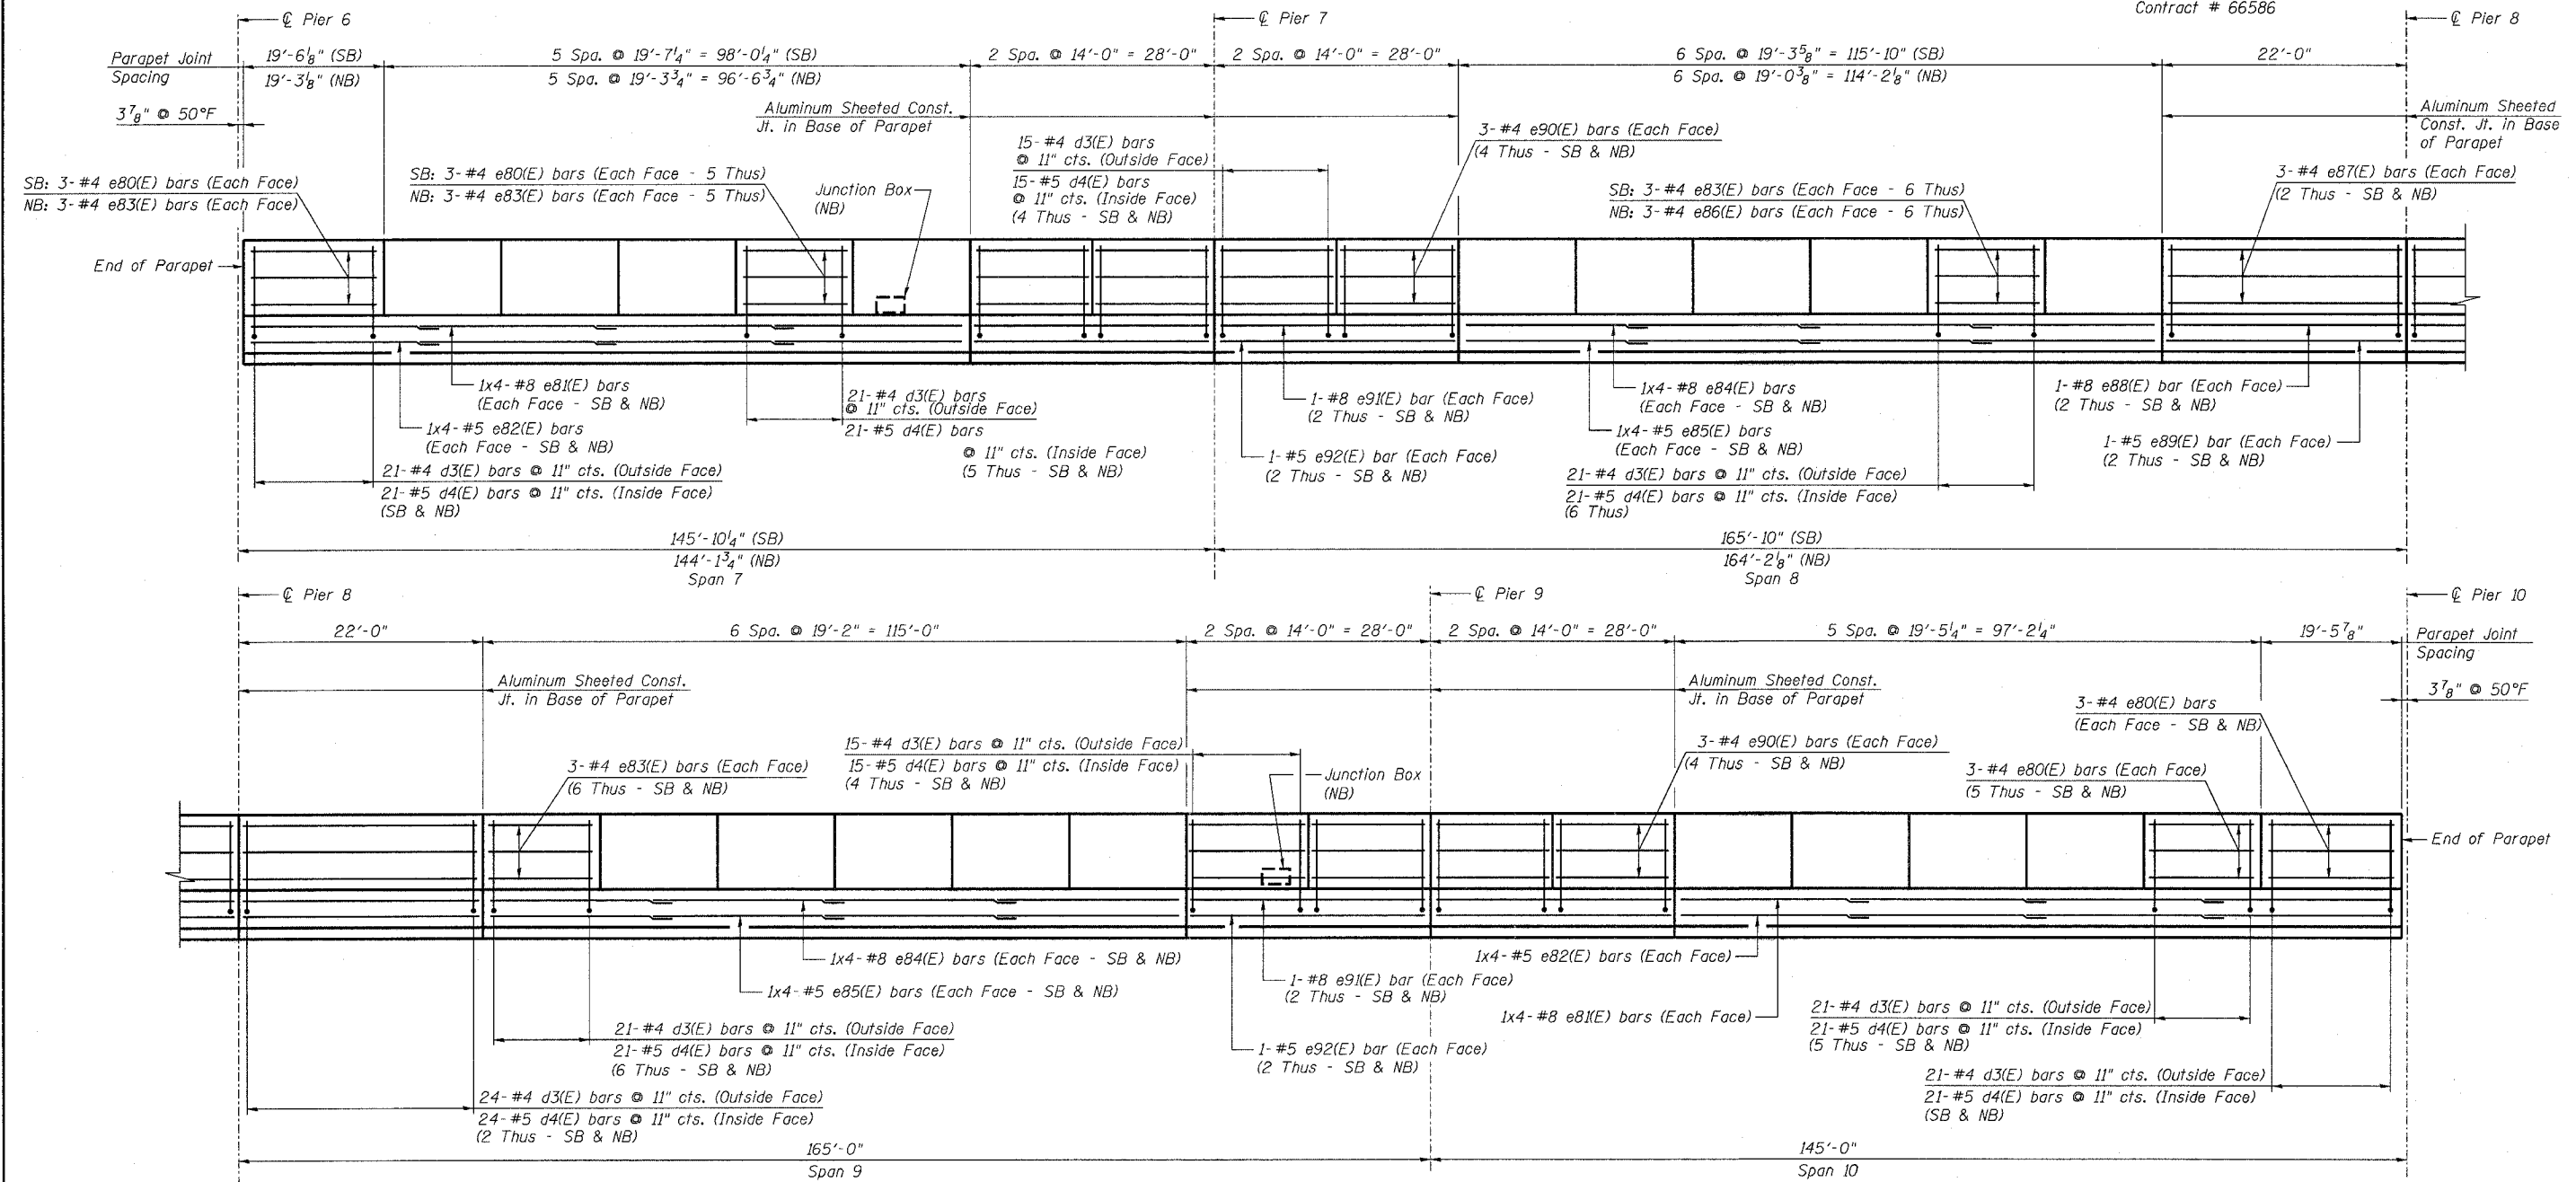

INSIDE ELEVATION OF OUTSIDE PARAPET - SB
REFLECTED INSIDE ELEVATION OF OUTSIDE PARAPET - NB

NOTES:

1. Reinforcement bars designated (E) shall be epoxy coated.
2. Bars indicated thus 3x4 - #4 etc. indicates 3 lines of bars with 4 lengths per line.
3. Use the following minimum lap lengths unless otherwise noted:
#4 - 1'-8"
#5 - 2'-2"
#8 - 4'-6"
4. For Bill of Material and Reinforcement schedule see sheet 116.
5. All edges have 3/4" chamfer.
6. For section through parapet see sheets 166 and 168.
7. Longitudinal dimensions and joint spacing are measured along the edge of slab.
8. For Junction Box locations, see Electrical Plans.
9. For additional rebar at Junction Box, see sheet 169.

DESIGNED -	AJK
CHECKED -	KWS
DRAWN -	AR
CHECKED -	MRB

PARAPET ELEVATION - SPANS 7 THRU 10
ABRAHAM LINCOLN MEMORIAL BRIDGE OVER
THE ILLINOIS RIVER (PUBLIC WATERS)
F.A.I. ROUTE 39 SEC. (50-4B) BR
LASALLE COUNTY
STATION 863+16.00
STRUCTURE NO. 050-0191 (SB & NB)

benesch

alfred benesch & company
Engineers • Surveyors • Planners
205 North Michigan Avenue, Suite 2400
Chicago, Illinois 60601
312-665-0450
Job # 3856

x:\3800s\3856\structures\abe\lincoln_memorial\final\plans\AL-dkpp070.sht

9/30/99 AM

8/30/2006