


STATE OF ILLINOIS
DEPARTMENT OF TRANSPORTATION

ROUTE NO.	SECTION	COUNTY	TOTAL SHEETS	SHEET NO.	SHEET NO. 118
F.A.I. 39	50-4B	LASALLE		140	313 SHEETS
FED. ROAD DIST. NO. 7	ILLINOIS	FED. AID PROJECT			

Contract # 66586

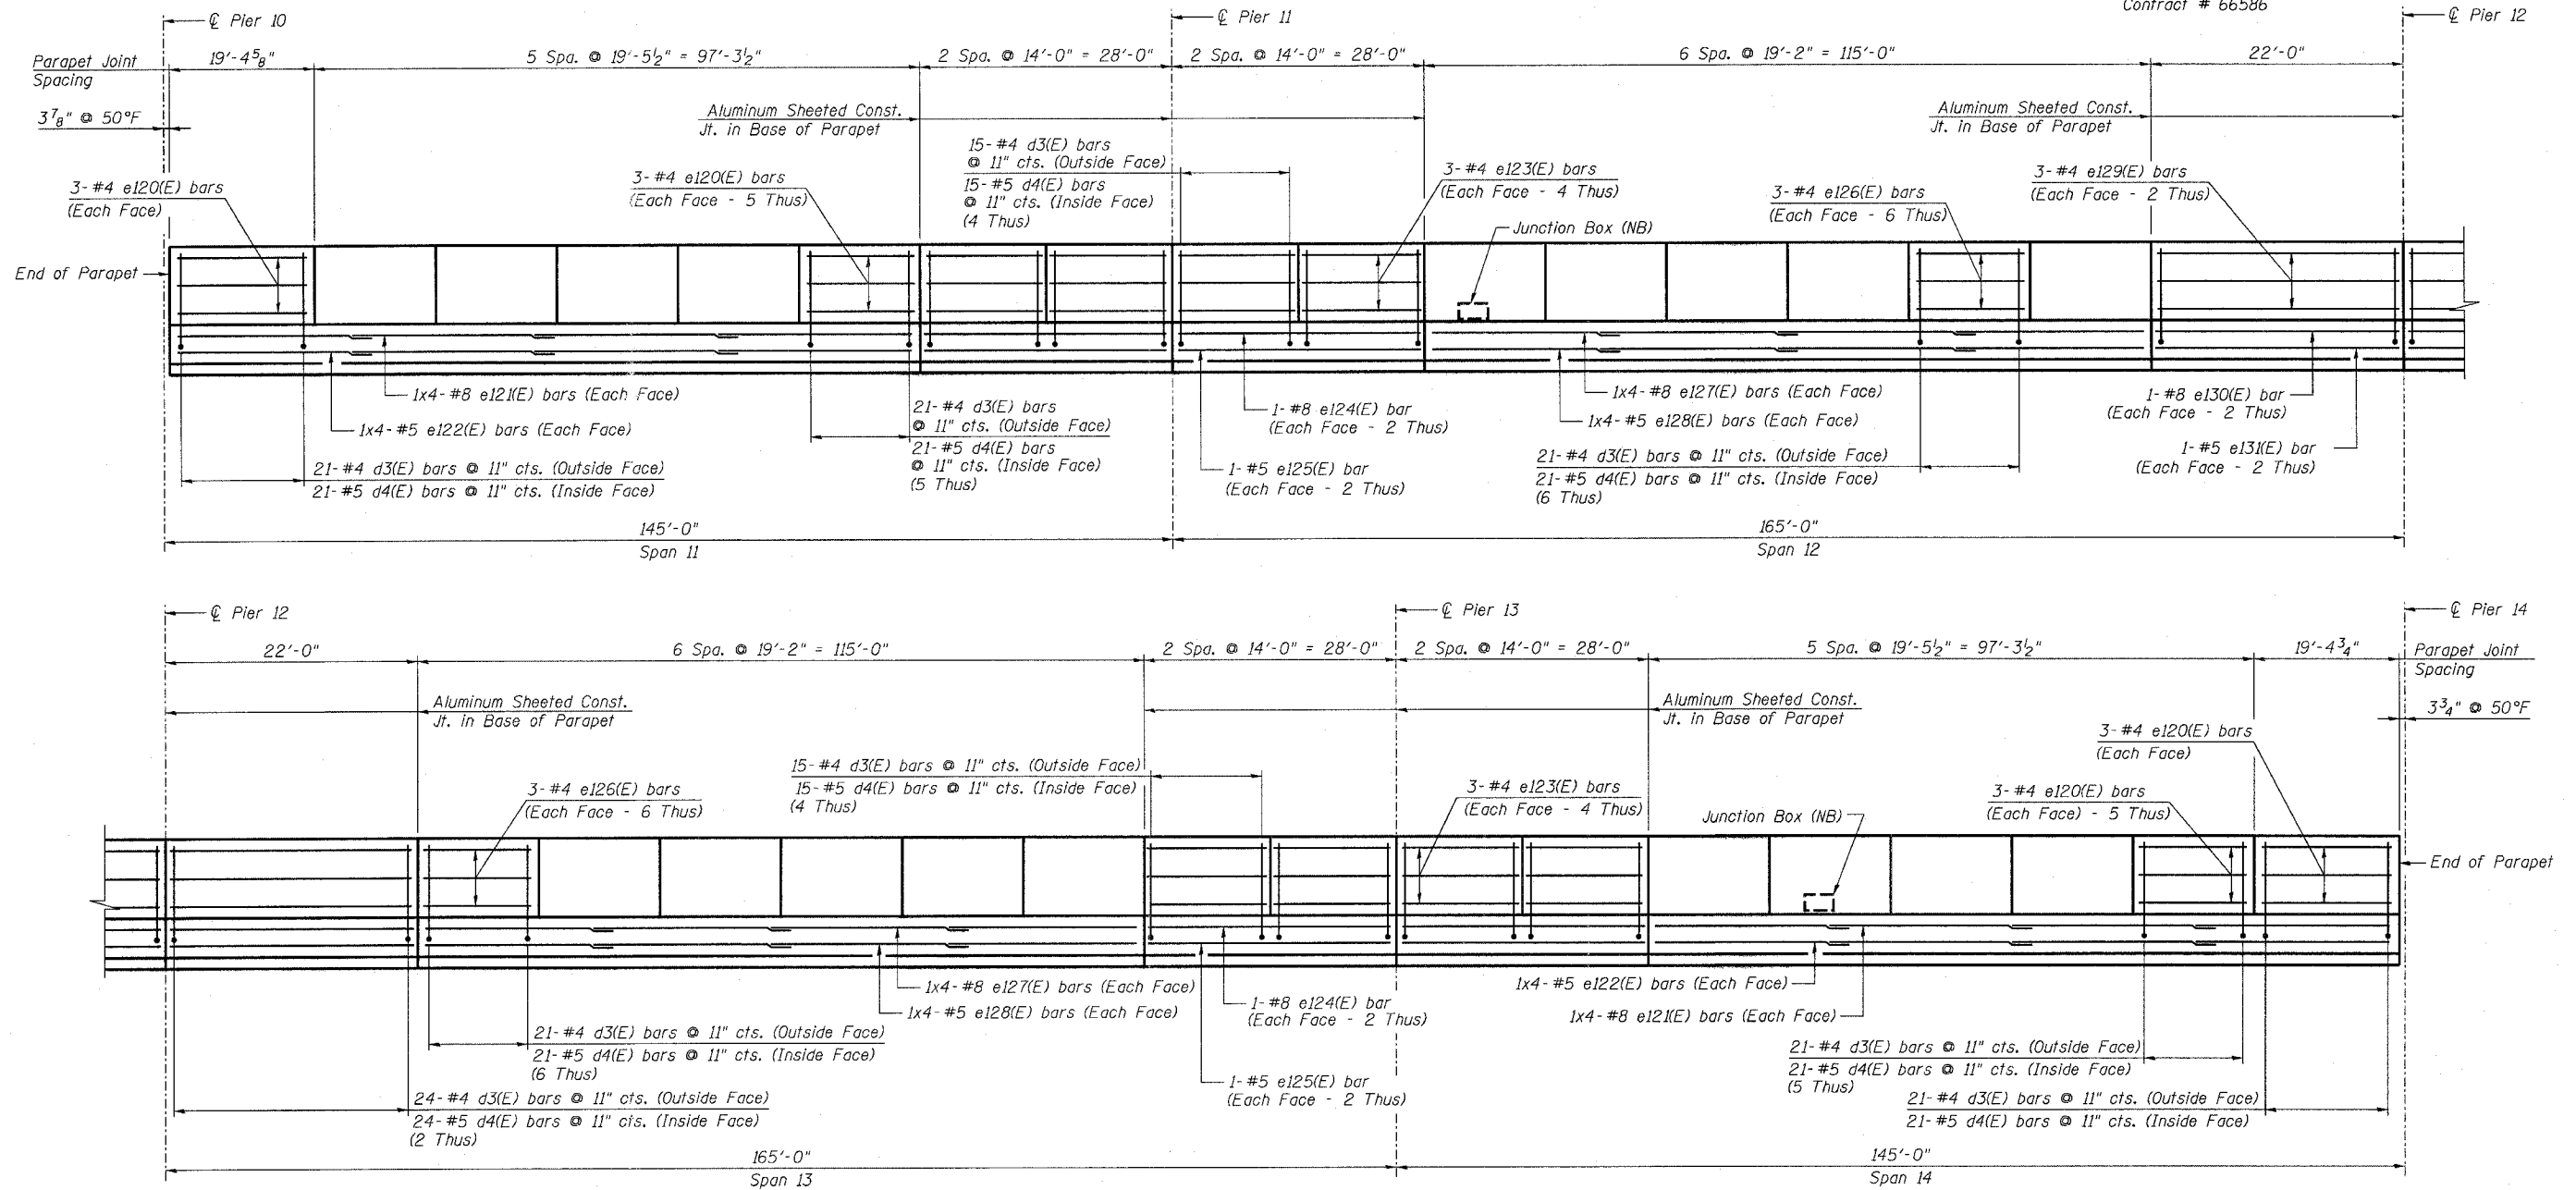

INSIDE ELEVATION OF OUTSIDE PARAPET - SB
REFLECTED INSIDE ELEVATION OF OUTSIDE PARAPET - NB

NOTES:

1. Reinforcement bars designated (E) shall be epoxy coated.
2. Bars indicated thus 3x4 - #4 etc. indicates 3 lines of bars with 4 lengths per line.
3. Use the following minimum lap lengths unless otherwise noted:
 - #4 - 1'-8"
 - #5 - 2'-2"
 - #8 - 4'-6"
4. For Bill of Material and Reinforcement schedule see sheet 120.
5. All edges have 3/4" chamfer.
6. For section through parapet see sheets 166 and 168.
7. For Junction Box locations, see Electrical Plans.
8. For additional rebar at Junction Box, see sheet 169.

DESIGNED -	AJK
CHECKED -	KWS
DRAWN -	AR
CHECKED -	MRB

PARAPET ELEVATION - SPANS 11 THRU 14
ABRAHAM LINCOLN MEMORIAL BRIDGE OVER
THE ILLINOIS RIVER (PUBLIC WATERS)
F.A.I. ROUTE 39 SEC. (50-4B) BR
LASALLE COUNTY
STATION 863+16.00
STRUCTURE NO. 050-0191 (SB & NB)

benesch

alfred benesch & company
Engineers • Surveyors • Planners
205 North Michigan Avenue, Suite 2400
Chicago, Illinois 60601
312-566-0450
Job # 3856

x:\3800s\3856\structures\abe\lincoln_memorial\final\plans\al_dkpp\114.sht

9:02:07 AM

8/30/2006