



STATE OF ILLINOIS  
DEPARTMENT OF TRANSPORTATION

ROUTE NO.	SECTION	COUNTY	SHEETS	SHEET	SHEET NO. 123
F.A.I. 39	50-4B	LASALLE		145	313 SHEETS
FED. ROAD DIST. NO. 7	ILLINOIS	FED. AID PROJECT			

Contract # 66586

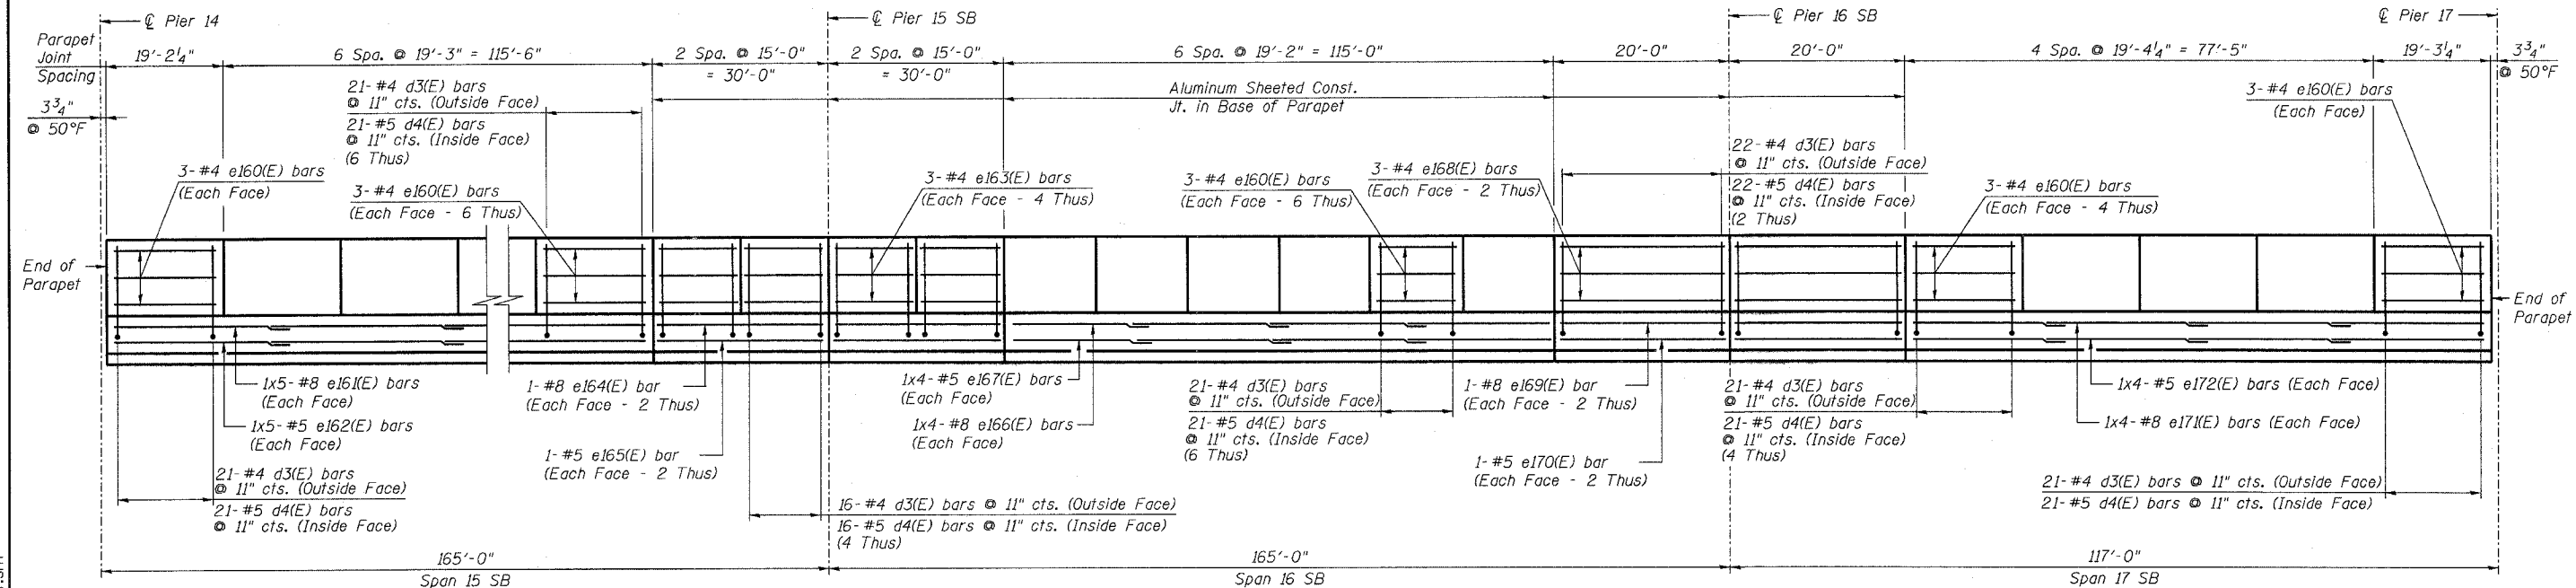

INSIDE ELEVATION OF OUTSIDE PARAPET

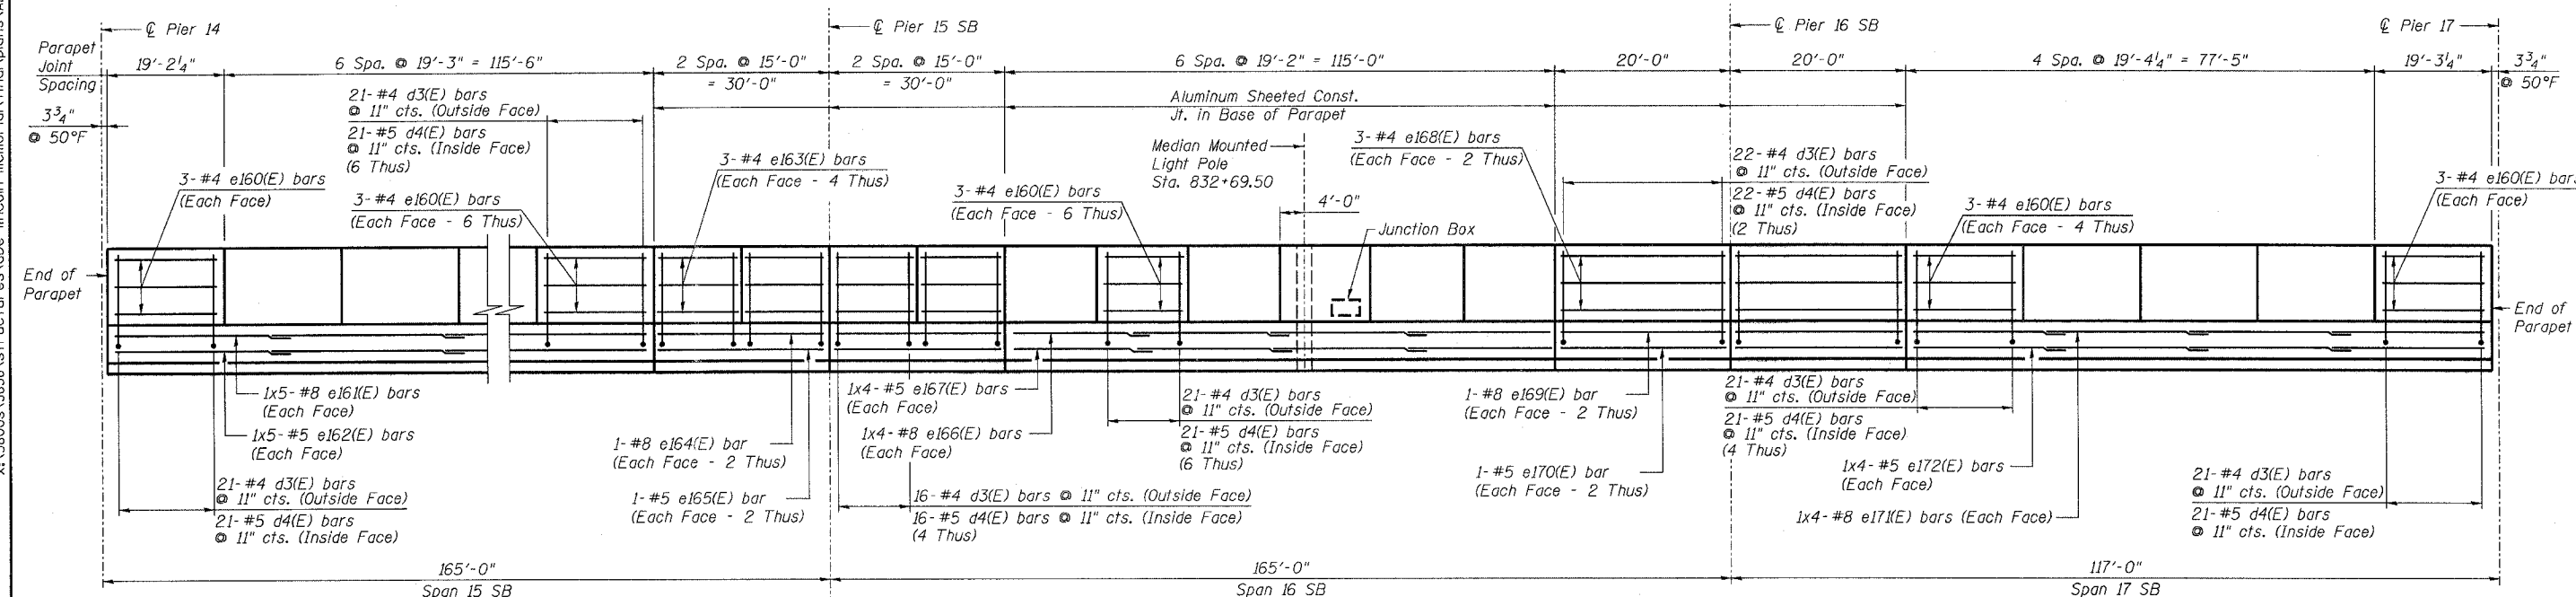

REFLECTED INSIDE ELEVATION OF MEDIAN PARAPET

- NOTES:**
1. Reinforcement bars designated (E) shall be epoxy coated.
  2. Bars indicated thus 3x4 - #4 etc. indicates 3 lines of bars with 4 lengths per line.
  3. Use the following minimum lap lengths unless otherwise noted:
    - #4 - 1'-8"
    - #5 - 2'-2"
    - #8 - 4'-6"
  4. For Bill of Material and Reinforcement schedule see sheet 125.
  5. All edges have 3/4" chamfer.
  6. For section through parapet see sheets 166 and 168.
  7. For Median Mounted Light Pole details and additional reinforcement see sheet 169.
  8. For Junction Box location, see Electrical Plans.
  9. For additional rebar at Junction Box, see sheet 169.

DESIGNED -	AJK
CHECKED -	KWS
DRAWN -	AR
CHECKED -	MRB

PARAPET ELEVATION - SPANS 15 THRU 17 SB  
 ABRAHAM LINCOLN MEMORIAL BRIDGE OVER  
 THE ILLINOIS RIVER (PUBLIC WATERS)  
 F.A.I. ROUTE 39 SEC. (50-4B) BR  
 LASALLE COUNTY  
 STATION 863+16.00  
 STRUCTURE NO. 050-0191 (SB & NB)

**benesch**  
 alfred benesch & company  
 Engineers - Surveyors - Planners  
 205 North Michigan Avenue, Suite 2400  
 Chicago, Illinois 60601  
 312-565-0450  
 Job # 3856

9:02:17 AM  
 x:\3800s\3856\structures\abe lincoln memorial\final\plans\VAL\_dkpp\517.sht  
 8/30/2006