



STATE OF ILLINOIS  
DEPARTMENT OF TRANSPORTATION

ROUTE NO. F.A.I. 39	SECTION 50-4B	COUNTY LASALLE	TOTAL SHEETS 174	SHEET NO. 313 SHEETS
FED. ROAD DIST. NO. 7		ILLINOIS		FED. AID PROJECT-

Contract # 66586

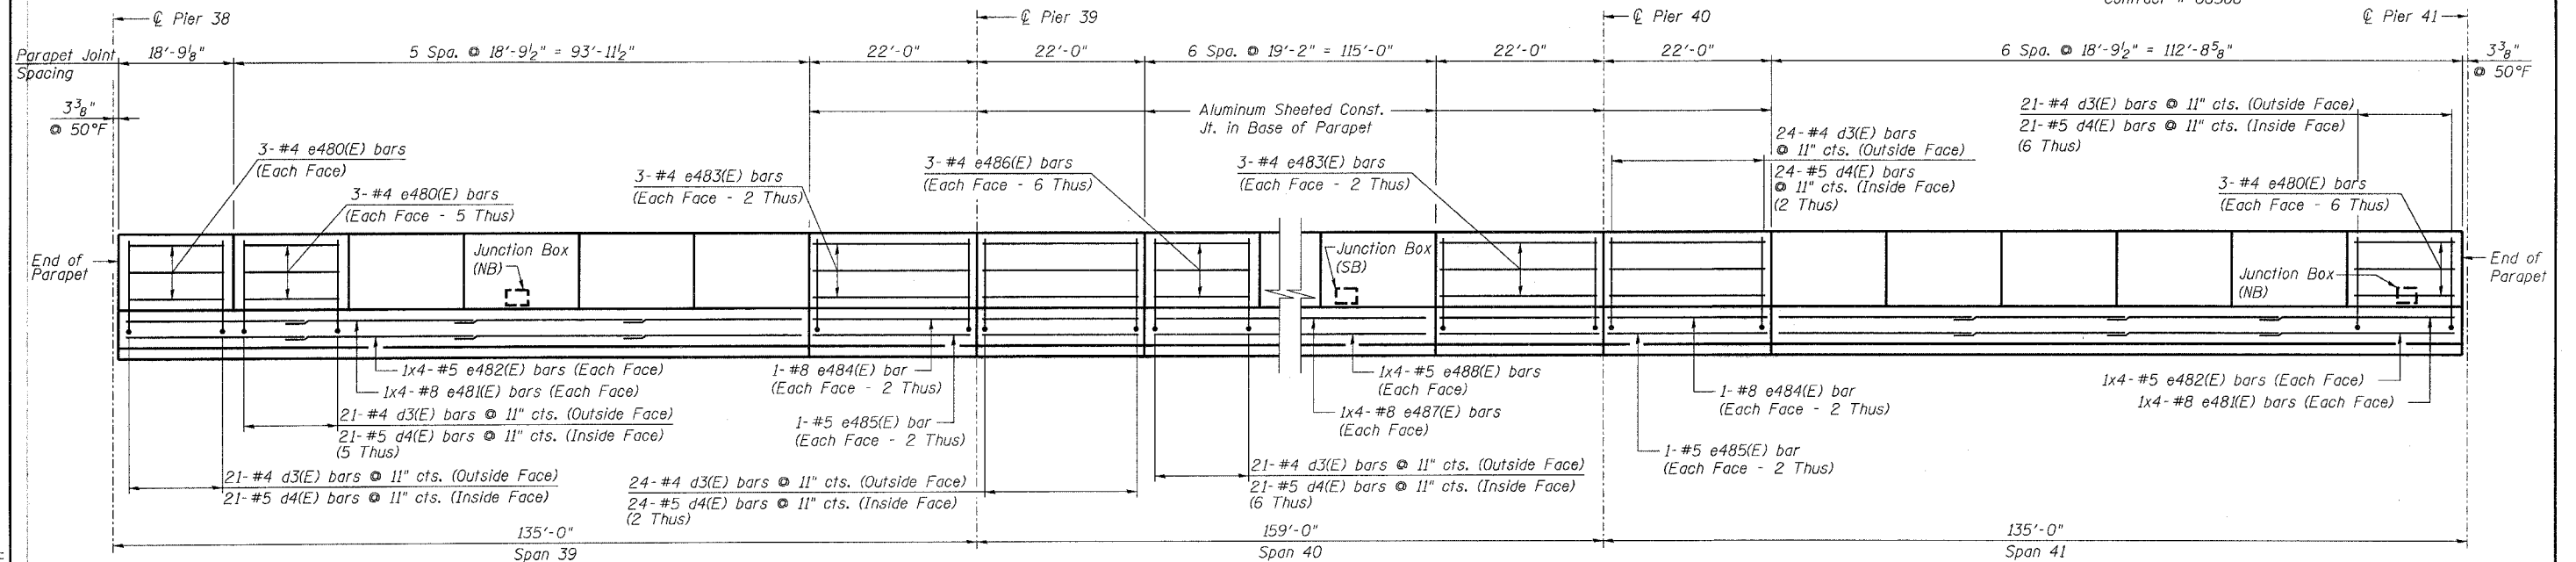

**INSIDE ELEVATION OF OUTSIDE PARAPET - SB**  
**REFLECTED INSIDE ELEVATION OF OUTSIDE PARAPET - NB**

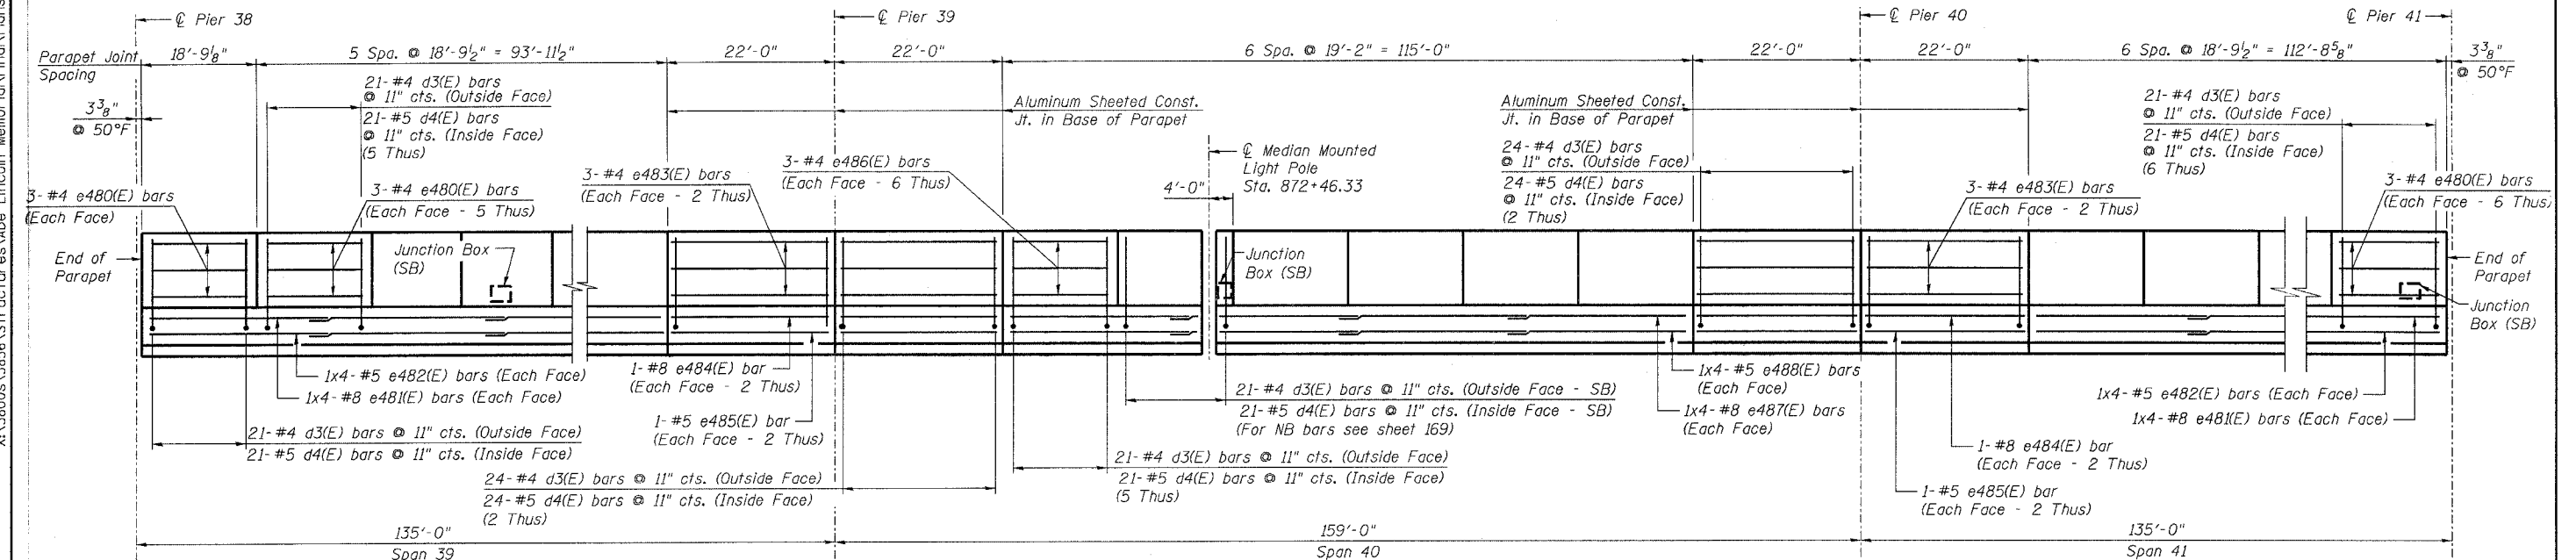

**INSIDE ELEVATION OF MEDIAN PARAPET - NB**  
**REFLECTED INSIDE ELEVATION OF MEDIAN PARAPET - SB**

**NOTES:**

- Reinforcement bars designated (E) shall be epoxy coated.
- Bars indicated thus 3x4 - #4 etc. indicates 3 lines of bars with 4 lengths per line.
- Use the following minimum lap lengths unless otherwise noted:
  - #4 - 1'-8"
  - #5 - 2'-2"
  - #8 - 4'-6"
- For Bill of Material and Reinforcement schedule see sheet 153.
- All edges have 3/4" chamfer.
- For section through parapet see sheets 166 and 168.
- For Median Mounted Light Pole details and additional reinforcement see sheet 169.
- For Junction Box locations, see Electrical Plans.
- For additional rebar at Junction Box, see sheet 169.

**PARAPET ELEVATIONS - SPANS 39 THRU 41**  
**ABRAHAM LINCOLN MEMORIAL BRIDGE OVER**  
**THE ILLINOIS RIVER (PUBLIC WATERS)**  
**F.A.I. ROUTE 39 SEC. (50-4B) BR**  
**LASALLE COUNTY**  
**STATION 863+16.00**  
**STRUCTURE NO. 050-0191 (SB & NB)**

**benesch**

alfred benesch & company  
Engineers • Surveyors • Planners  
205 North Michigan Avenue, Suite 2400  
Chicago, Illinois 60601  
312-565-0450  
Job # 3856

DESIGNED -	AJK
CHECKED -	KWS
DRAWN -	AR
CHECKED -	MRB

X:\3800s\3856\Structures\Abraham Lincoln Memorial\Final\Plans\AL-dkpp3941.sht

3:01:53 PM

10/16/2006