
 
 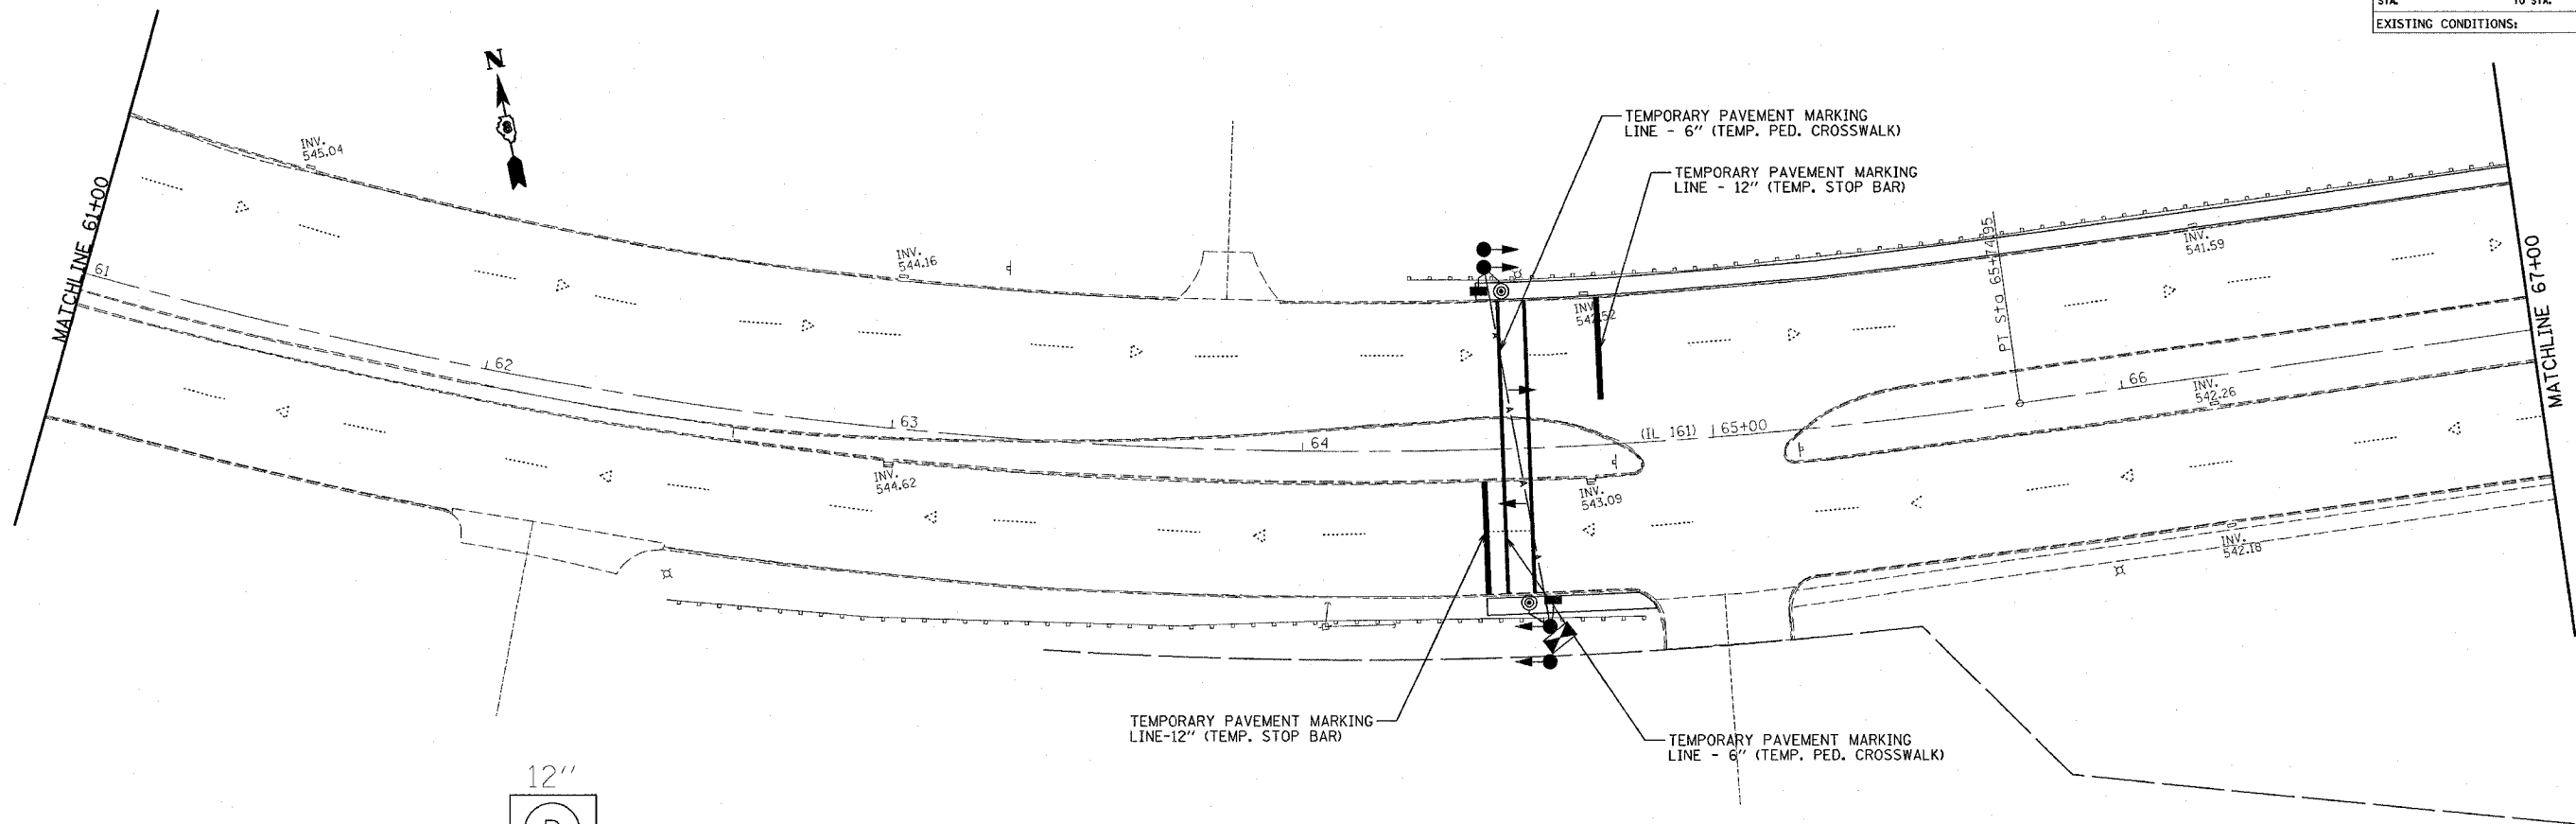


FAP NO.	SECTION	COUNTY	TOTAL SHEETS	SHEET NO.
805	122-VBR-1	ST. CLAIR	58	25
STA. TO STA.		EXISTING CONDITIONS:		




PLAN	DATE
SURVEYED	BY
ALIGNED	CHECKED
NOTE BOOK NO.	DATE
NO.	



PED. SIG. HEAD

PROPOSED TRAFFIC SIGNAL
FACES

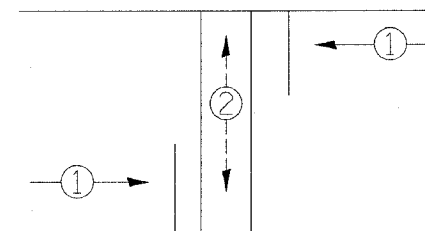

PHASE DESIGNATION DIAGRAM

LEGEND


- PROPOSED WOOD POST
- ➔ PROPOSED SIGNAL HEAD
- PROPOSED PEDESTRIAN SIGNAL HEAD
- ⊙ PROPOSED PUSH BUTTON
- ⊠ PROPOSED CONTROLLER

NOTES:

1. THE TEMPORARY TRAFFIC SIGNAL INSTALLATION SHALL BE IN ACCORDANCE WITH SECTION 890 OF THE STANDARD SPECIFICATIONS AND STANDARD 880001. THE CONTRACTOR SHALL SUBMIT FOR THE DISTRICTS' APPROVAL A DETAILED PLAN SHOWING THE LOACTIONS OF TEMPORARY POLES, PHASING, SIGNAL HEADS, PEDESTRIAN SIGNALS, AND PUSH-BUTTONS.
2. PEDESTRIAN PUSH-BUTTONS SHALL BE IN ACCORDANCE WITH ARTICLES 888.02 AND 888.03 OF THE STANDARD SPECIFICATIONS EXCEPT IT SHALL BE MOUNTED APPROXIMATELY THIRTY INCHES (30") ABOVE THE HANDICAPPED RAMP LEVEL AND SHALL BE WITHIN THE REACH OF HANDICAPPED PERSON.

PROPOSED SEQUENCE OF OPERATION		
PHASE	1	2
MOVEMENT	← →	↓ ↑ *

 *PEDESTRIAN SIGNALS UPON
ACTUATION ONLY



REVISIONS	
NAME	DATE

ILLINOIS DEPARTMENT OF TRANSPORTATION
TEMPORARY TRAFFIC SIGNAL PLAN
FAP ROUTE 805 (IL161)
SECTION 122VBR-1
ST. CLAIR COUNTY

DRAWN BY:

PLOT DATE: 10/19/2006