


 
COOK COUNTY

LYONS TOWNSHIP

VILLAGE OF JUSTICE

81ST STREET

F.A.J. RTE.	SECTION	COUNTY	TOTAL SHEETS	SHEET NO.
	05-00032-00-LT	COOK	8	4
CONTRACT NO. 83870				
FED. ROAD DIST. NO.	ILLINOIS	FED. AID PROJECT		

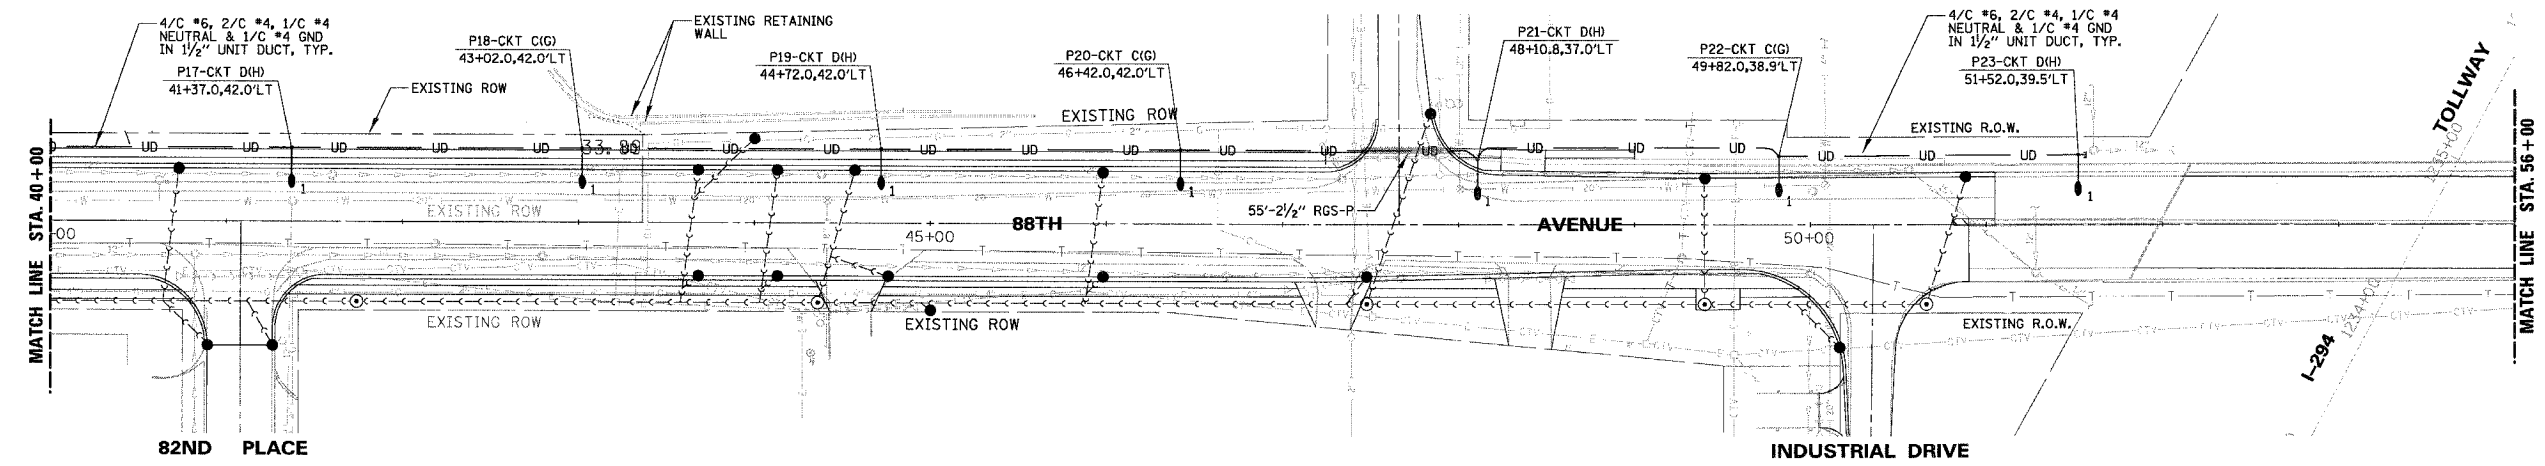

COOK COUNTY


LYONS TOWNSHIP

VILLAGE OF JUSTICE

79TH PLACE

79TH STREET

CORK AVENUE

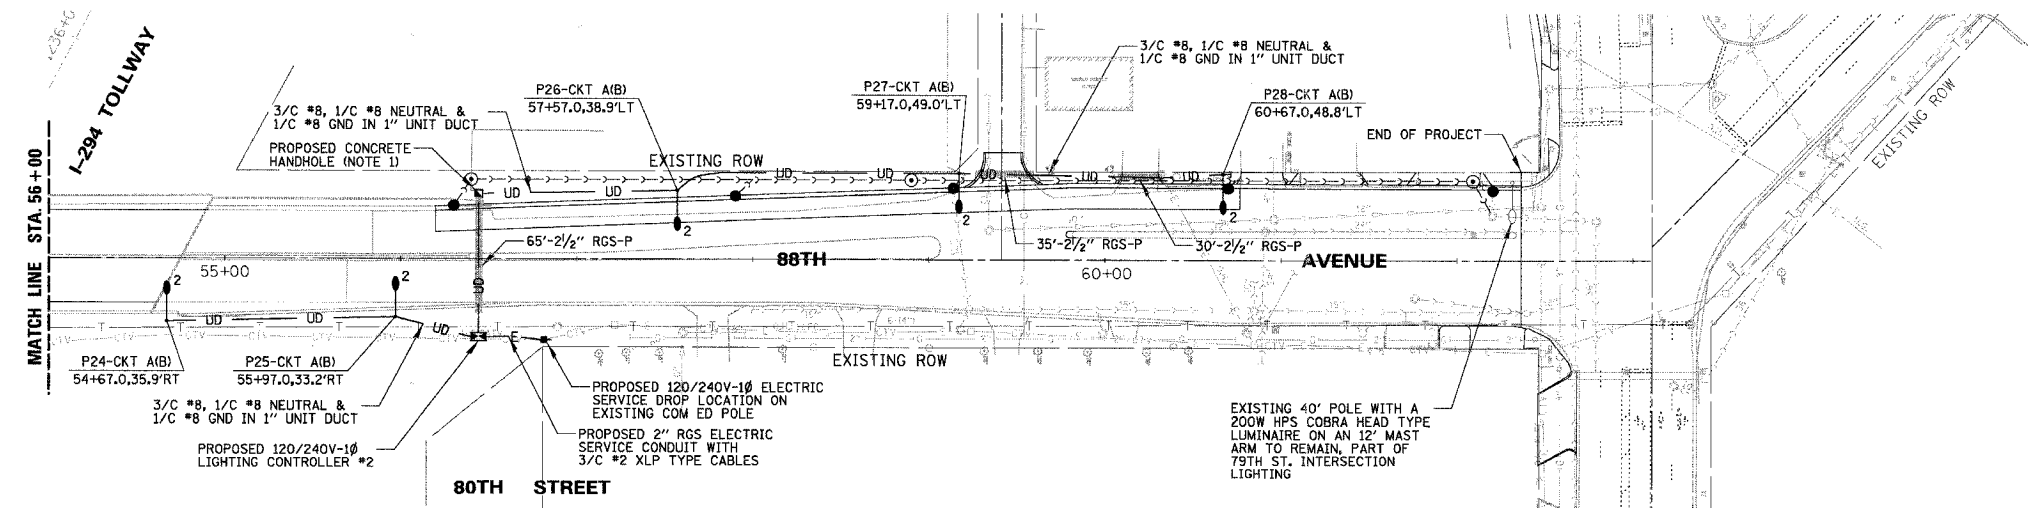

LEGEND

- 1 PROPOSED POLE TYPE 1 - 40' ALUMINUM POLE WITH A 250 WATT MCIII COBRA HEAD TYPE LUMINAIRE ON A 15' MAST ARM
- 2 PROPOSED POLE TYPE 2 - 47.5' ALUMINUM POLE WITH A 250 WATT MCIII COBRA HEAD TYPE LUMINAIRE ON A 15' MAST ARM
- EXISTING 40' ALUMINUM POLE WITH A 200 OR 250 WATT MCIII COBRA HEAD TYPE LUMINAIRE ON AN 8' OR 12' MAST ARM
- PROPOSED CONCRETE HANDHOLE
- PROPOSED 120/240V-1Ø LIGHTING CONTROLLER
- UD PROPOSED CABLES IN UNIT DUCT (SIZES AS SHOWN)
- UD PROPOSED UNIT DUCT IN RIGID GALVANIZED STEEL CONDUIT PUSHED UNDER PAVEMENT (SIZES AS SHOWN)
- E PROPOSED CABLES IN RIGID GALVANIZED STEEL CONDUIT (SIZES AS SHOWN)
- POLE NUMBER
- LUMINAIRE CIRCUIT ID
- RECEPTACLE CIRCUIT ID
- OFFSET
- STATION

NOTES:
1. NO SPLICING SHALL BE ALLOWED IN CONCRETE HANDHOLES. SPLICING ALLOWED IN POLE HANDHOLES ONLY.

CAUTION
NOTICE TO CONTRACTOR

THE CONTRACTOR IS SPECIFICALLY CAUTIONED THE LOCATION AND/OR ELEVATION OF EXISTING AND PROPOSED UTILITIES AS SHOWN ON THESE PLANS. THE INFORMATION IS NOT TO BE RELIED ON AS BEING EXACT OR COMPLETE. THE CONTRACTOR MUST CALL THE LOCAL UTILITY LOCATION CENTER AT LEAST 72 HOURS BEFORE ANY EXCAVATION TO REQUEST EXACT FIELD LOCATIONS OF THE UTILITIES. IT SHALL BE THE RESPONSIBILITY OF THE CONTRACTOR TO INFORM ENGINEER OF ANY EXISTING UTILITIES WHICH CONFLICT WITH THE PROPOSED IMPROVEMENTS.

REVISIONS		ILLINOIS DEPARTMENT OF TRANSPORTATION
NAME	DATE	
		<p>88TH AVENUE ROADWAY LIGHTING PLAN-2 STA. 40+00 TO STA. 60+67</p> <p>SCALE: 50' DRAWN BY: AJD DESIGN BY: AJD DATE: 8/22/2006 CHECKED BY: JPC</p>

SPENTBL\$