




WASHINGTON STREET


F.A.U. RTE.	SECTION	COUNTY	TOTAL SHEETS	SHEET NO.
1545	00-00115-00-BR	DUPAGE	97	15
STA. 1+31.77		TO STA. 5+50.00		
FED. ROAD DIST. NO.	ILLINOIS	FED. AID PROJECT		
CONTRACT 83961				

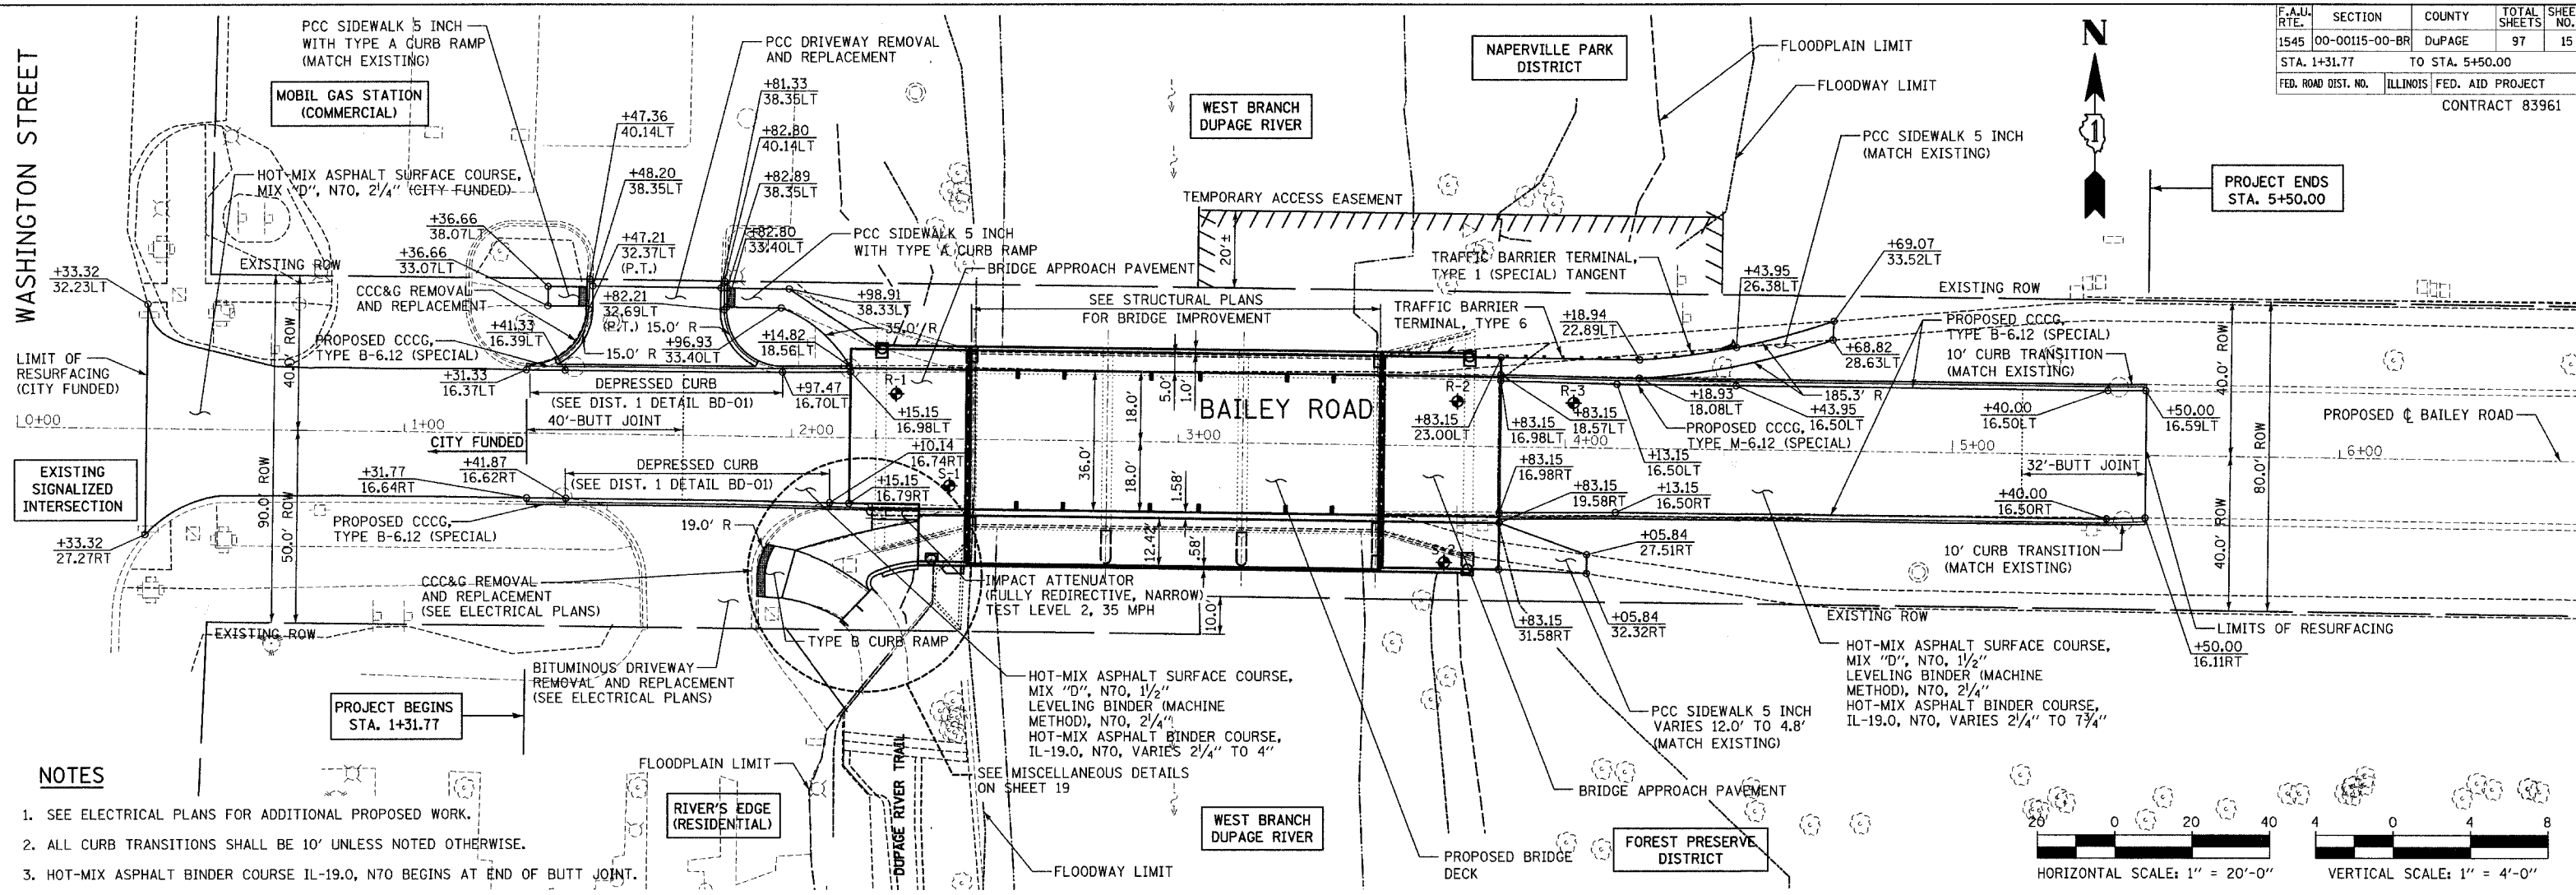

NOTES

1. SEE ELECTRICAL PLANS FOR ADDITIONAL PROPOSED WORK.
2. ALL CURB TRANSITIONS SHALL BE 10' UNLESS NOTED OTHERWISE.
3. HOT-MIX ASPHALT BINDER COURSE IL-19.0, N70 BEGINS AT END OF BUTT JOINT.

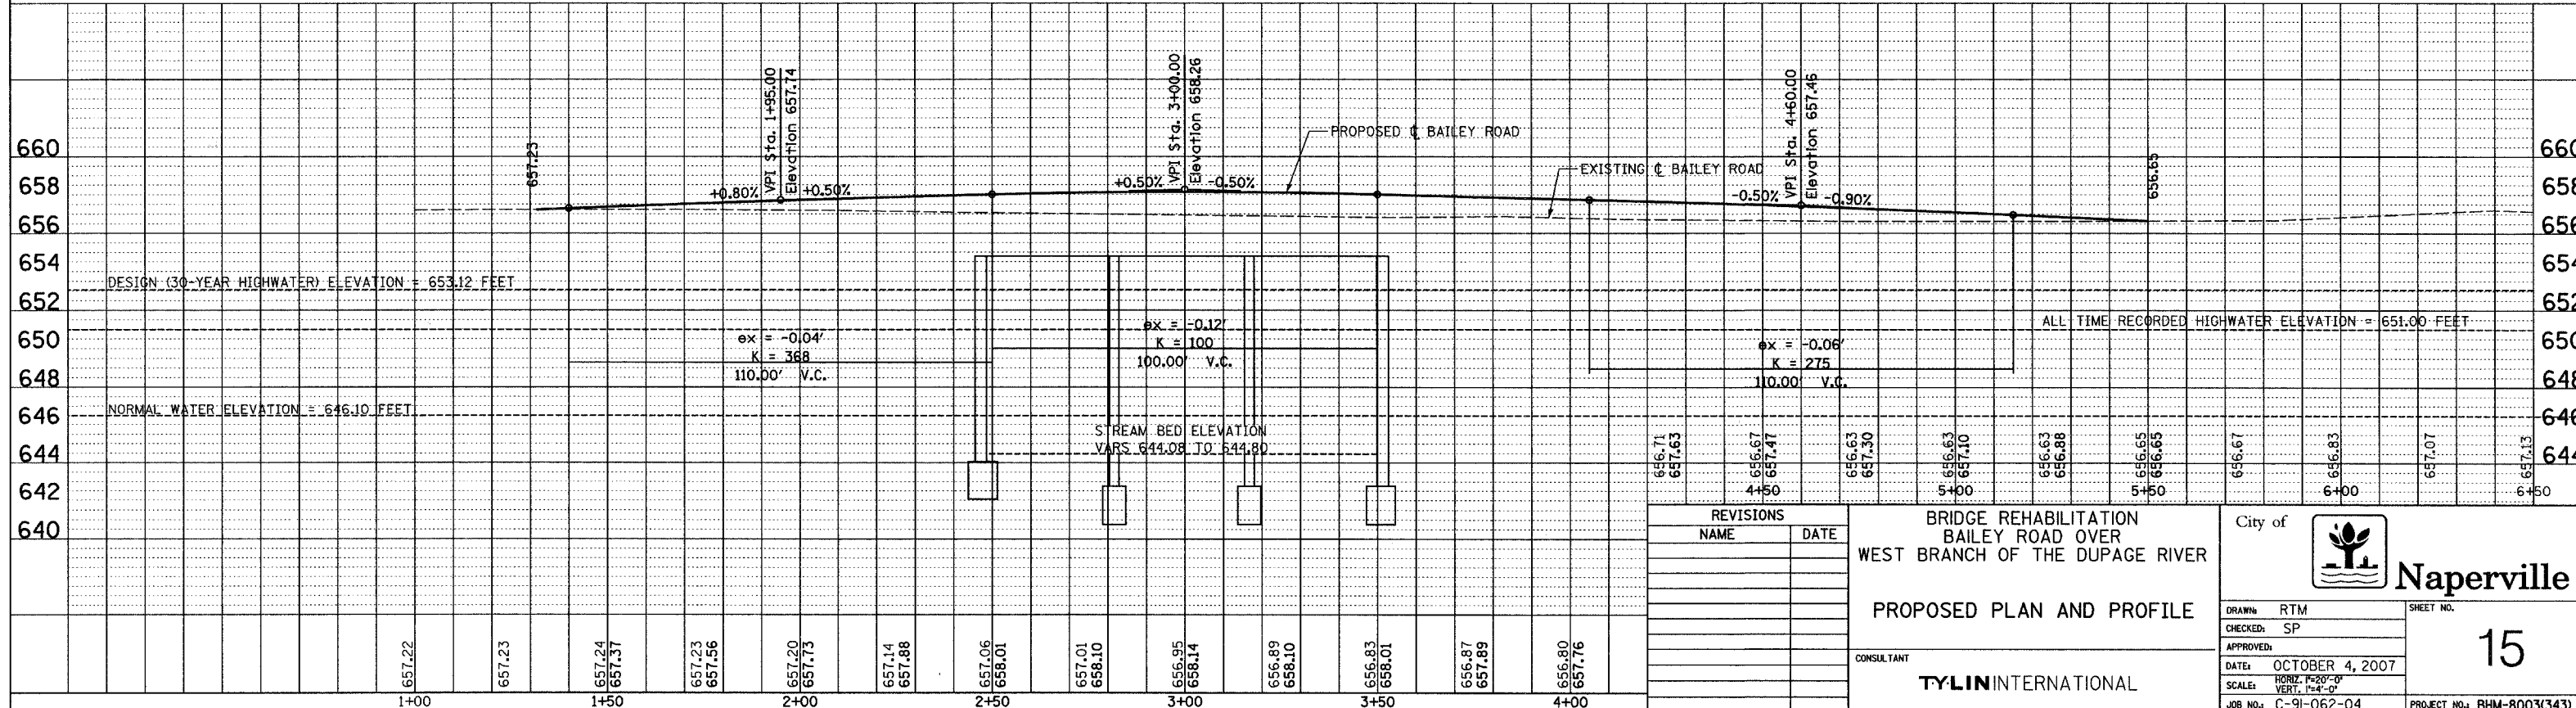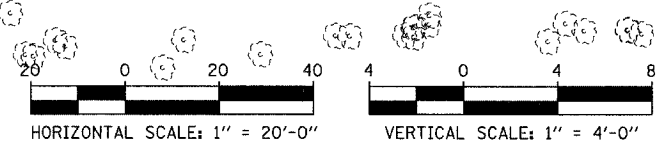

REVISIONS NAME DATE		BRIDGE REHABILITATION BAILEY ROAD OVER WEST BRANCH OF THE DUPAGE RIVER PROPOSED PLAN AND PROFILE	City of  Naperville	
DRAWN: RTM CHECKED: SP				SHEET NO. <h1>15</h1>
DATE: OCTOBER 4, 2007				
SCALE: HORIZ. 1"=20'-0" VERT. 1"=4'-0"				
CONSULTANT TYLIN INTERNATIONAL		JOB NO.: C-91-062-04 PROJECT NO.: BHM-8003(343)		