

ROUTE NO.	SECTION	CITY	TOTAL SHEETS	SHEET NO.
FAU 9835	02-00037-00-PV	GREENVILLE	25	1
FED. ROAD DIST. NO.		ILLINOIS	PROJECT M-5078 (6)	

FEDERAL AID PROJECT
CONTRACT No 972 82

STATE OF ILLINOIS
DEPARTMENT OF TRANSPORTATION
PLANS FOR
PROPOSED LOCAL AGENCY IMPROVEMENT
FEDERAL AID URBAN PROJECT

PLAN 1" = 20'
SCALES PROFILE HOR. 1" = 20'
PROFILE VERT. 1" = 5'
CROSS SECTIONS HOR. 1" = 5'
VERT. 1" = 2'


CITY OF GREENVILLE, ILLINOIS

ELM - WALNUT - GRIGG STREETS IMPROVEMENTS


FAU 9835
SECTION 02-00037-00-PV
PROJECT M-5078 (6)
C - 98-307-05
BOND COUNTY, ILLINOIS

DOT STANDARDS

- 280 001-02 Temporary Erosion Control System (3)
- 420 001-06 Pavement Joints (2)
- 420 101-03 24' Jointed PCC Pavement (1)
- 420 111-01 PCC Pavement Roundouts (2)
- 424 001-04 Curb Ramps for Sidewalks (2)
- 602 301-01 Inlet, Type A (1)
- 602 306-01 Inlet, Type B-1
- 602 401-01 Manhole, Type A (1)
- 602 601 Precast Reinforced Concrete Flat Slab Top (1)
- 604 001-02 Frames and lids, Type 1 (1)
- 606 001-02 Concrete Curb and Combination Concrete Curb and Gutter (2)
- 702 001-02 Traffic Control Devices (3)
- 780 001-01 Typical Pavement Markings (2)
- BLR22-4 Typical Application of Traffic Control Devices (1)

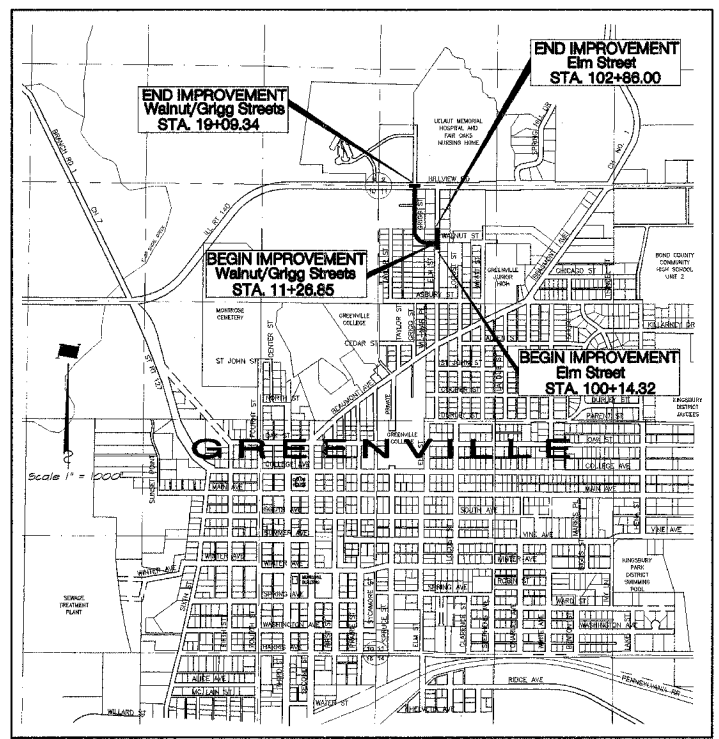

LOCATION MAP
TOTAL LENGTH OF PROJECT = 1054.17 FEET = 0.200 MILES
NET LENGTH OF PROJECT = 1054.17 FEET = 0.200 MILES
DESIGN DESIGNATION
124 (24) COLLECTOR 0.061 (PCC-20)

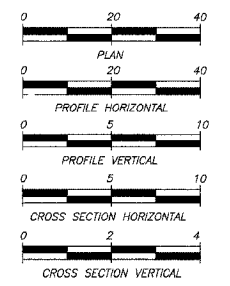

N O T E
Underground facilities, structures and utilities have been plotted from available surveys and records and their locations must be considered approximate only. There may be others, the existence of which is presently not known. The depth of utilities is assumed to be normal and customary. Contractor shall verify location and depth of all utilities prior to construction.

IT'S THE LAW IN ILLINOIS
PRIOR TO COMMENCING ANY CONSTRUCTION OR EXCAVATION, THE CONTRACTOR SHALL VERIFY THE LOCATION OF ALL UTILITIES BY CALLING:
J.U.L.I.E. * 1 - 8 0 0 - 8 9 2 - 0 1 2 3

* Joint Utilities Locating Information for Excavators.

INDEX TO SHEETS
SEE SHEET NO. 2

MICHAEL H. PRICE
31058
REGISTERED PROFESSIONAL ENGINEER
OF ILLINOIS
by *Michael H. Price*
date *08/01/06*
expires *NOV.30, 2007*

STATE OF ILLINOIS
DEPARTMENT OF TRANSPORTATION
CITY OF GREENVILLE, ILLINOIS
APPROVED *August 4, 2006* *David C. Willey* CITY MANAGER
APPROVED *August 29, 2006* *Michael H. Price* DISTRICT B ENGINEER OF LOCAL ROADS & STREETS
Releasing for Bid Based on Limited Review *August 29, 2006* *Mary C. Lame* DEPUTY DIRECTOR OF HIGHWAYS REGION FIVE ENGINEER