


ALL DIMENSIONS IN METERS EXCEPT PAVEMENT ITEMS AND UNLESS NOTED OTHERWISE

F.A.I. RTE.	SECTION	COUNTY	TOTAL SHEETS	SHEET NO.
80/94	2626.2-R-2	COOK/LAKE	1207	55
STA.		TO STA.		
FED. ROAD DIST. NO.		ILLINOIS FED. AID PROJECT		
CONTRACT NO. 62114		INDOT DES. NO. 0100987		

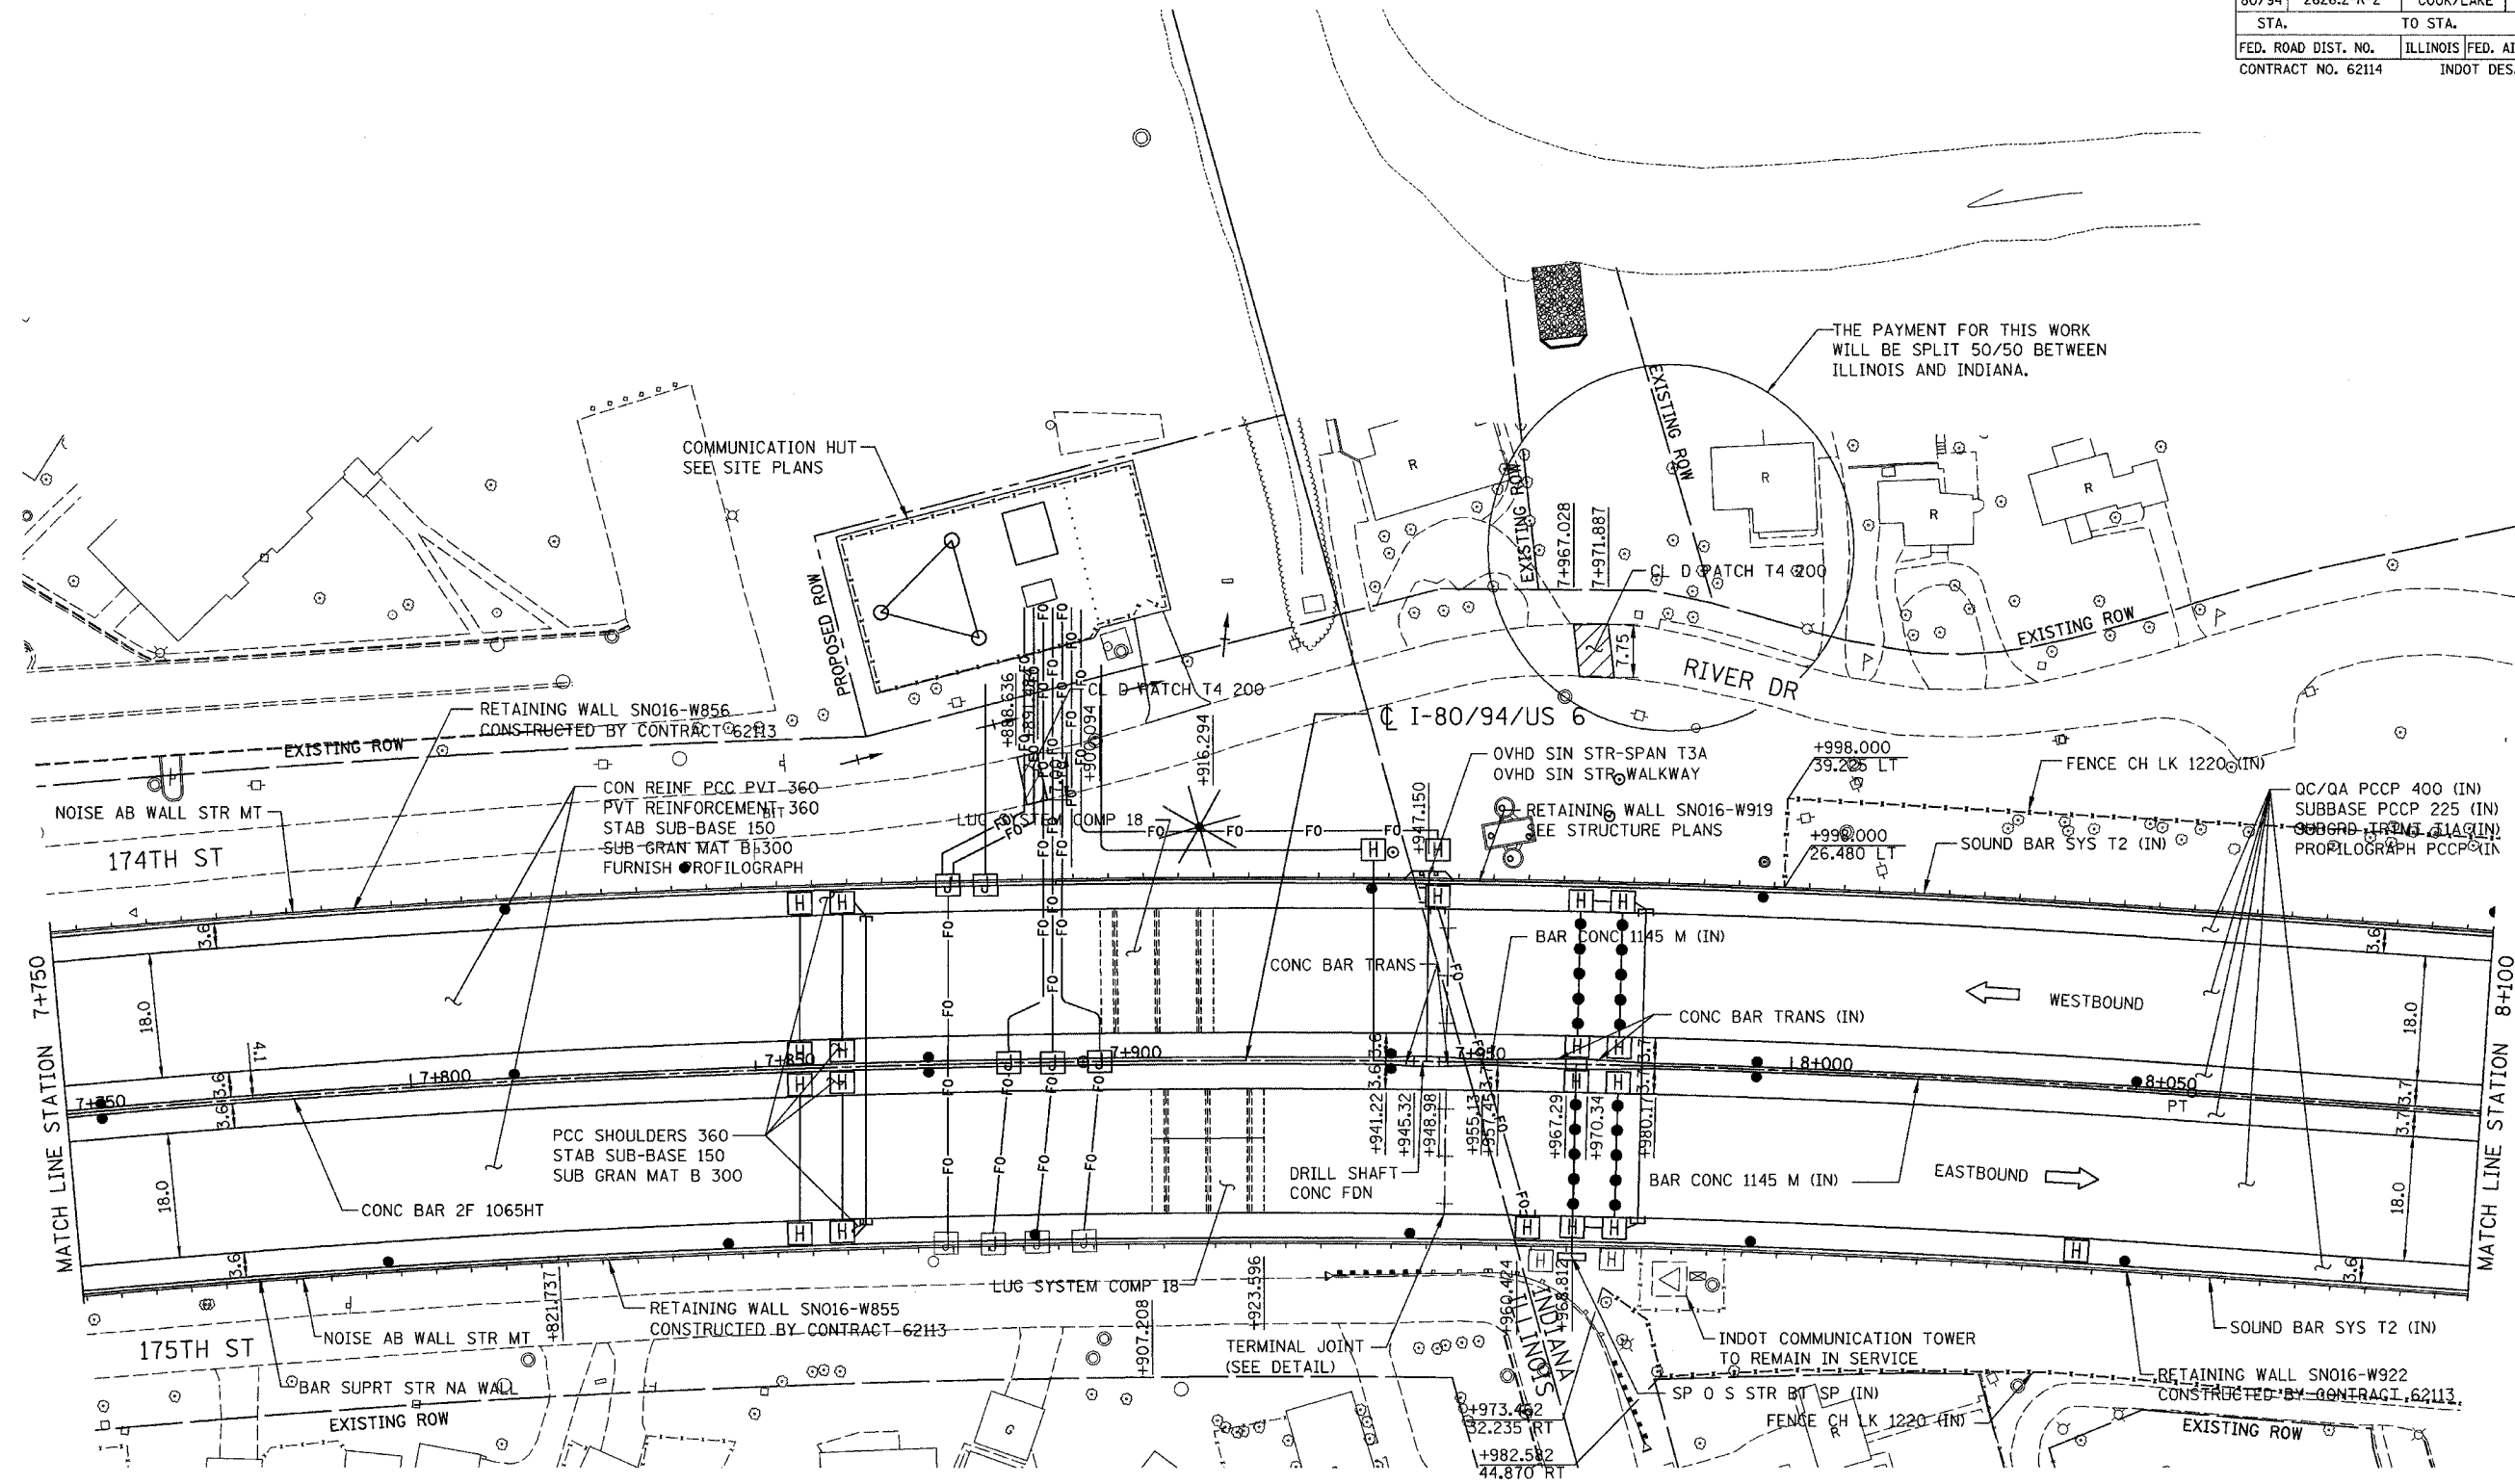


THE PAYMENT FOR THIS WORK WILL BE SPLIT 50/50 BETWEEN ILLINOIS AND INDIANA.

PROPOSED LEGEND:

- NOISE ABATEMENT (SOUND) WALL
- QC/QA PCCP 330
- SUBBASE PCCP 225 (IN)
- SUBGRD TRTMT T1A (IN)

NOTE: MONUMENTS SHALL BE SET IN THE MEDIAN BARRIER AT THE PC AND PT POINTS ALONG THE CENTERLINE OF I-80/94 WITHIN THE INDIANA PROJECT LIMITS. THE WORK SHALL BE PAID FOR AS "MONUMENT, D (INDIANA)" AT A QUANTITY OF 3 EACH.

NOTE: FOR ELECTRICAL WORK IN CONTRACT, SEE "ELECTRICAL INSTALLATION PLANS". FOR ELECTRICAL WORK BY OTHERS, SUBJECT TO CONTRACTOR MODIFICATION, SEE "EXISTING LIGHTING PLAN" SHEETS.

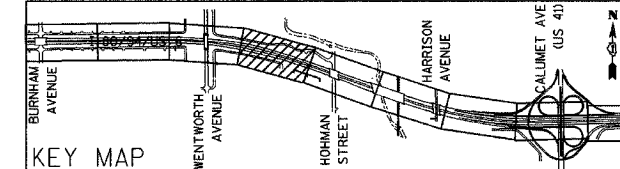

REVISIONS	
NAME	DATE

ILLINOIS DEPARTMENT OF TRANSPORTATION
I-80/94/US 6
KINGERY-BORMAN EXPRESSWAY
BURNHAM ROAD TO US 41
PROPOSED PLAN

STA. 7+750 TO STA. 8+100
 SCALE 1:500 DRAWN BY ACE/CAD
 DATE 07/05 CHECKED BY TAE

