



F.A.I. RTE.	SECTION	COUNTY	TOTAL SHEETS	SHEET NO.
80/94	2003-0891	COOK	1207	455
STA.		TO STA.		
FED. ROAD DIST. NO.		ILLINOIS FED. AID PROJECT		
CONTRACT # 62114				

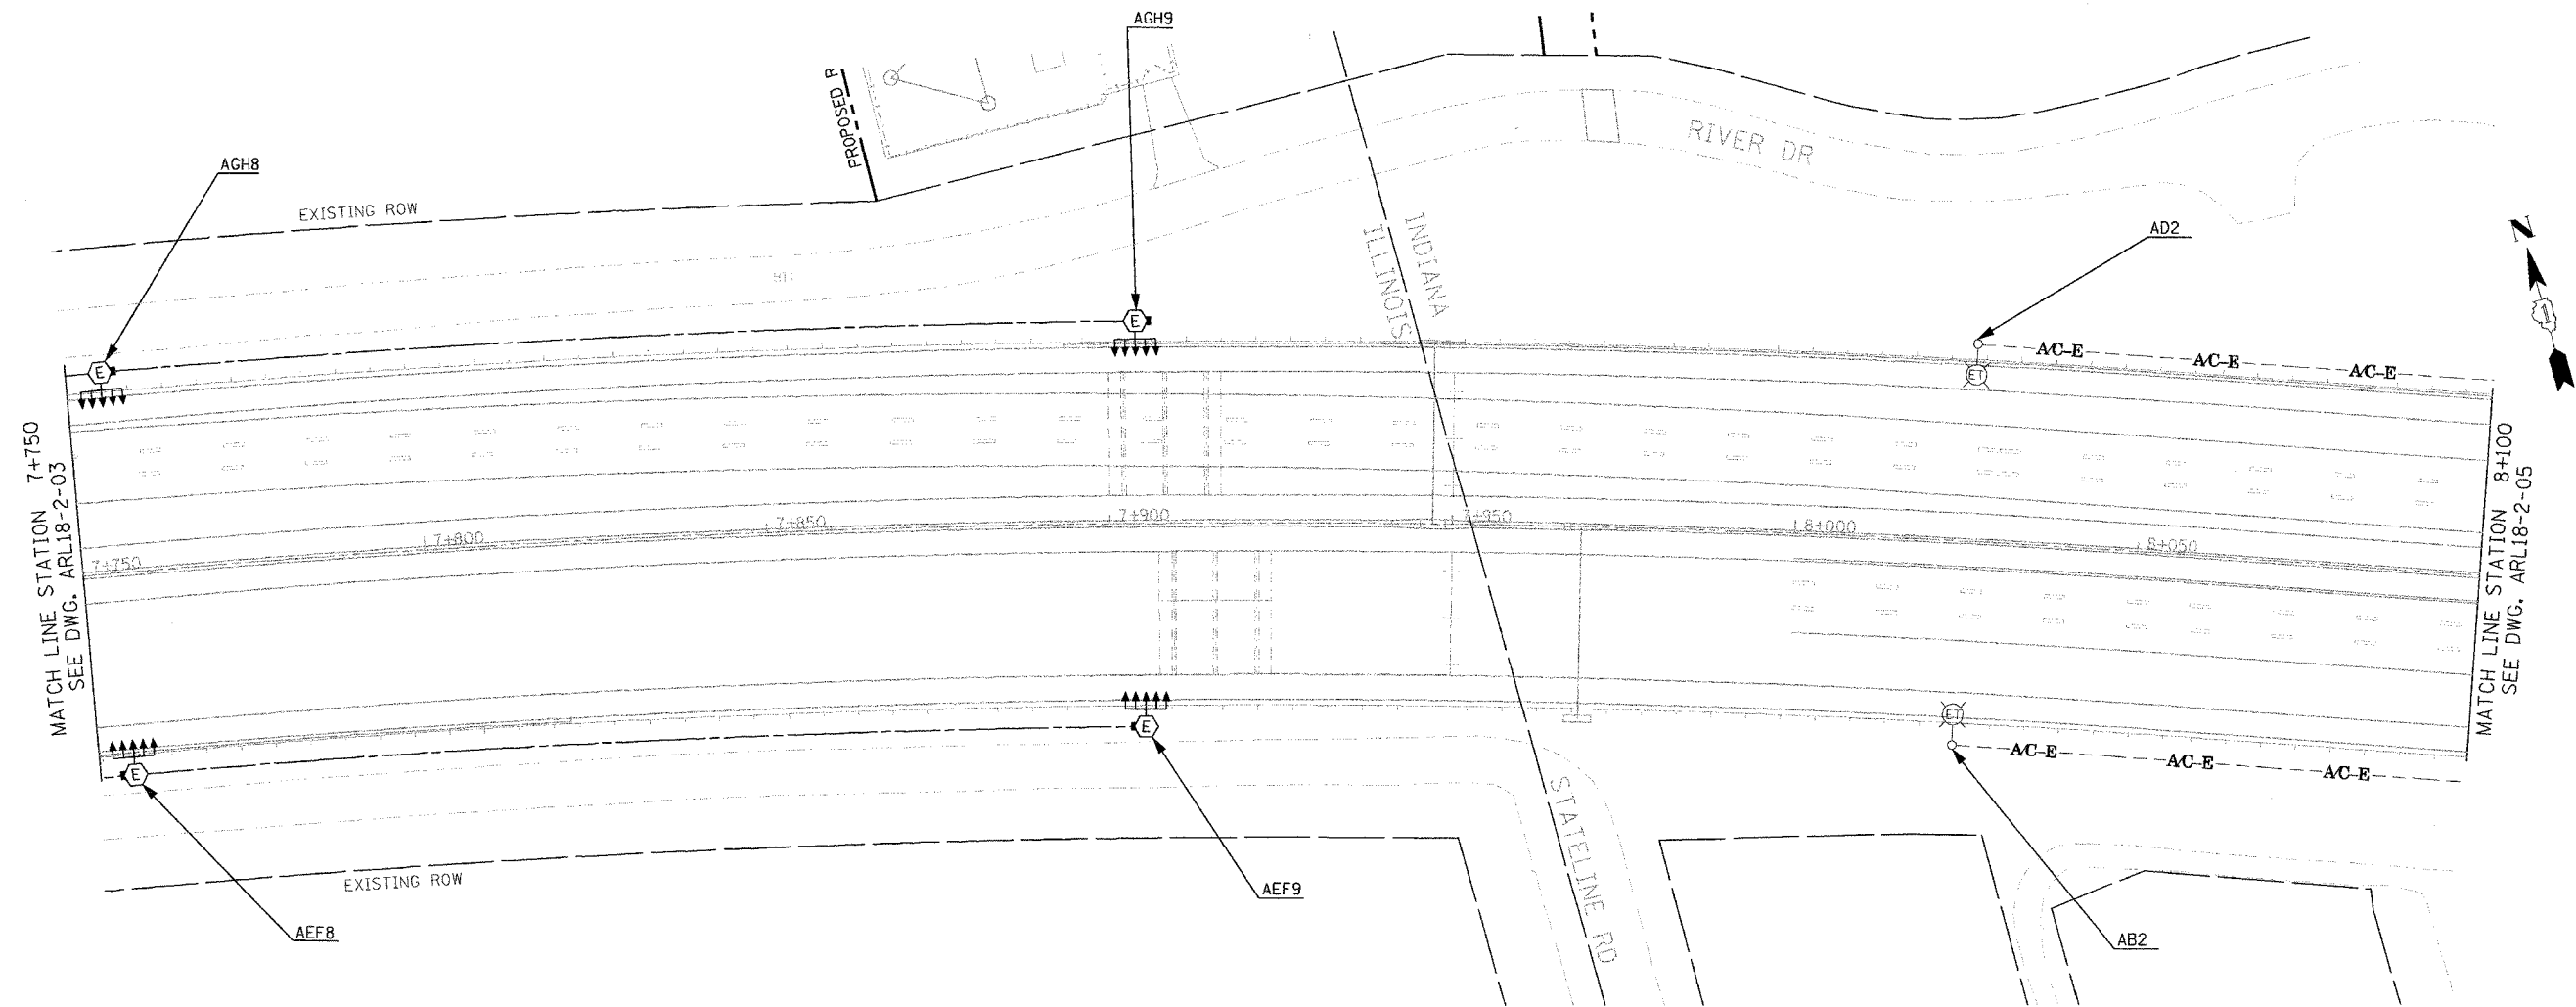

NOTE:
 INSTALLATION OF TEMPORARY LIGHT POLE UNITS,
 AND AERIAL CABLE ON NORTHSIDE IN INDIANA
 SHALL BE COORDINATED WITH CONTRACT 62664.

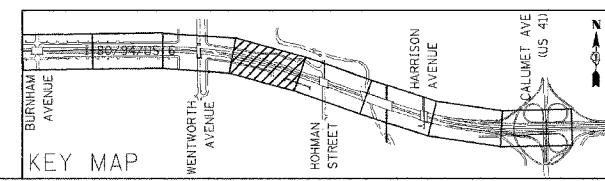

REVISIONS	
NAME	DATE

ARL18-2-04

ILLINOIS DEPARTMENT OF TRANSPORTATION
I-80/94/US 6
KINGERY-BORMAN EXPRESSWAY
BURNHAM ROAD TO US 41
EXISTING LIGHTING PLAN
I-80/94/US-6
STA. 7+750 TO STA. 8+100

SCALE 1:500 DRAWN BY EAO/BC
 DATE 07/18/05 CHECKED BY PKG/BC

GO GANDHI AND ASSOCIATES, INC.
 ENGINEERS AND PLANNERS
 600 N. KENTWORTH HIGHWAY
 SUITE 200
 CHICAGO, ILLINOIS 60642 TEL: 312/774-5200

07/18/05
 07/18/05
 07/18/05