 



F.A.I. RTE.	SECTION	COUNTY	TOTAL SHEETS	SHEET NO.
80/94	2003-089I	COOK	1207	459
STA.	TO STA.			
FED. ROAD DIST. NO.	ILLINOIS	FED. AID PROJECT	CONTRACT # 62114	

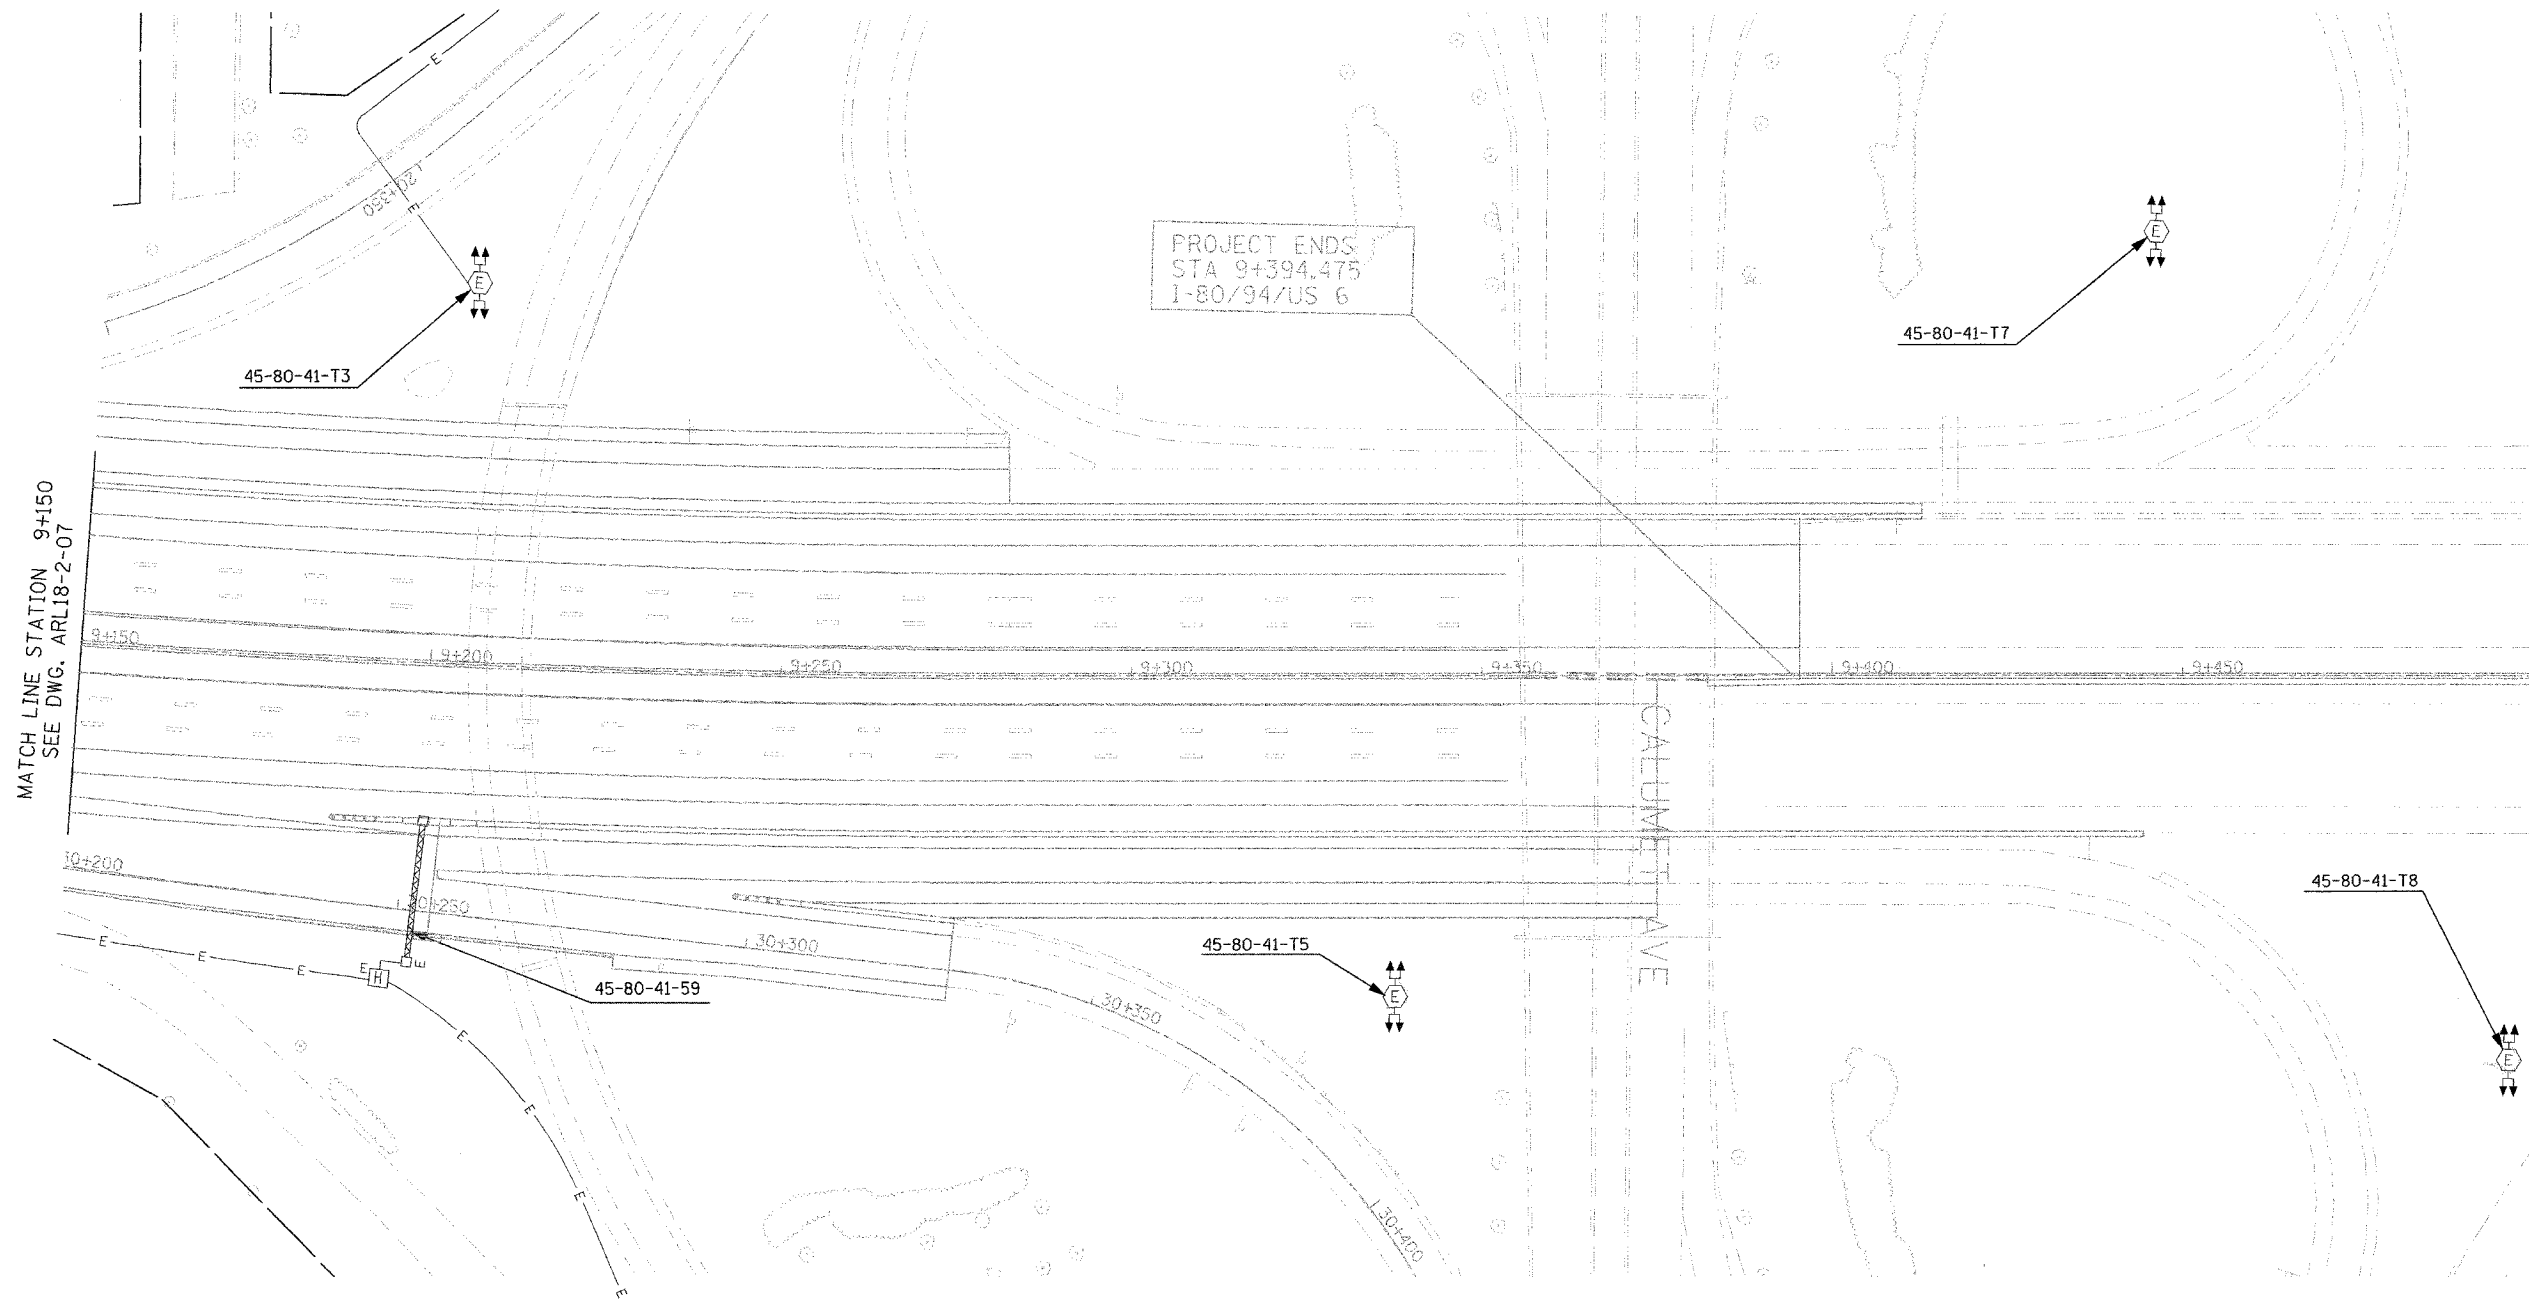

MATCH LINE STATION 9+150
SEE DWG. ARL18-2-07

PROJECT ENDS
STA 9+394.475
I-80/94/US 6


ARL18- 2-08

ILLINOIS DEPARTMENT OF TRANSPORTATION
I-80/94/US 6
KINGERY-BORMAN EXPRESSWAY
BURNHAM ROAD TO US 41
EXISTING LIGHTING PLAN
I-80 /94 /US-6
STA. 9 +150 TO STA. 9 +394.475

SCALE 1:500
DATE 07/18/05

DRAWN BY EA0/BC
CHECKED BY PKG/BC

GANDHI AND ASSOCIATES, INC.
ENGINEERS AND PLANNERS
800 N. MICHIGAN STREET, SUITE 200
CHICAGO, ILLINOIS 60610 TEL: (773) 774-5300

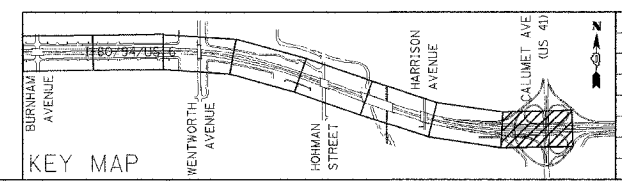

REVISIONS	
NAME	DATE

#FILES
#DATE
#TIME