



F.A.I. RTE.	SECTION	COUNTY	TOTAL SHEETS	SHEET NO.
80/94	2003-0891	COOK	1207	460
STA.	TO STA.			
FED. ROAD DIST. NO.	ILLINOIS	FED. AID PROJECT		
CONTRACT # 62114				

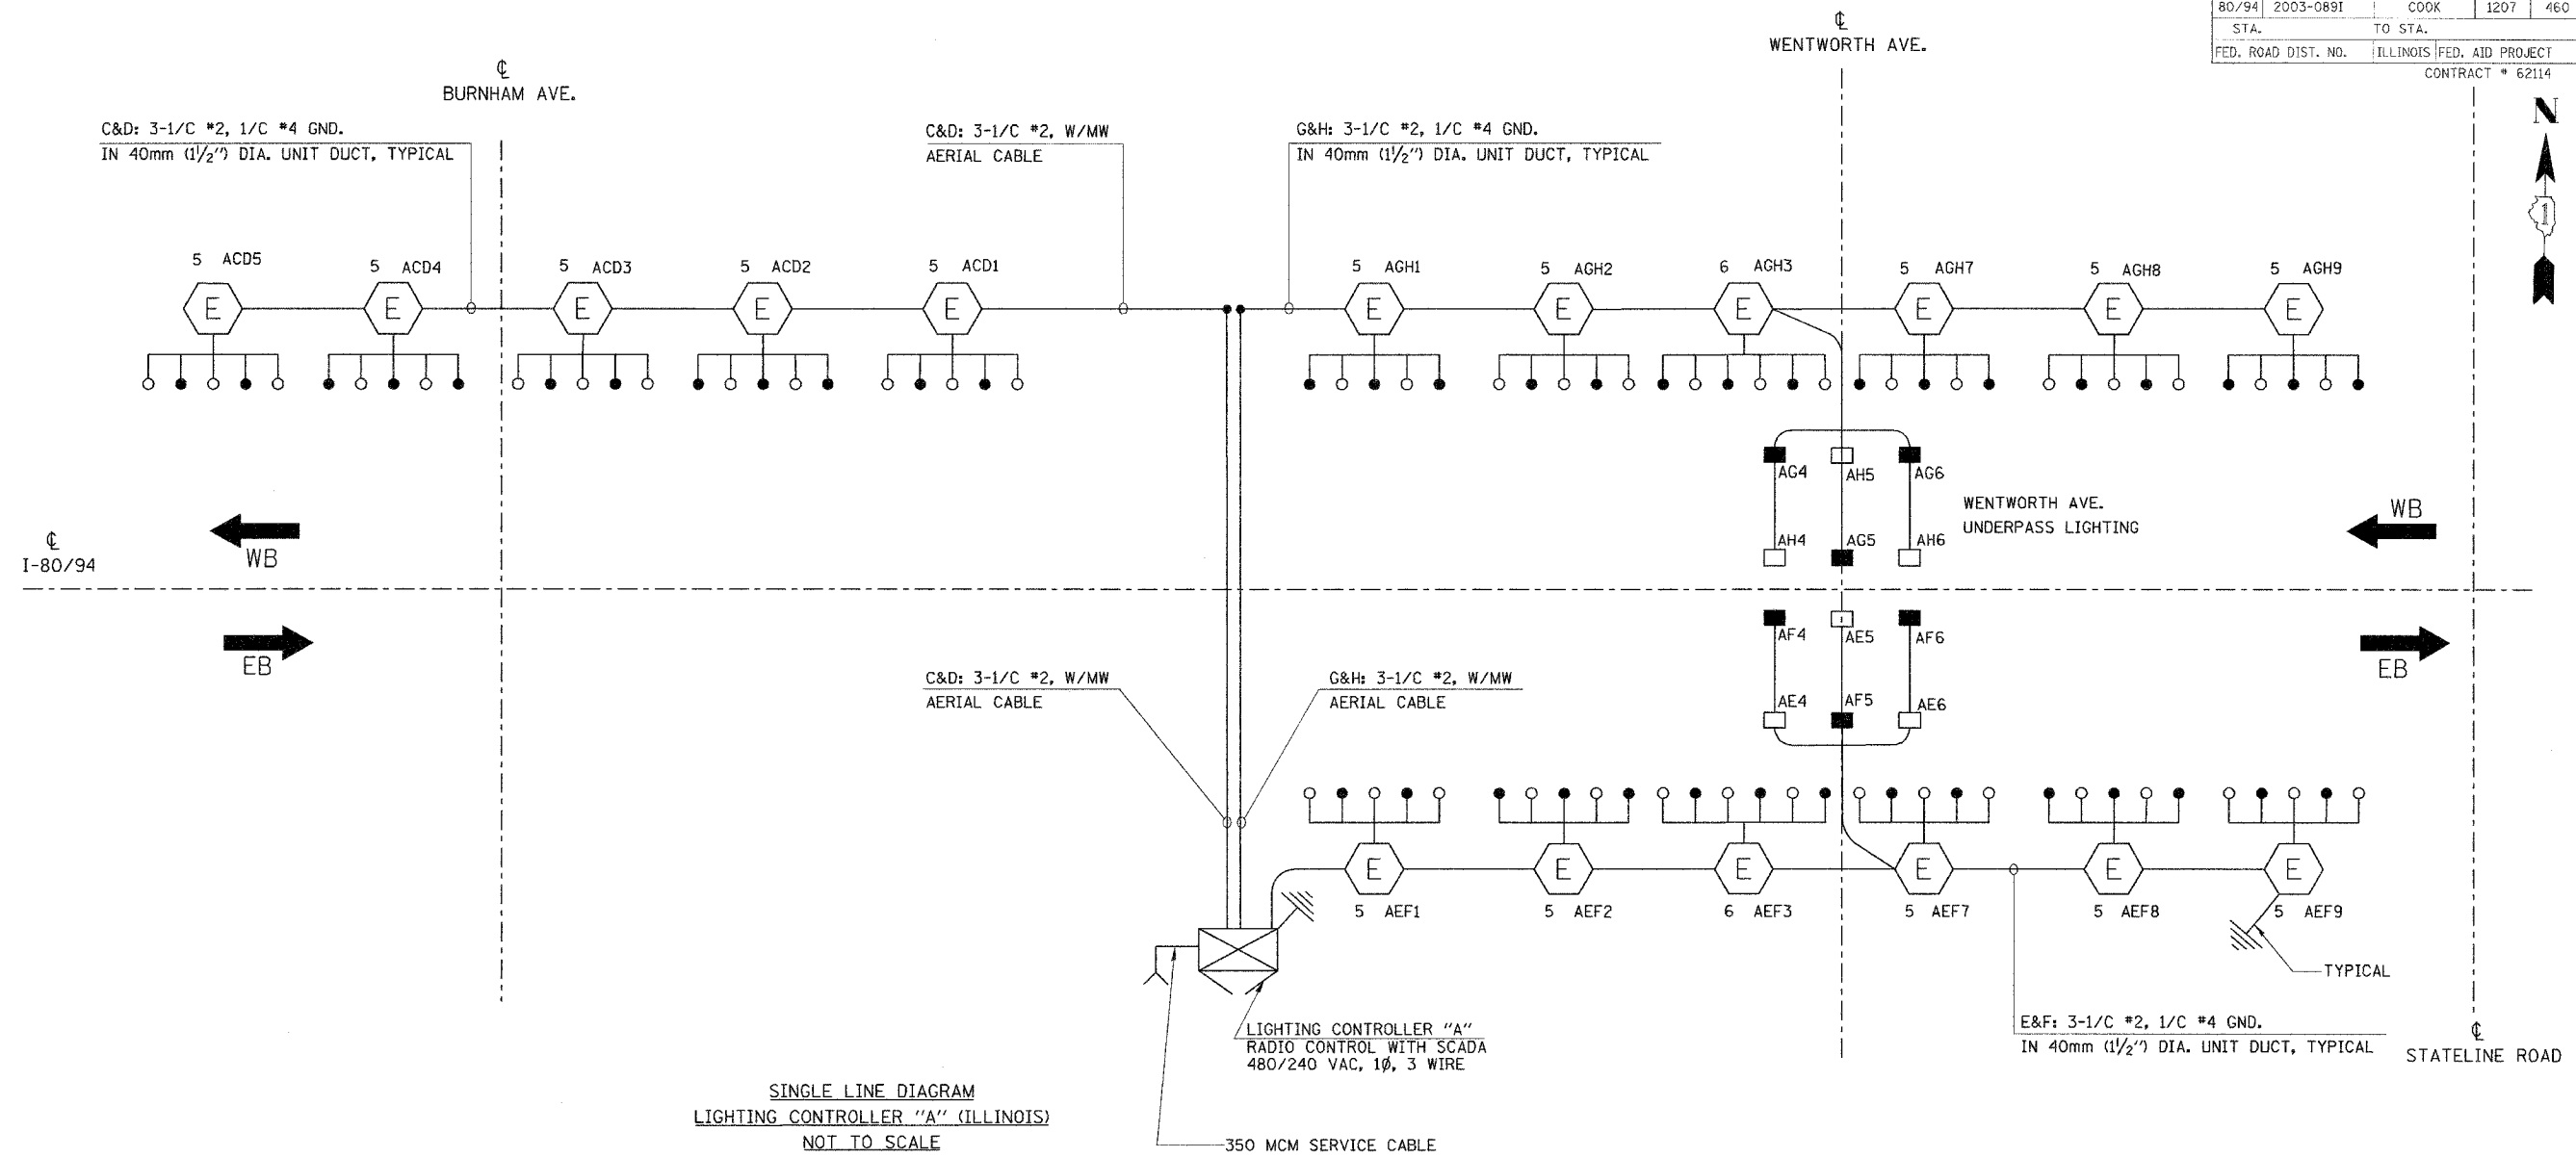

FOR INFORMATION ONLY

LEGEND

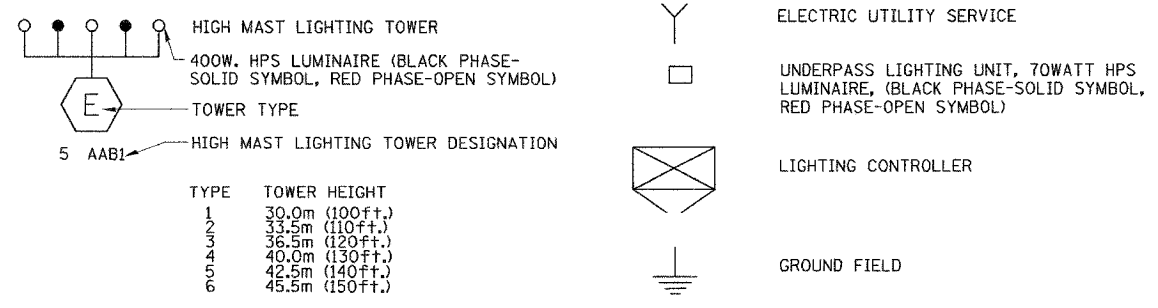

LOAD TABLE LIGHTING CONTROLLER "A" (ILLINOIS)					
CIRCUIT	RED PHASE		CIRCUIT	BLACK PHASE	
	AMPS	WATTS		AMPS	WATTS
C	26.0	6240	D	24.0	5760
E	33.2	7968	F	31.2	7488
G	31.2	7488	H	33.2	7968
TOTAL	90.4	21696	TOTAL	88.4	21216

AWE18-2-01

ILLINOIS DEPARTMENT OF TRANSPORTATION
I-80/94/US 6
KINGERY-BORMAN EXPRESSWAY
BURNHAM ROAD TO US 41
SINGLE LINE DIAGRAM
LIGHTING CONTROLLER "A"
(ILLINOIS)
EXISTING LIGHTING

REVISIONS	
NAME	DATE

SCALE NONE DRAWN BY EA0/BC
DATE 07/18/05 CHECKED BY PKG/BC

GO
GANZHE AND ASSOCIATES, INC.
ENGINEERS AND PLANNERS
200 N. WESTWIND BOULEVARD
SUITE 200
CHICAGO, ILLINOIS 60608 TEL: 312/374-5900

FILED
NOTED
DATE