



 


F.A.I. RTE.	SECTION	COUNTY	TOTAL SHEETS	SHEET NO.
80/94	2003-089I	COOK	1207	461
STA.	TO STA.			
FED. ROAD DIST. NO.	ILLINOIS	FED. AID PROJECT	CONTRACT # 62114	

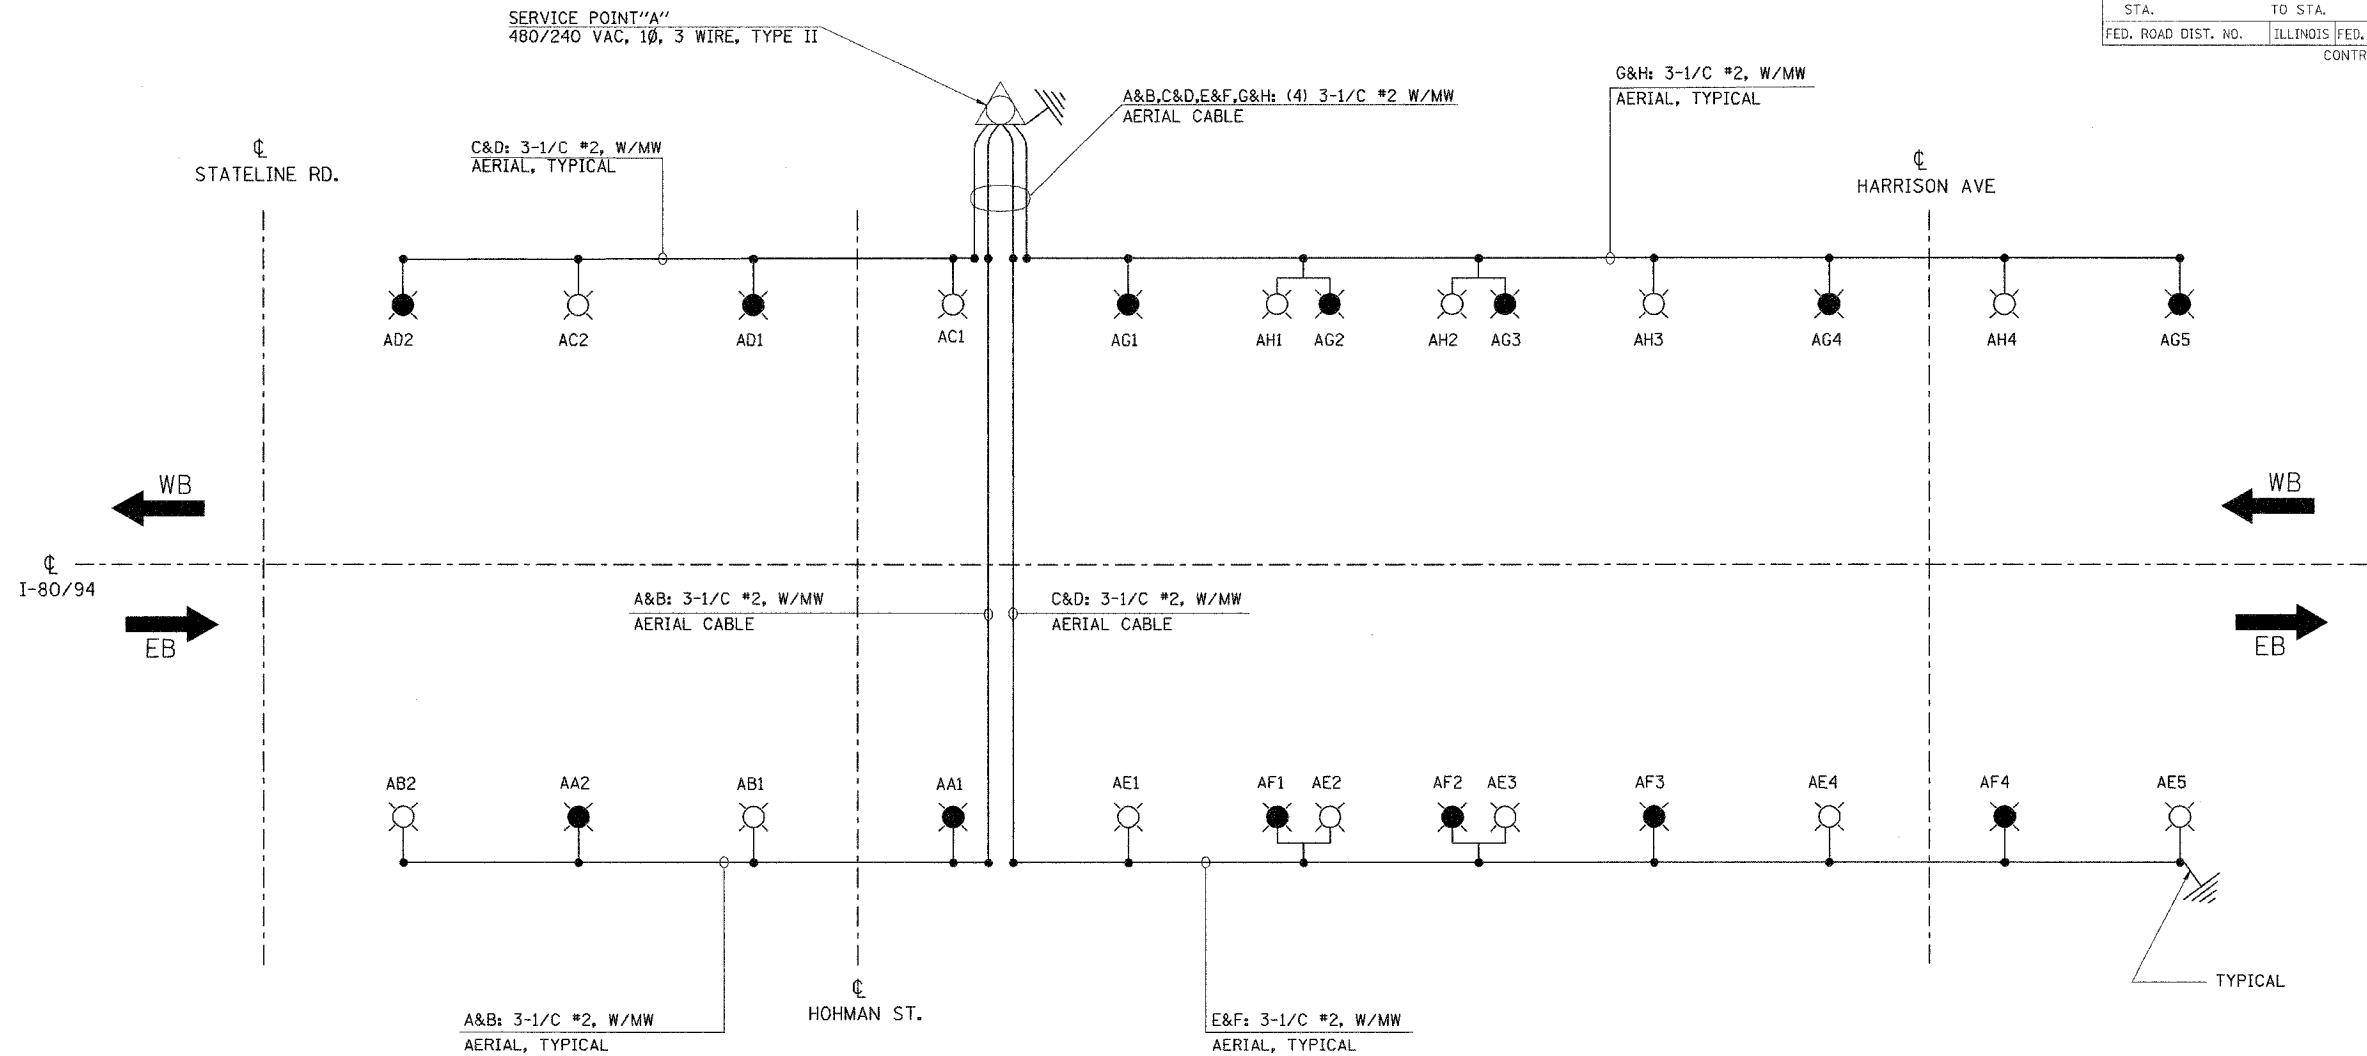

SINGLE LINE DIAGRAM  
SERVICE POINT "A" (INDIANA)  
NOT TO SCALE

FOR INFORMATION ONLY

LEGEND

-  SERVICE POINT, TYPE II
-  GROUND FIELD
-  TEMPORARY LIGHTING UNIT, 750WATT HPS LUMINAIRE, (BLACK PHASE-SOLID SYMBOL, RED PHASE-OPEN SYMBOL)
-  TEMPORARY LIGHTING UNIT, 750WATT HPS, WITH TWIN ARMS (BLACK PHASE-SOLID SYMBOL, RED PHASE-OPEN SYMBOL)


LOAD TABLE SERVICE POINT "A" (INDIANA)					
CIRCUIT	BLACK PHASE		CIRCUIT	RED PHASE	
	AMPS	WATTS		AMPS	WATTS
A	7.0	1680	B	7.0	1680
D	7.0	1680	C	7.0	1680
F	14.0	3360	E	17.5	4200
G	17.5	4200	H	14.0	3360
<b>TOTAL</b>	<b>45.5</b>	<b>10920</b>	<b>TOTAL</b>	<b>45.5</b>	<b>10920</b>

REVISIONS	
NAME	DATE

AWE18- 2-03

**ILLINOIS DEPARTMENT OF TRANSPORTATION**  
I-80/94/US 6  
KINGERY-BORMAN EXPRESSWAY  
BURNHAM ROAD TO US 41  
SINGLE LINE DIAGRAM  
SERVICE POINT "A" (INDIANA)  
EXISTING LIGHTING

SCALE NONE      DRAWN BY EAO/BC  
DATE 07/18/05      CHECKED BY PKG/BC

 GANDHI AND ASSOCIATES, INC.  
ENGINEERS AND PLANNERS  
5000 N. BURNHAM ST. SUITE 200  
CHICAGO, ILLINOIS 60630 TEL: 4737374-5810

FILED  
DATE  
BY