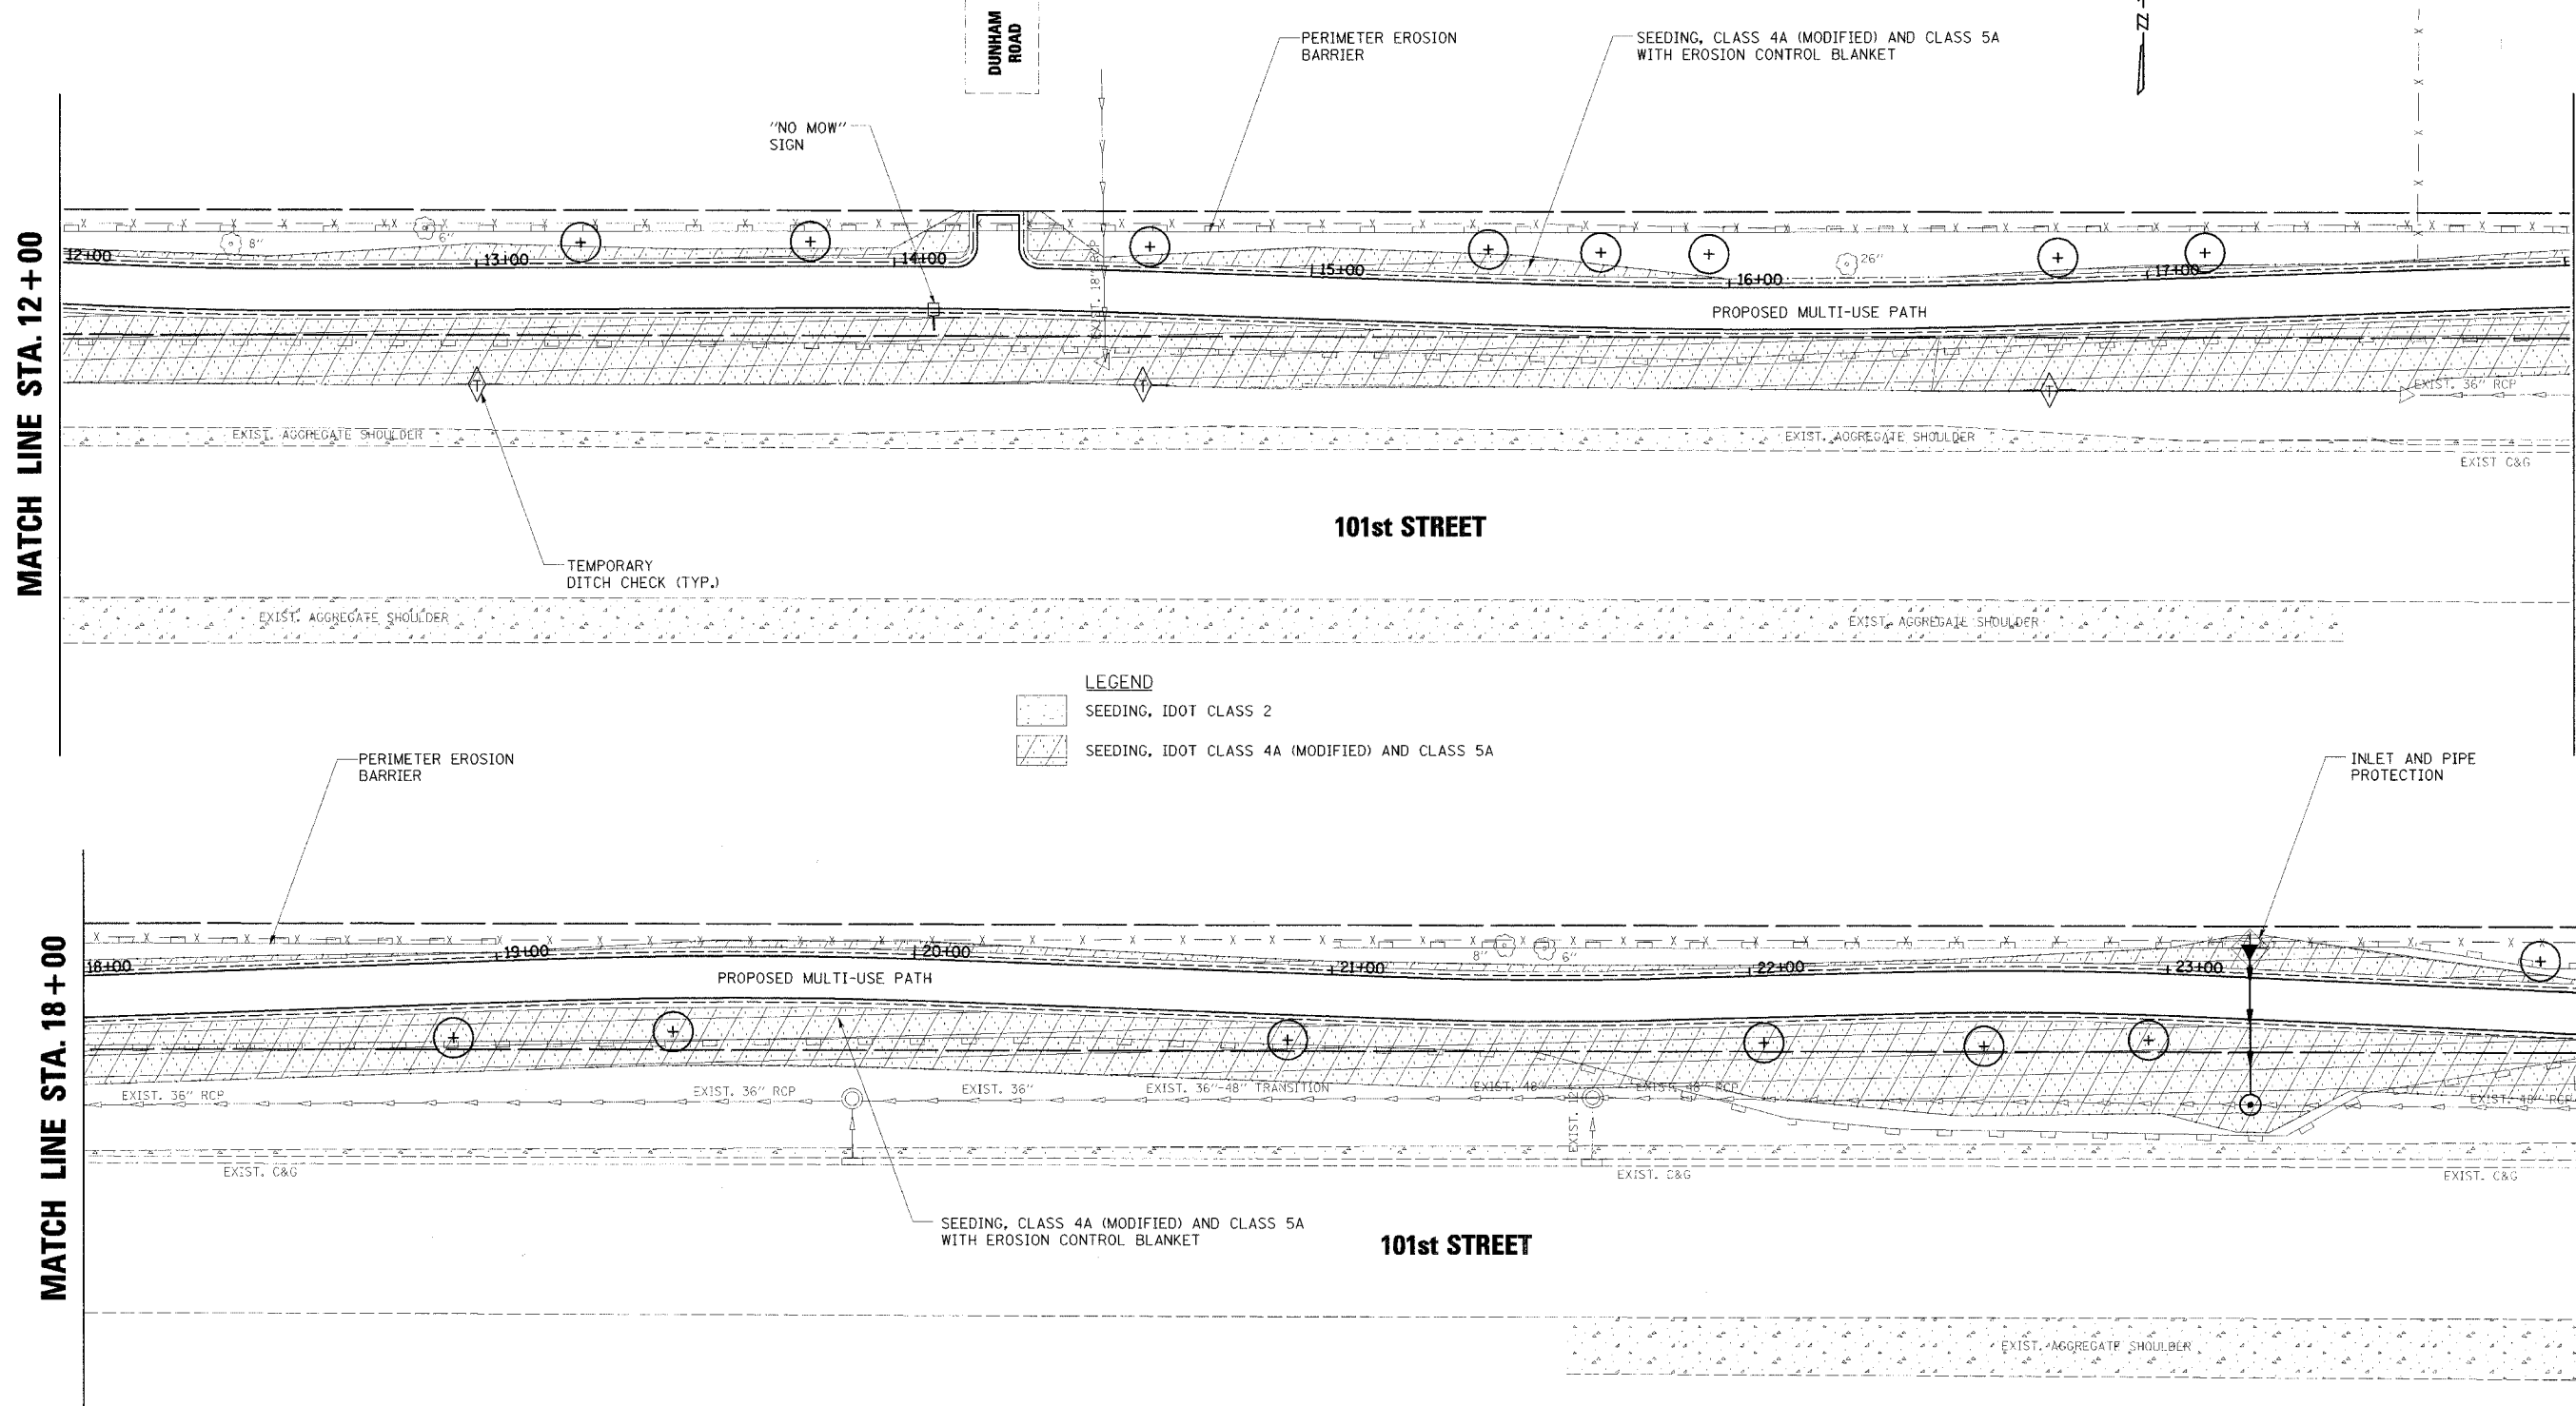

 


COUNTY HIGHWAY	FISCAL YEAR	TOTAL SHEETS	SHEET NO.
	2005	30	13
SEC 03-00001-06-BT		DUPAGE COUNTY	

CONTRACT NO.: 83805



LEGEND
 SEEDING, IDOT CLASS 2
 SEEDING, IDOT CLASS 4A (MODIFIED) AND CLASS 5A

8/10/2005 12:24:45 PM K:\195000\cadd\06\195000.dwg

NO.	DATE	BY	REVISION	NO.	DATE	BY	REVISION

SCALE 1" = 20'
 DRAWN BY JMC DATE
 CHECKED BY MRH DATE
 APPROVED BY DWB DATE



R/N GROUP, INC.
 CONSULTING ENGINEERS

PROJECT
**Southern DuPage County Regional Trail
 101st Street Connector - Waterfall Glen Spur**

TITLE
**LANDSCAPING AND
 EROSION CONTROL PLAN**

DATE: JUNE 9, 2005
 PROJECT NO.: II-1900-01
 SHEET: