
 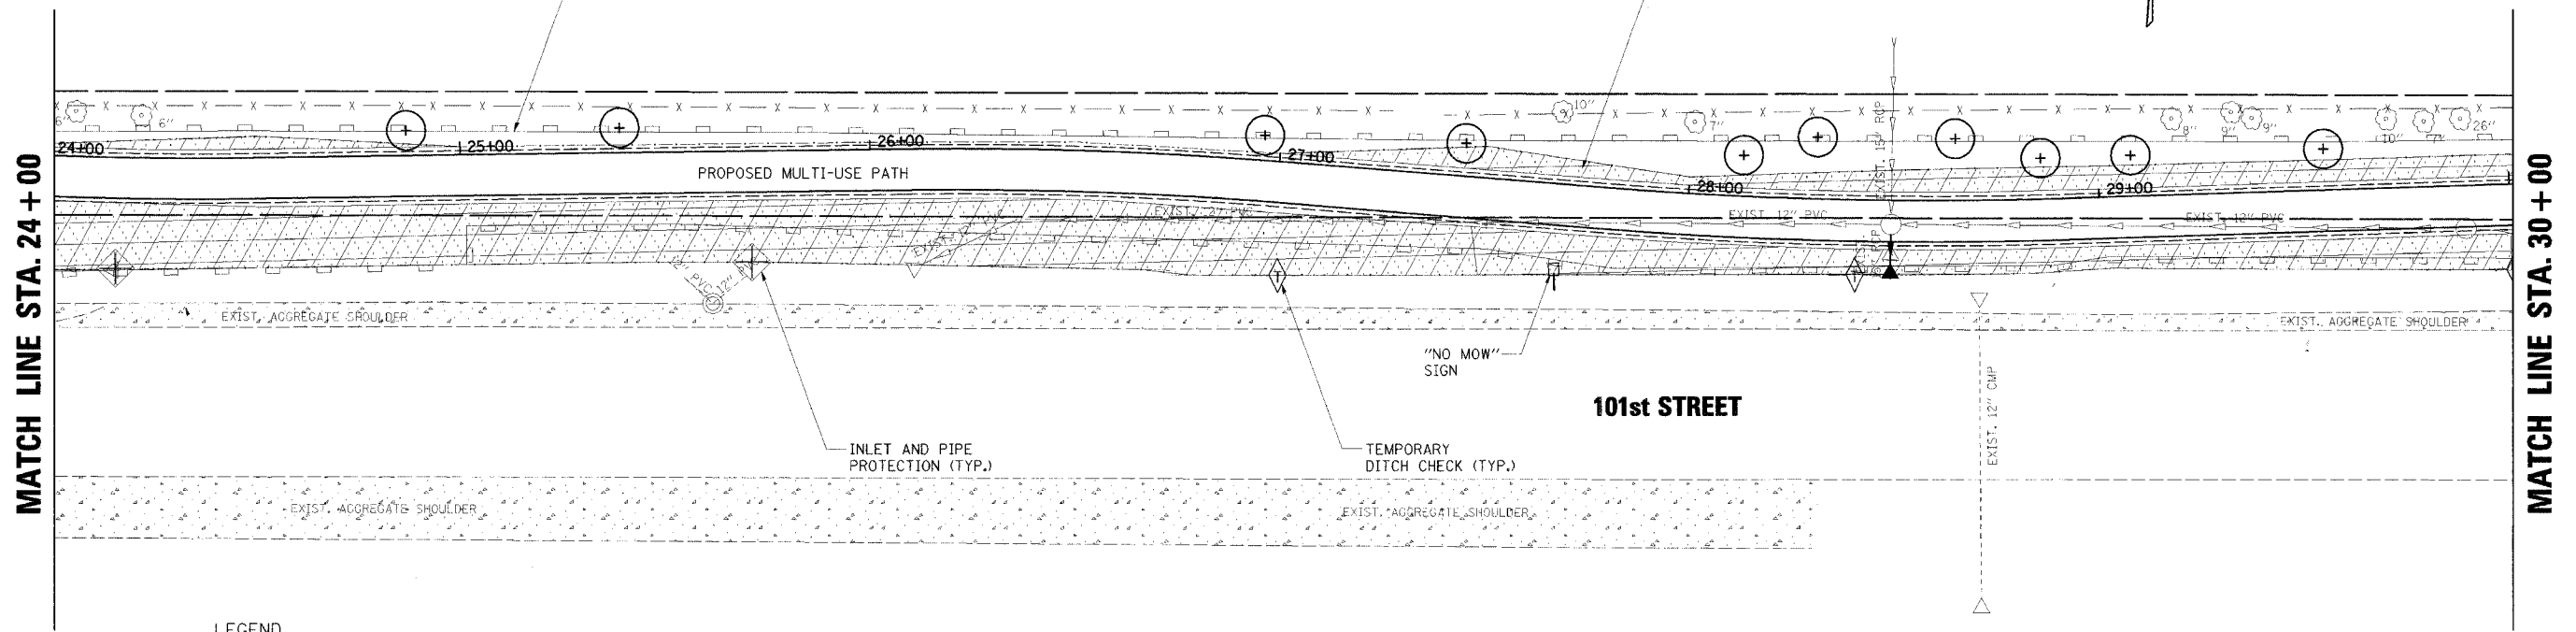



COUNTY HIGHWAY	FISCAL YEAR	TOTAL SHEETS	SHEET NO.
	2005	30	14
SEC 03-00001-06-BT		DUPAGE COUNTY	

CONTRACT NO.: 83805



LEGEND

	SEEDING, IDOT CLASS 2
	SEEDING, IDOT CLASS 4A (MODIFIED) AND CLASS 5A

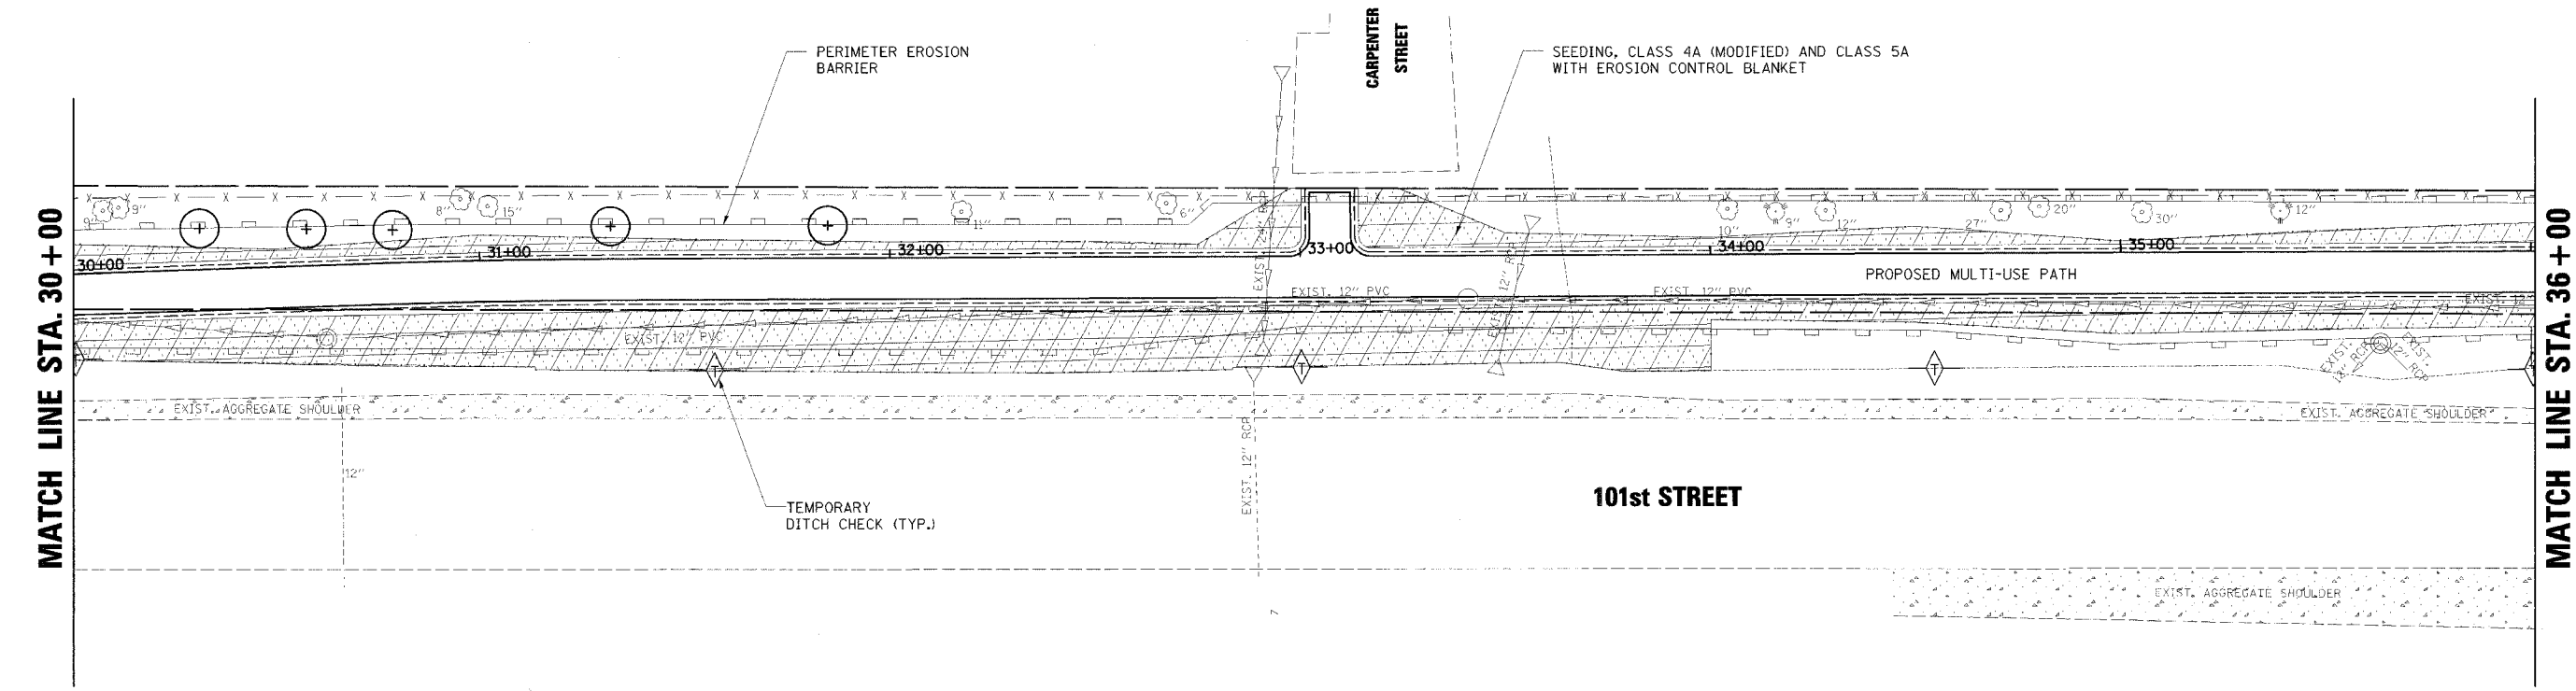

8/10/2005 12:24:46 PM k:\190000\cadd\05\gn\1901_ER03.dgn

NO.	DATE	BY	REVISION	NO.	DATE	BY	REVISION

SCALE 1" = 20'

DRAWN BY JMC DATE

CHECKED BY MRH DATE

APPROVED BY DWB DATE



R/N GROUP, INC.
CONSULTING ENGINEERS

PROJECT
**Southern DuPage County Regional Trail
101st Street Connector – Waterfall Glen Spur**

TITLE
**LANDSCAPING AND
EROSION CONTROL PLAN**

DATE: JUNE 9, 2005
PROJECT No.: II-1900-01
SHEET: