
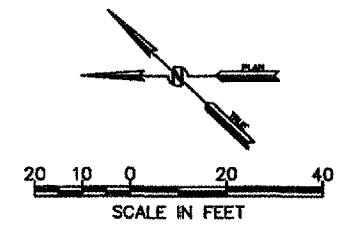
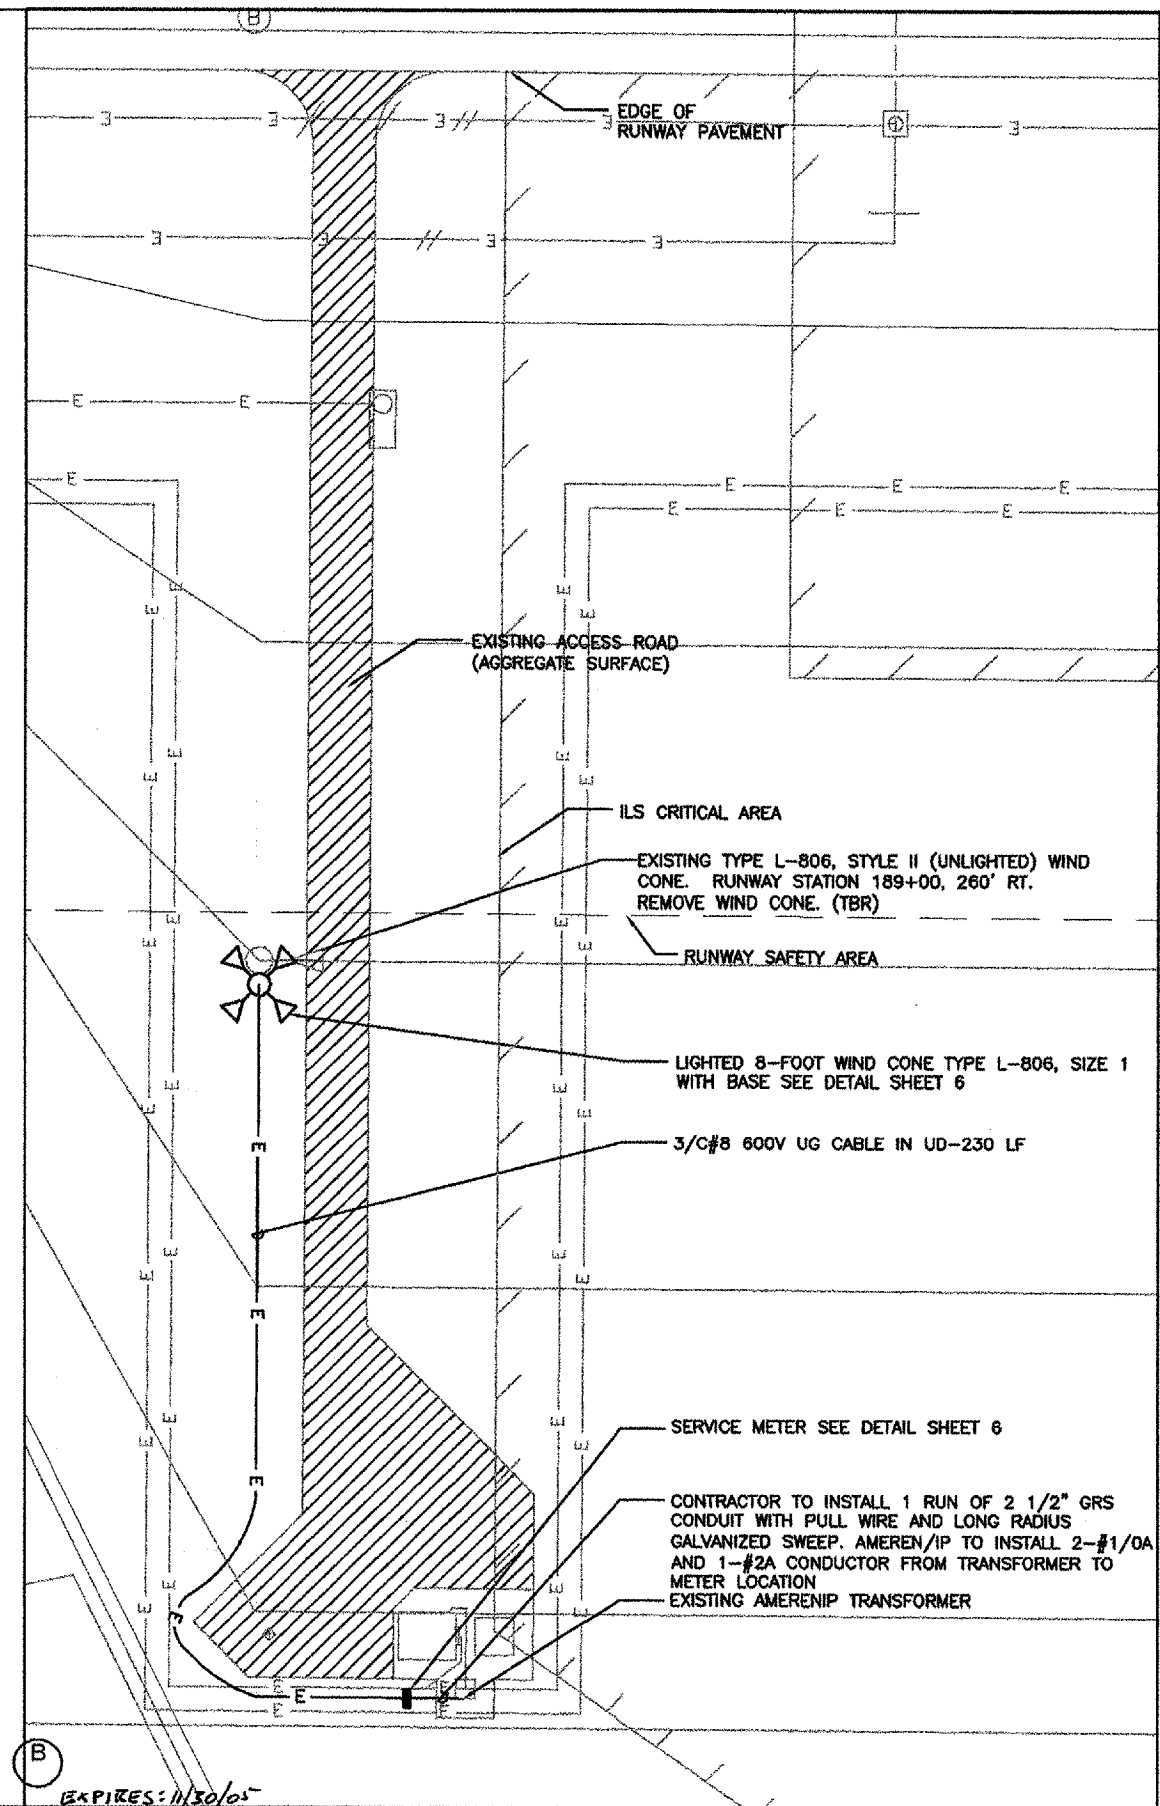


**NOTES:**

1. CONTRACTOR TO NOTIFY FAA (RUDY BRODSKY, 618.256.1800) AT LEAST PRIOR TO ANY TRENCHING ACTIVITIES.
2. INSTALL EROSION CONTROL MEASURES AS REQUIRED OR AS DIRECTED BY R.E. COST OF ANY EROSION CONTROL SHALL BE INCIDENTAL TO PROJECT.

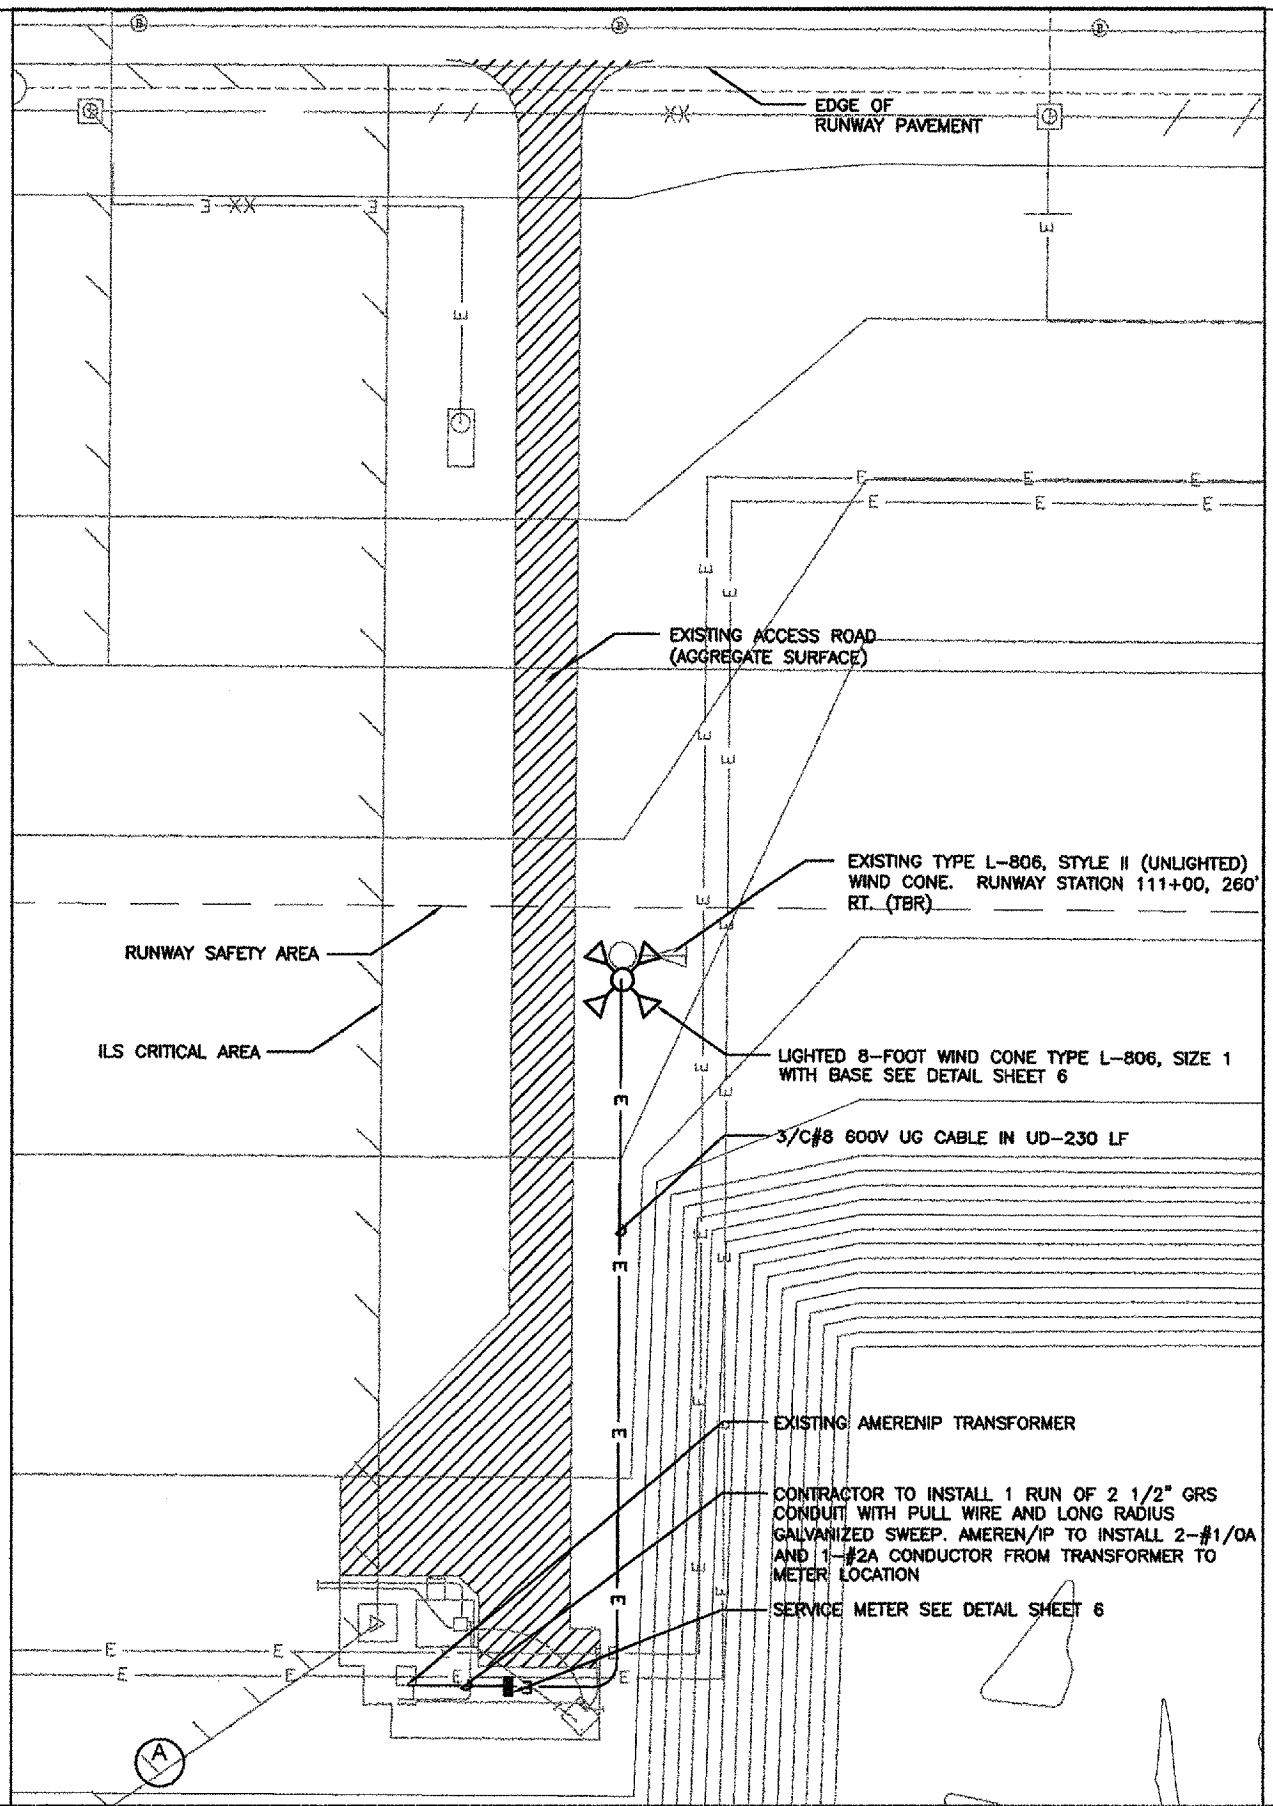

EXPIRES: 11/30/05

REV.	DATE	BY	APPR.	DESCRIPTION	PLOT FILE	REV.	DATE	BY	APPR.	DESCRIPTION	PLOT FILE

DESIGNED BY: RWH  
 DRAWN BY: RWH  
 CHECKED BY: DJT  
 DATE: 9/23/05

**Daniel J. Trapp**  
 LICENSED PROFESSIONAL ENGINEER  
 OF ILLINOIS  
 062-054591

**MidAmerica**  
 ST. LOUIS AIRPORT

**EarthTech**  
 A Tyco International Ltd. Company

LIGHT SUPPLEMENTAL WIND CONES

1075 Eastgate Drive  
 O'Fallon, Illinois 62269  
 PH 618-624-2628  
 FAX 618-624-2730



**PARTIAL SITE PLAN**

DWG. FILE NAME  
87727-E-05

SHEET NO.  
5

L:\work\87727\cadd\100\87727-E-05.dwg, 9/23/2005 12:20:48 PM