



TYPICAL SPLICE DETAIL

N.T.S.

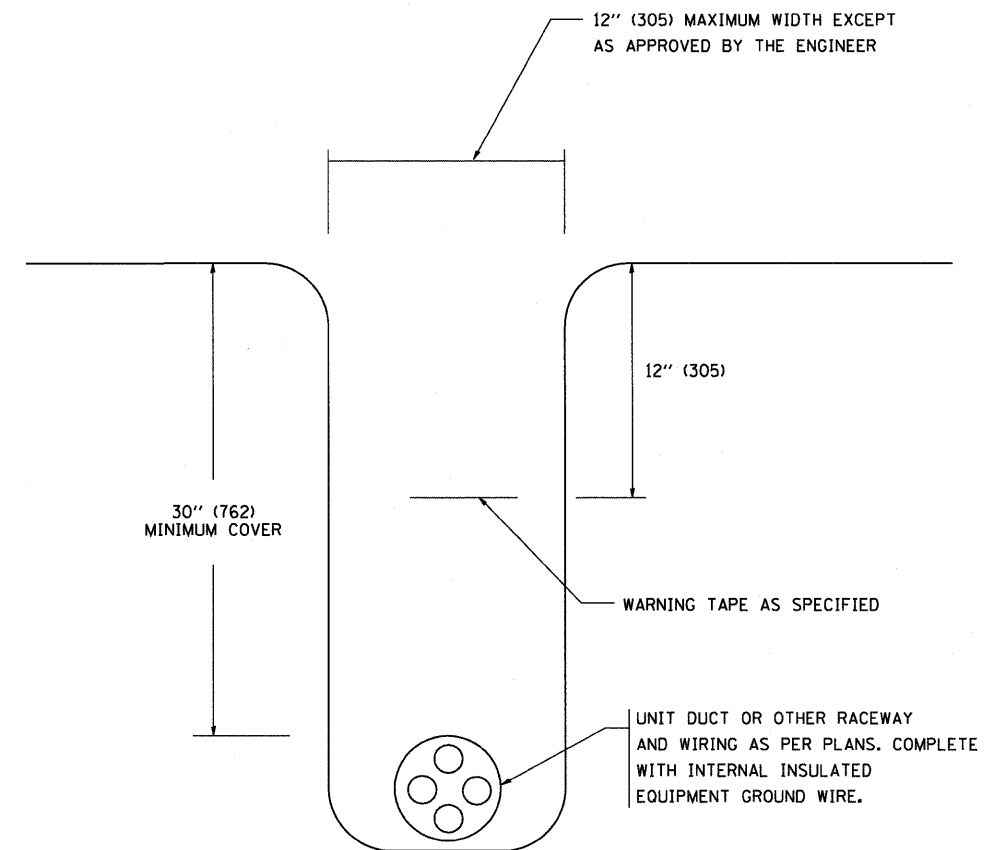

TYPICAL WIRING IN TRENCH DETAIL

N.T.S.

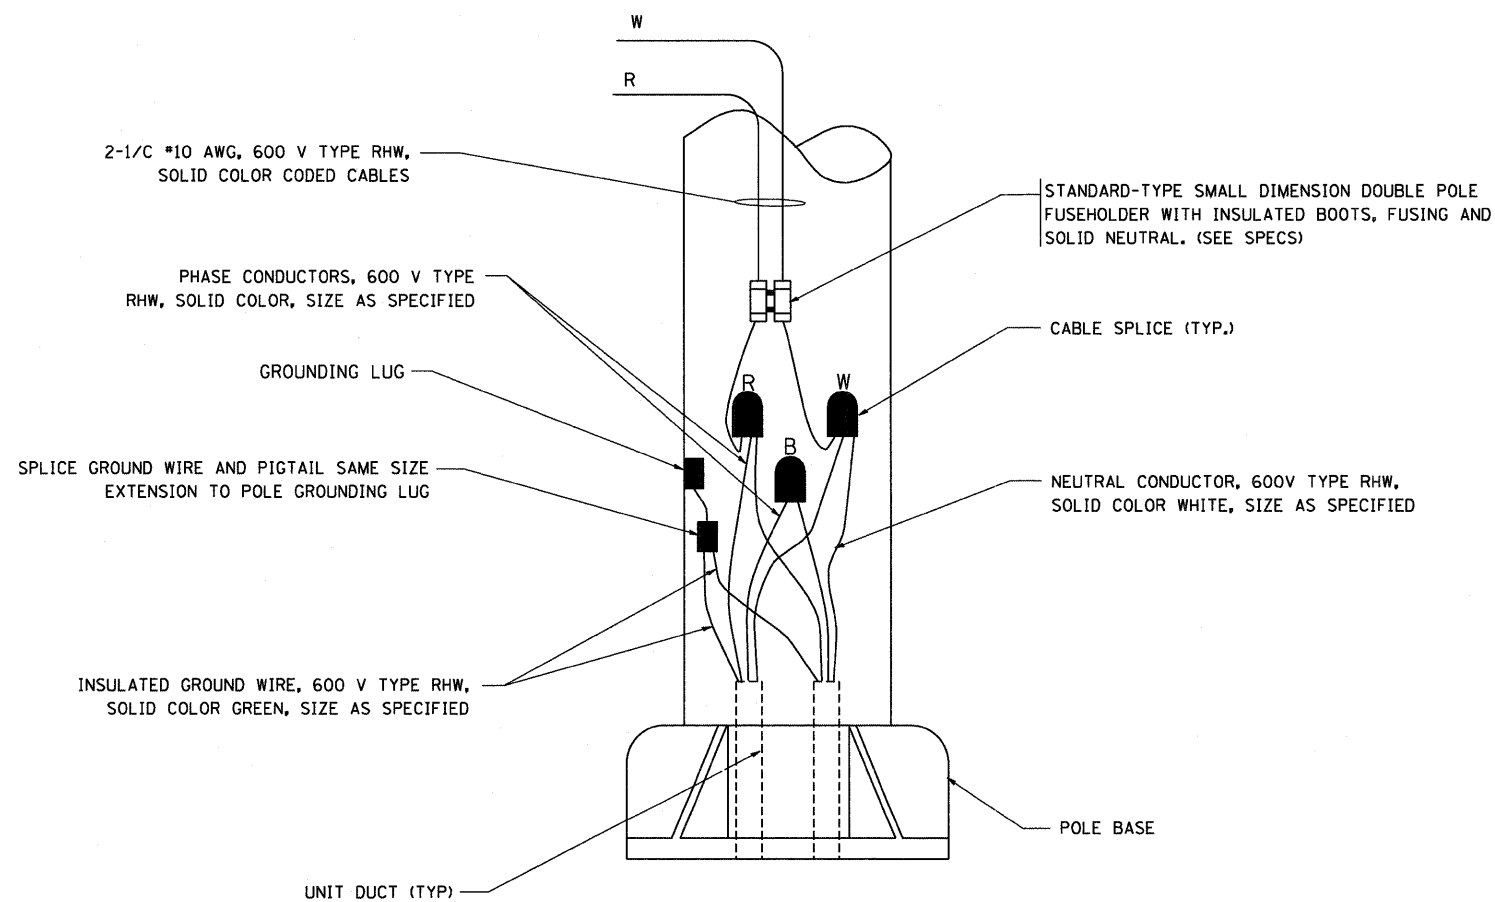

POLE WIRING DETAIL

N.T.S.

FILE NAME = W:\distetd\22x34\be782.dgn

USER NAME = gegl10n0bt  
 DESIGNED -  
 DRAWN -  
 PLOT SCALE = 50,000' / IN.  
 CHECKED -  
 PLOT DATE = 1/4/2008  
 DATE -

REVISED - 08-08-03  
 REVISED -  
 REVISED -  
 REVISED -

STATE OF ILLINOIS  
 DEPARTMENT OF TRANSPORTATION

MISC. ELECTRICAL DETAILS  
 SHEET A

SCALE: NONE SHEET NO. 1 OF 1 SHEETS STA. TO STA.

F.A.P. RTE.	SECTION	COUNTY	TOTAL SHEETS	SHEET NO.
573	61HB-1-R	KANE	110	102
BE-702			CONTRACT NO. 60K76	
FED. ROAD DIST. NO. 1 ILLINOIS FED. AID PROJECT				