


REMOVAL PLAN

REMOVING CATCH BASINS; 1 EA,
TY 1 SEWER REMOVAL, 5 LF,
AND
EXPLORATION TRENCH 48" DEPTH

REMOVING CATCH BASINS; 1 EA,
TY 1 SEWER REMOVAL, 5 LF,
AND
EXPLORATION TRENCH 48" DEPTH

FIRE HYDRANTS TO BE RELOCATED; 1 EA

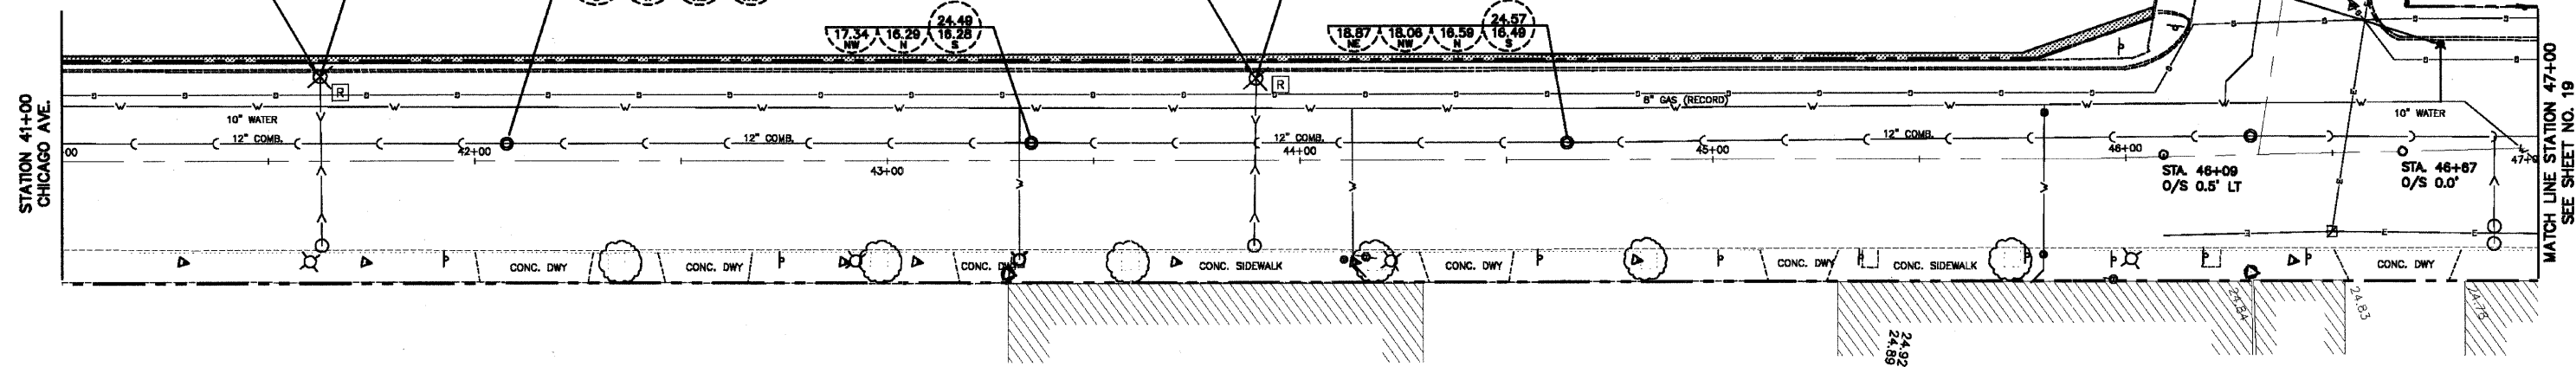



PROPOSED PLAN

CATCH BASINS, TY A, 4'-DIA,
TY 1 FR, OPEN LID, SPECIAL
RIM: 23.71
INV: 17.35
AND
STORM SEWER, DUCTILE
IRON PIPE 8";5 LF

CATCH BASINS, TY A, 4'-DIA,
TY 1 FR, OPEN LID, SPECIAL
RIM: 23.78
INV: 20.30
AND
STORM SEWER, DUCTILE
IRON PIPE 8";5 LF

FIRE HYDRANTS TO BE RELOCATED; 1 EA

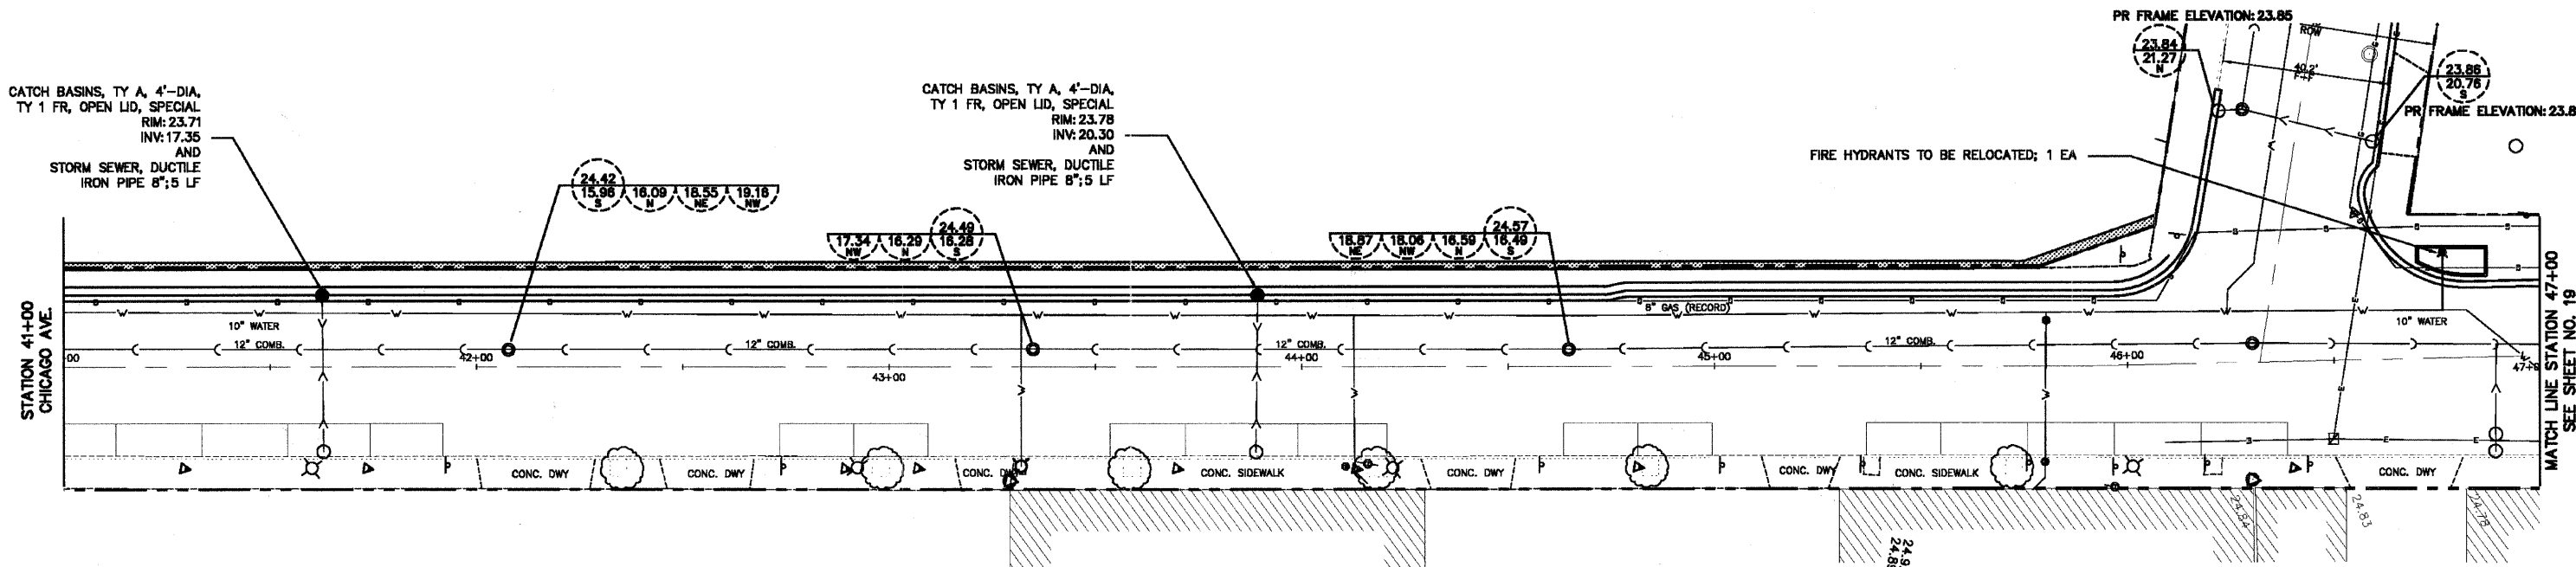

PLANS PREPARED BY:

 CITY OF EVANSTON
 PUBLIC WORKS DEPARTMENT
 DIVISION OF TRANSPORTATION
 PHONE: (647) 866-2940

DESIGNED - DSM	REVISED - 7/1/11 PER IDOT
DRAWN - DSM	REVISED - 8/28/11 PER IDOT
CHECKED - SN, PC	REVISED -
DATE - 1 / 27 / 2011	REVISED -

STATE OF ILLINOIS
 DEPARTMENT OF TRANSPORTATION

DRAINAGE & UTILITY PLAN
 CHICAGO AVENUE

SCALE: 1" = 20' SHEET NO. 18 OF 39 SHEETS STA. 41+00 TO STA. 47+00

F.A.U. RTE.	SECTION	COUNTY	TOTAL SHEETS	SHEET NO.
2853	10-00269-00-LS	COOK	39	18
CONTRACT NO. 63593				
ILLINOIS FED. AID PROJECT				