



F.A. RTE.	SECTION	COUNTY	TOTAL SHEETS	SHEET NO.
2853	10-00259-00-1S	COOK	39	30
STA.		TO STA.		
FED. ROAD DIST. NO.	ILLINOIS	FED. AID PROJECT		

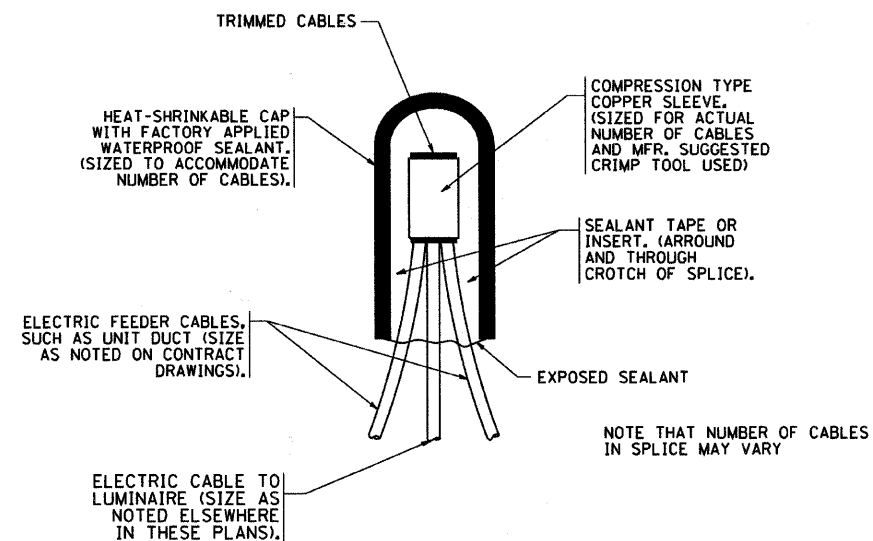


TYPICAL SPLICE DETAIL

N.T.S.

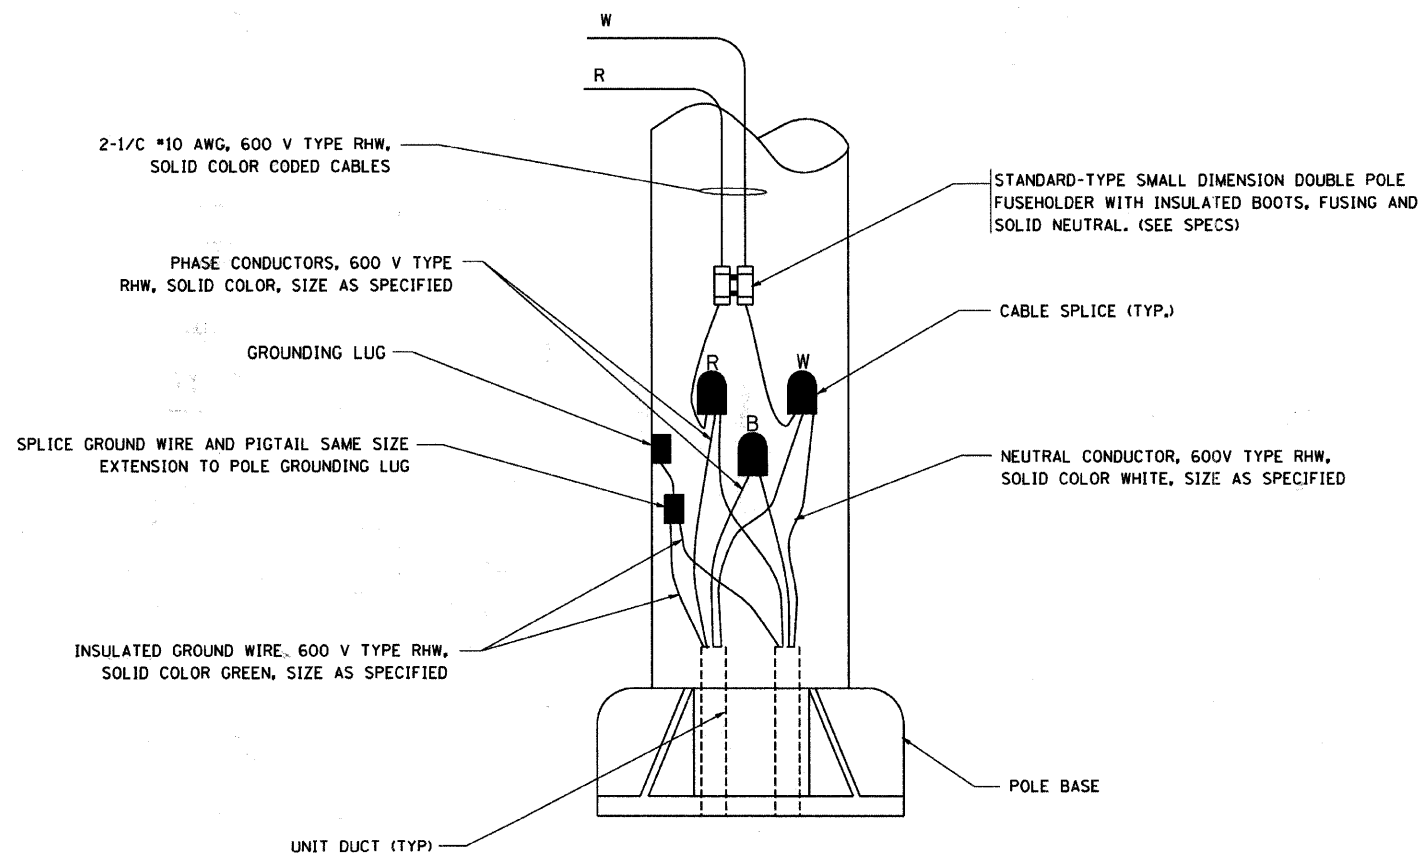

POLE WIRING DETAIL

N.T.S.

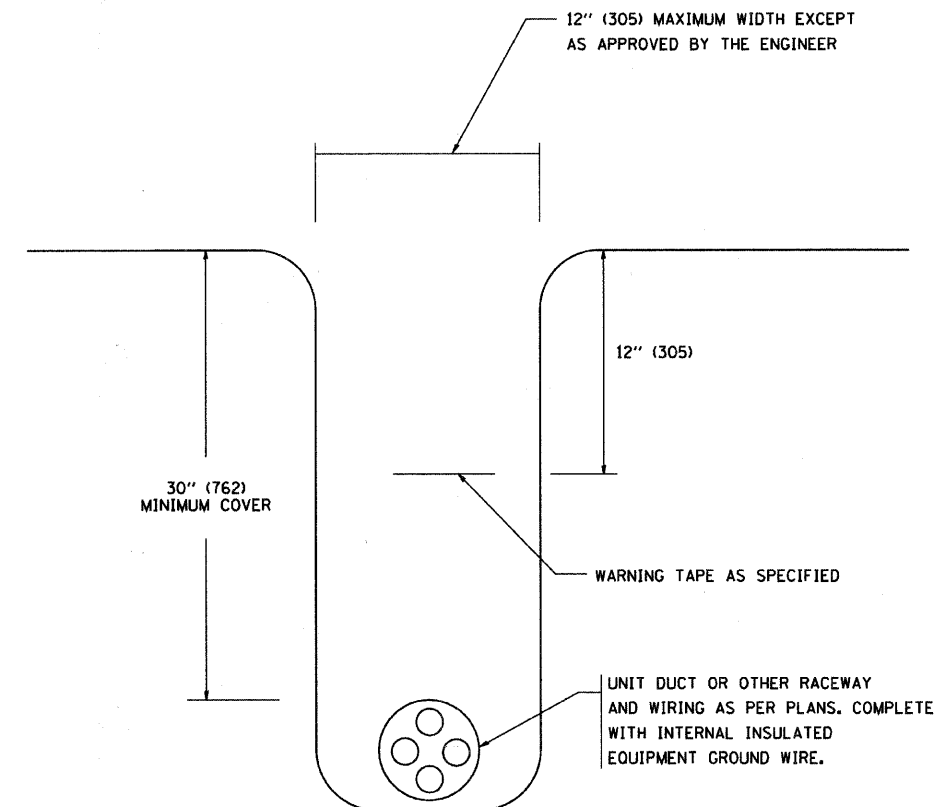

TYPICAL WIRING IN TRENCH DETAIL

N.T.S.

PLOT DATE = 2/27/2007  
 FILE NAME = 2/27/2007  
 PLOT SCALE = 80.000 / IN.  
 USER NAME = bauer-d

REVISIONS	
NAME	DATE

ILLINOIS DEPARTMENT OF TRANSPORTATION

MISC. ELECTRICAL DETAILS SHEET A

SCALE: VERT.  
 HORIZ.  
 DATE: 2/27/2007

DRAWN BY  
 CHECKED BY  
 BE-702  
 REVISION DATE: 01/01/07