
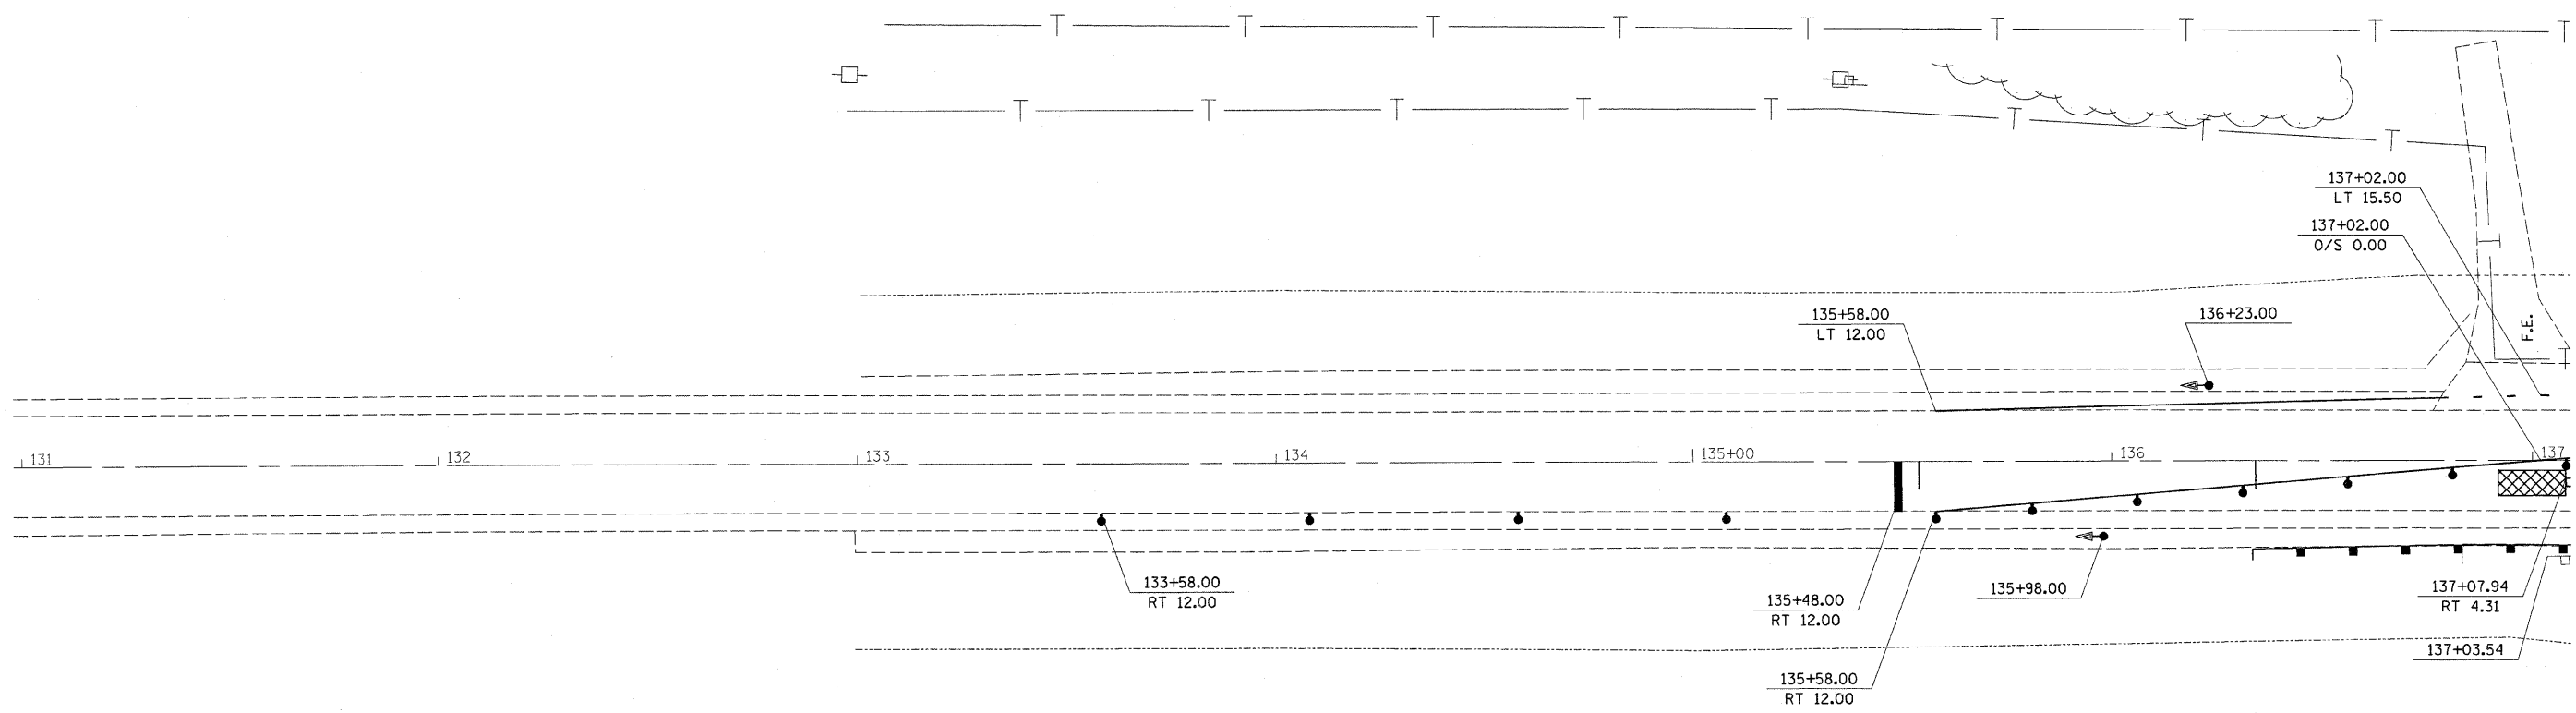



STAGE I SEQUENCE OF OPERATIONS

1. ERECT SIGNS, TRAFFIC SIGNALS, TEMPORARY BARRIERS, ETC. ACCORDING TO TRAFFIC CONTROL STANDARD 701321 AND THE DETAILS IN THE PLANS.
2. REMOVE THE STAGE I PORTION OF THE EXISTING STRUCTURE, PAVEMENT, SHOULDERS, AND GUARDRAIL.
3. CONSTRUCT THE STAGE I PORTION OF THE PROPOSED STRUCTURE, BRIDGE APPROACH PAVEMENT CONNECTOR, TEMPORARY RAMPS, RIP RAP, AND NEW GUARDRAIL.

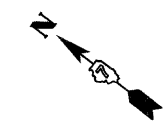

PLACEMENT OF BARRIER DETAIL

- LEGEND**
- TEMPORARY BRIDGE TRAFFIC SIGNALS
 - IMPACT ATTENUATORS, TEMPORARY (NON-REDIRECTIVE) TEST LEVEL 3
 - TEMPORARY CONCRETE BARRIER
 - STOP BAR

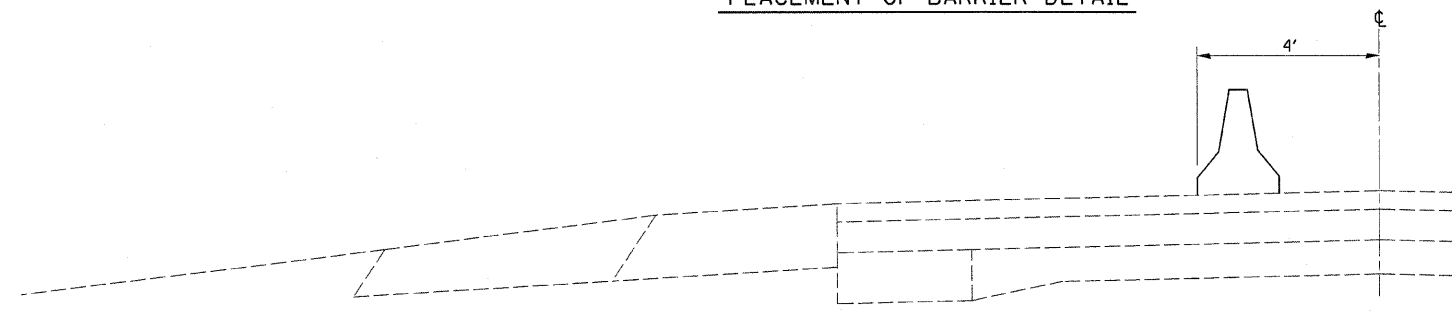

FILE NAME =	USER NAME = swartzrw	DESIGNED -	REVISED -	STATE OF ILLINOIS DEPARTMENT OF TRANSPORTATION	STAGE I CONSTRUCTION			F.A.P. RTE. =	SECTION	COUNTY	TOTAL SHEETS	SHEET NO.
cc:\pw_work\pwidot\swartzrw\dms52012\d774280-sh1-stage1.dgn		DRAWN -	REVISED -		SCALE: 20	SHEET NO. 1 OF 3 SHEETS	STA. 131+00 TO STA. 137+00	320	(102BY)B-1	MOULTRIE	48	11
PLOT SCALE = 20.0000' / 1" =		CHECKED -	REVISED -					CONTRACT NO. 74280				
PLOT DATE = 8/9/2011		DATE -	REVISED -					ILLINOIS FED. AID PROJECT				