
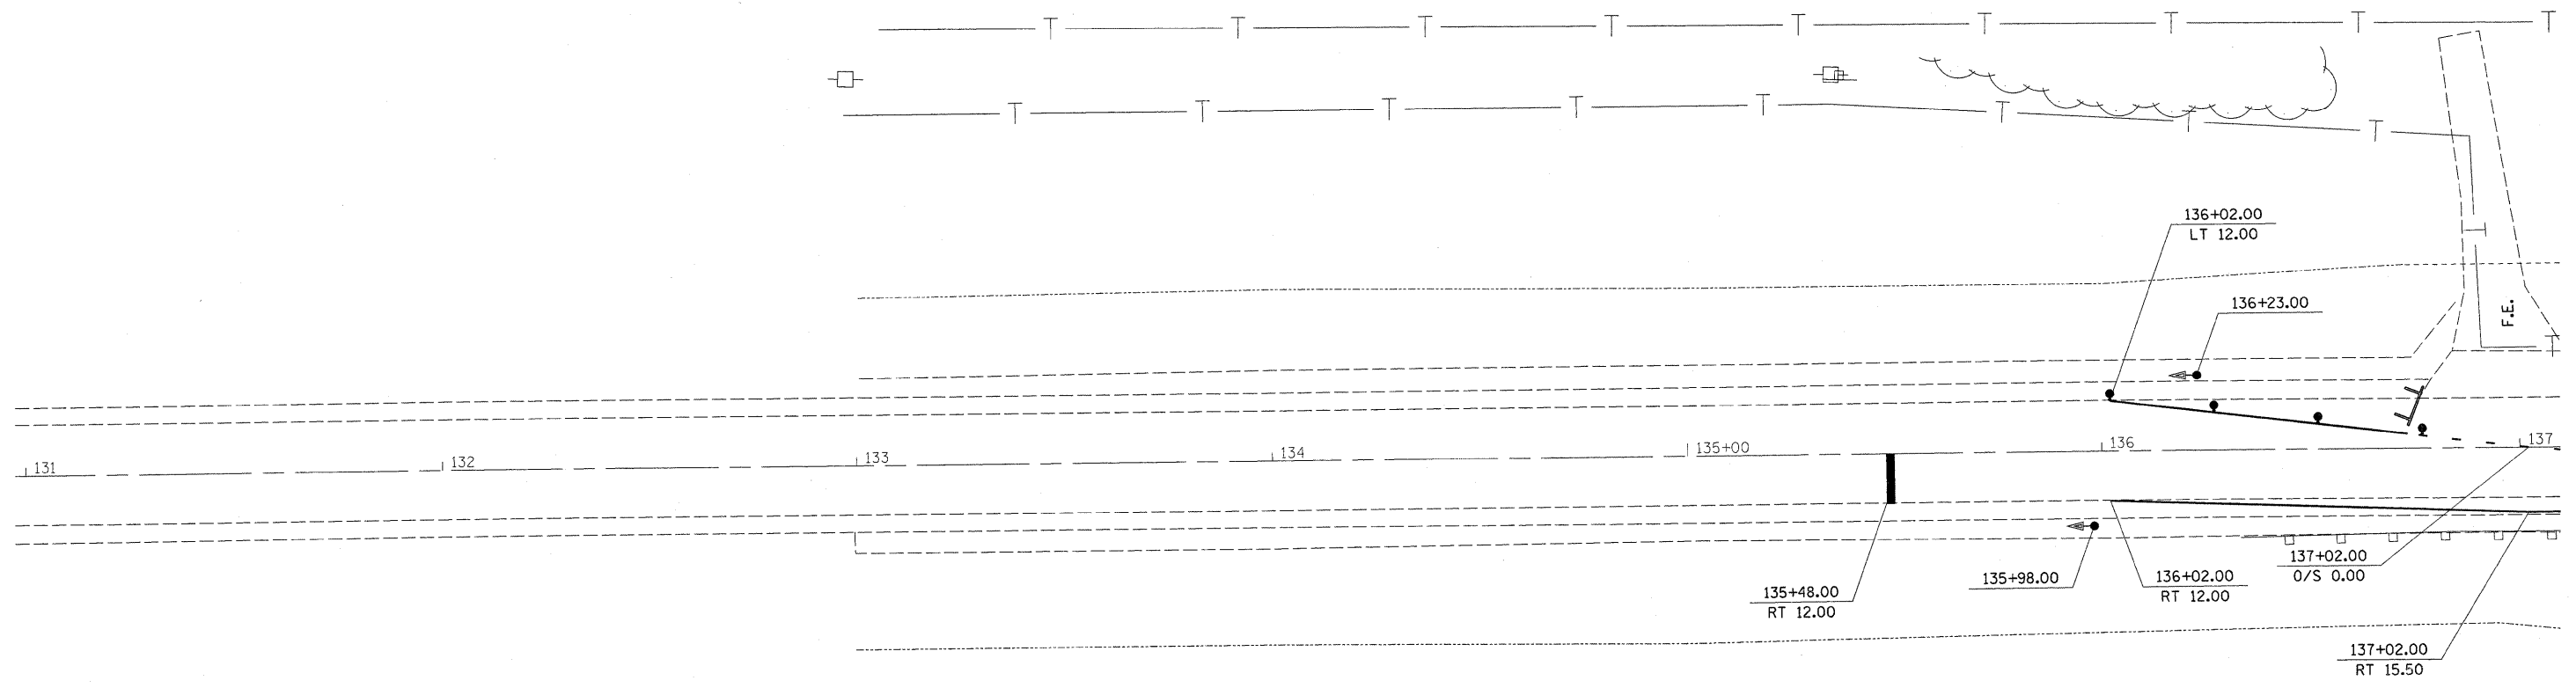


STAGE II SEQUENCE OF OPERATIONS


1. RELOCATE TEMPORARY CONCRETE BARRIERS, SIGNS, ETC. ACCORDING TO TRAFFIC CONTROL STANDARD 701321 AND THE DETAILS IN THE PLANS.
2. REMOVE THE STAGE II PORTION OF THE EXISTING STRUCTURE, PAVEMENT, SHOULDERS, AND GUARDRAIL.
3. CONSTRUCT THE STAGE II PORTION OF THE STRUCTURE, BRIDGE APPROACH PAVEMENT CONNECTOR, TEMPORARY RAMPS, RIP RAP, AND NEW GUARDRAIL. REMOVE TRAFFIC CONTROL STANDARD 701321.
4. COMPLETE ALL HOT-MIX ASPHALT RESURFACING. CONSTRUCT HOT-MIX ASPHALT AND AGGREGATE SHOULDERS. COMPLETE EARTHWORK.
5. CONSTRUCT SEEDING, PAVEMENT MARKING, AND ANY OTHER WORK NECESSARY TO COMPLETE THE PROJECT.

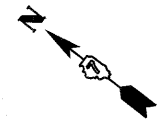

LEGEND

- TEMPORARY BRIDGE TRAFFIC SIGNALS
- IMPACT ATTENUATORS, TEMPORARY (NON-REDIRECTIVE) TEST LEVEL 3
- TEMPORARY CONCRETE BARRIER
- STOP BAR
- IMPACT ATTENUATOR, TEMPORARY (FULLY-REDIRECTIVE, NARROW) TEST LEVEL 3
- TYPE III BARRICADE

PLACEMENT OF BARRIER DETAIL

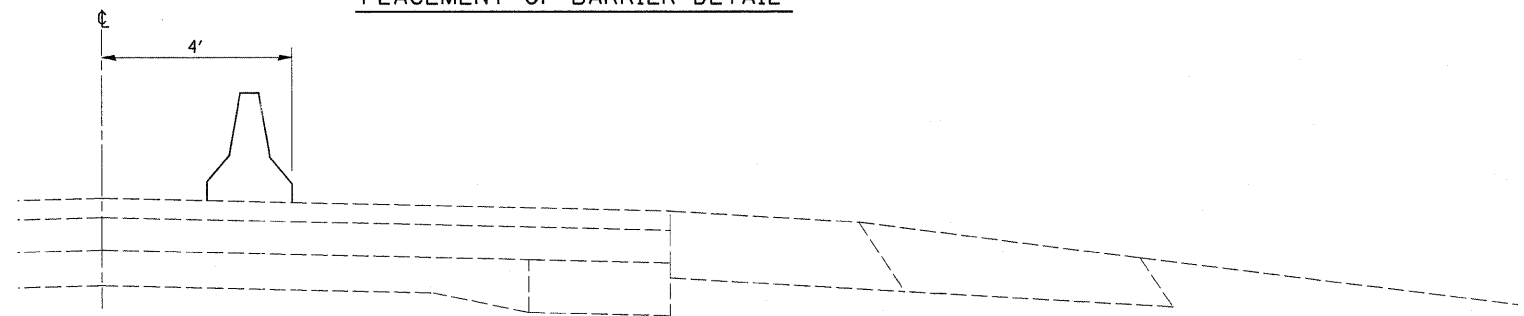

FILE NAME =	USER NAME = swartzrw	DESIGNED -	REVISED -	STATE OF ILLINOIS DEPARTMENT OF TRANSPORTATION	STAGE II CONSTRUCTION			F.A.P. RTE.	SECTION	COUNTY	TOTAL SHEETS	SHEET NO.
ca:\pw\work\p\dot\swartzrw\dms52812\d77	288-sh2-stage2.dgn	DRAWN -	REVISED -		320	(102BY)B-1	MOULTRIE	48	14			
PLOT SCALE = 20.0000' / in.	CHECKED -	REVISED -	REVISED -		CONTRACT NO. 74280			ILLINOIS FED. AID PROJECT				
PLOT DATE = 8/9/2011	DATE -	REVISED -	REVISED -		SCALE: 20	SHEET NO. 1 OF 3 SHEETS	STA. 131+00 TO STA. 137+00					