
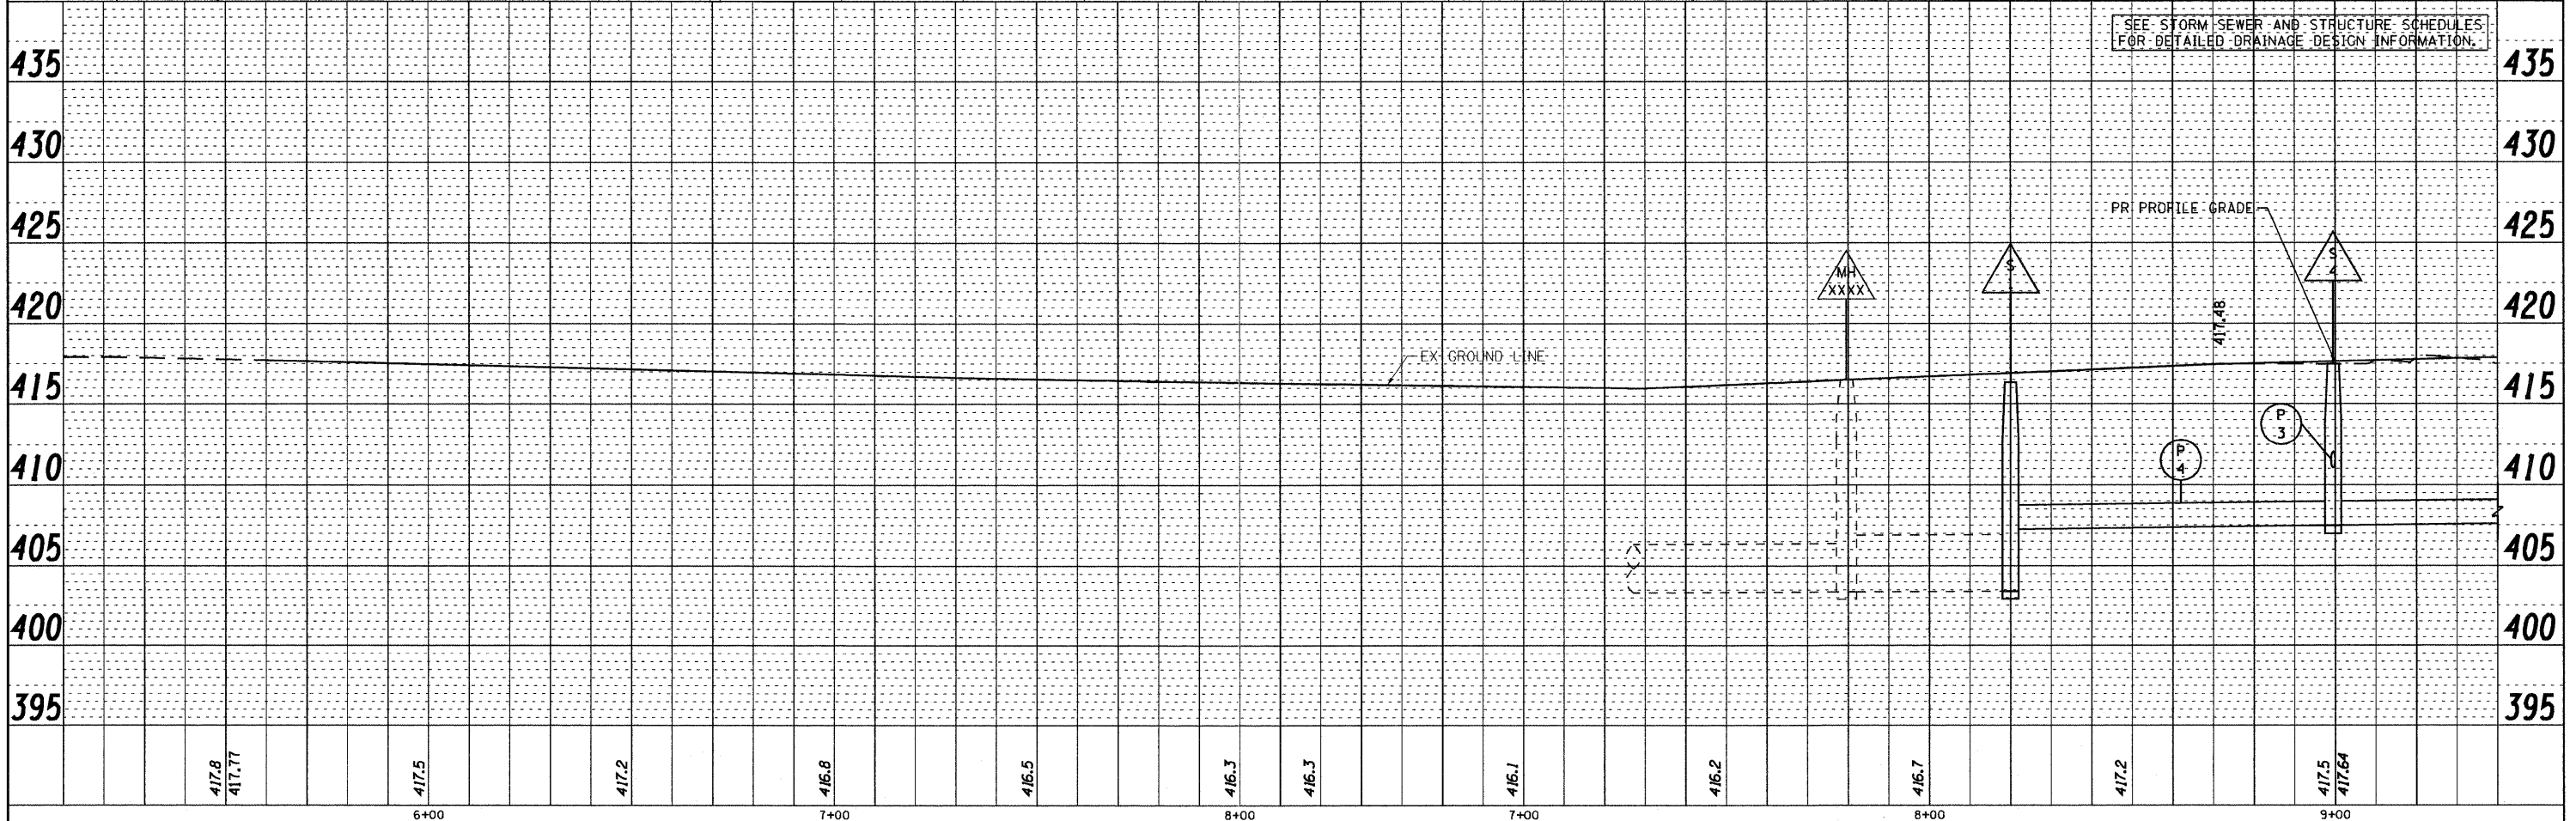
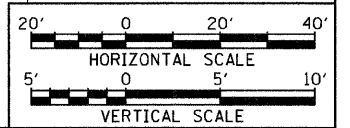


PLAN	STRIPPED	BY	DATE
	PLOTTED		
	CHECKED		
	ALIGNED		
	CADD FILE NAME		
	NO.		

PROFILE	REVISED	BY	DATE
	PLOTTED		
	CHECKED		
	STRUCTURE		
	NOTATION		
	BRK		
	NO.		

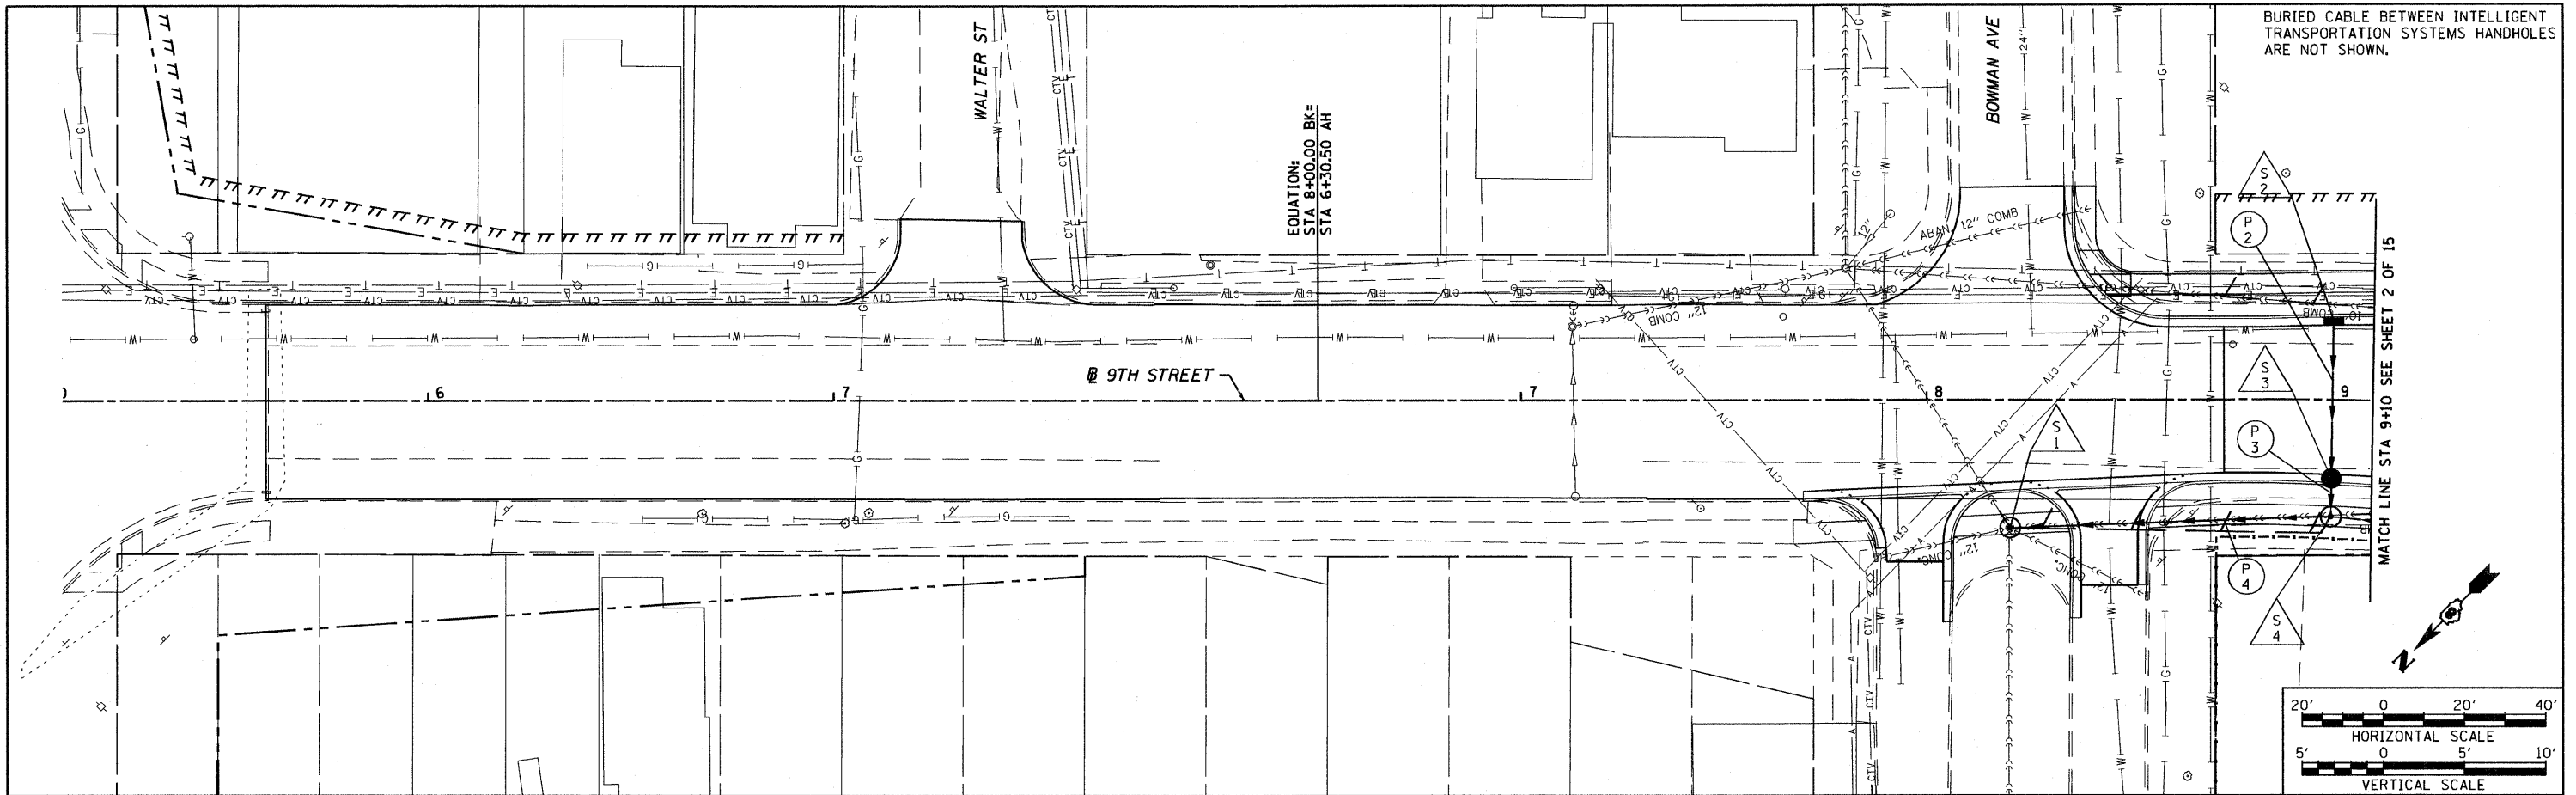

SEE STORM SEWER AND STRUCTURE SCHEDULES FOR DETAILED DRAINAGE DESIGN INFORMATION.

FILE NAME = DBTRI-76C51-sht-drnutil-001-014.dgn
 USER NAME = jlt
 MODEL NAME = DBTRI-76C51-sht-drnutil-001
 PLOT SCALE = 1:40
 PLOT DATE = 6/8/2011

DESIGNED - LDC	REVISED -
DRAWN - JDF	REVISED -
CHECKED - GEB	REVISED -
DATE - 03/31/11	REVISED -

**STATE OF ILLINOIS
DEPARTMENT OF TRANSPORTATION**

DRAINAGE AND UTILITY PLAN PROFILE 9TH STREET

SCALE: 1"=20' SHEET NO. 1 OF 15 SHEETS STA. 5+10.00 TO STA. 9+10.00

F.A.U. RTE.	SECTION	COUNTY	TOTAL SHEETS	SHEET NO.
	82-1-3HB, 82-2N, 82-1-12RS	ST. CLAIR	352	93
	FAI 64/9166/9180	CONTRACT NO. 76C51		
FED. ROAD DIST. NO.	ILLINOIS	FED. AID PROJECT		

P:\08-2030 CTE TRILEVEL\900_CAD\901_DRAWINGS\08_CONTRACT\SHETS\CVL\DRNAGE\DBTRI-76C51-SHT-DRNUTIL-001-014.DGN