
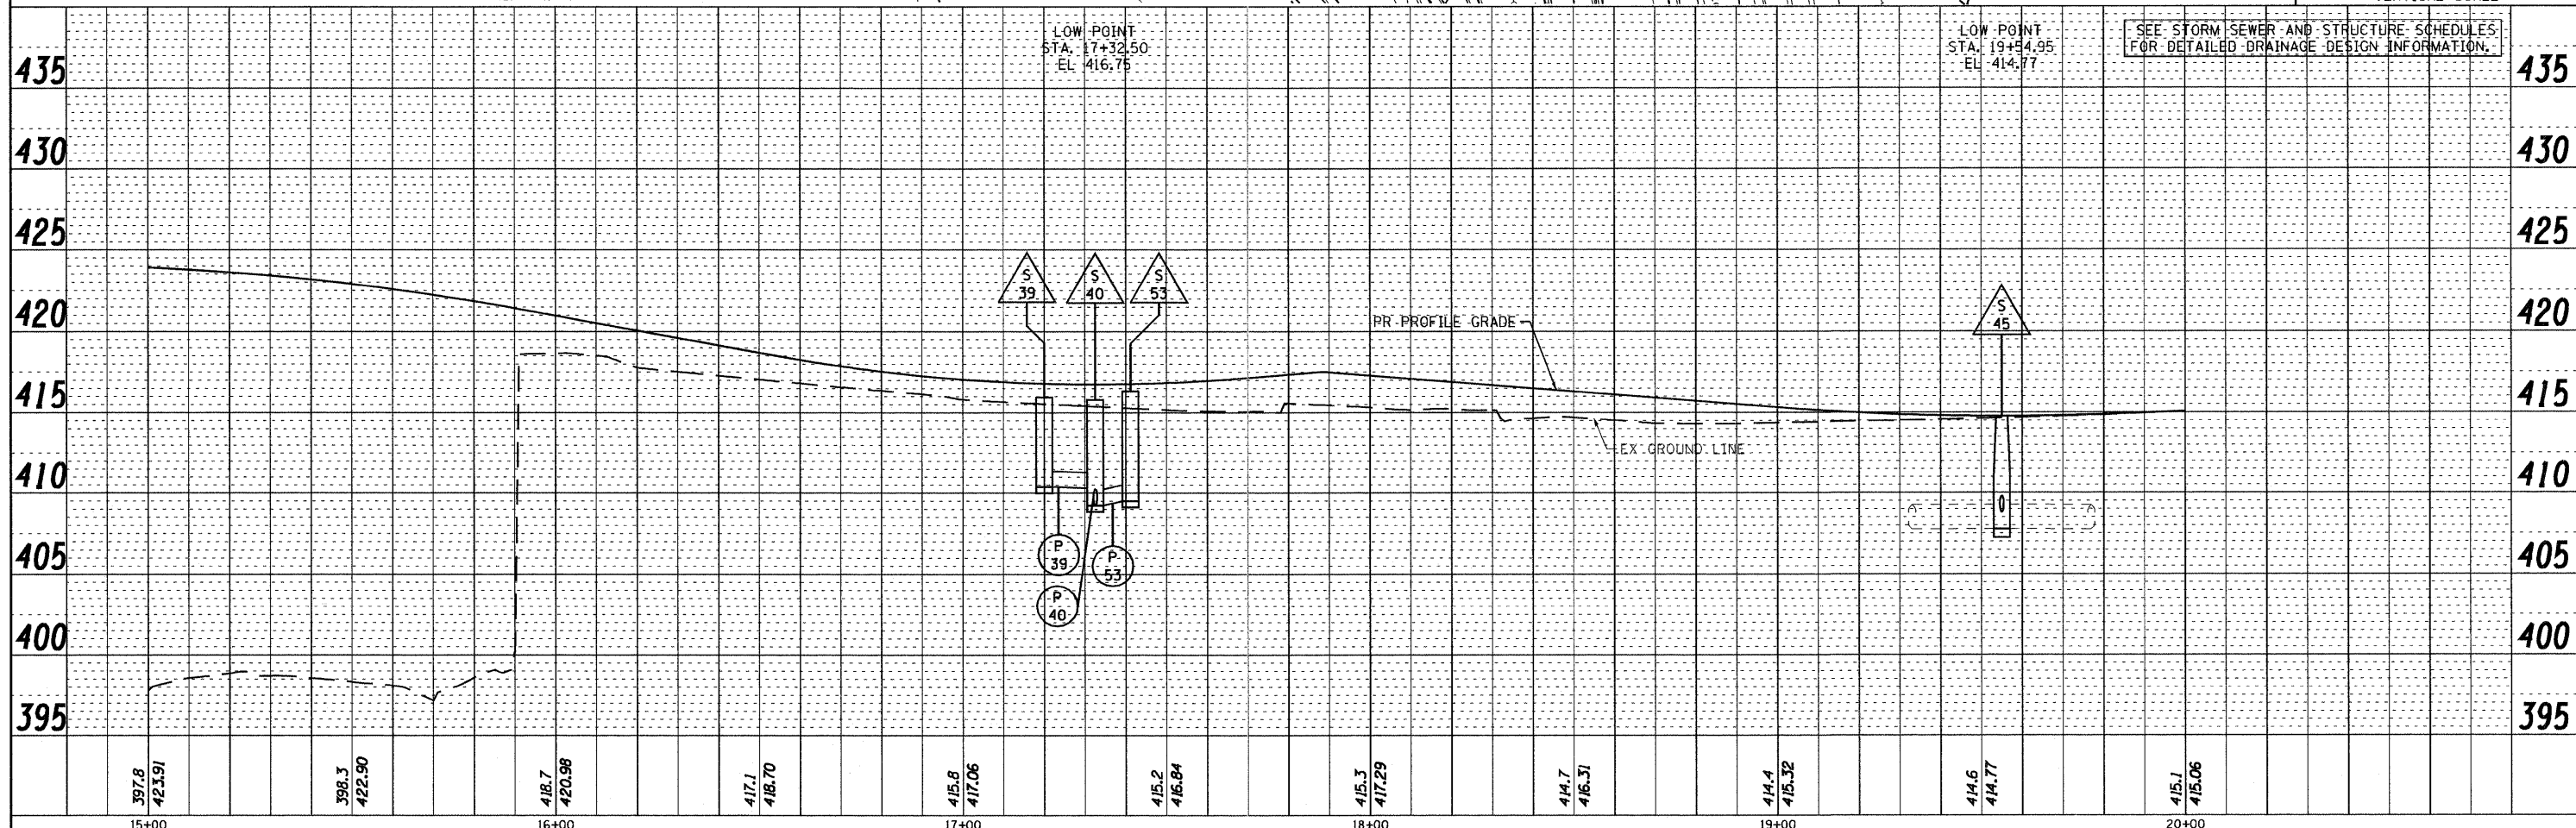


PLAN	SURVEYED	DATE
	PLOTTED	
	CHECKED	
	BY	
	NO.	

PROFILE	SURVEYED	DATE
	PLOTTED	
	CHECKED	
	BY	
	NO.	

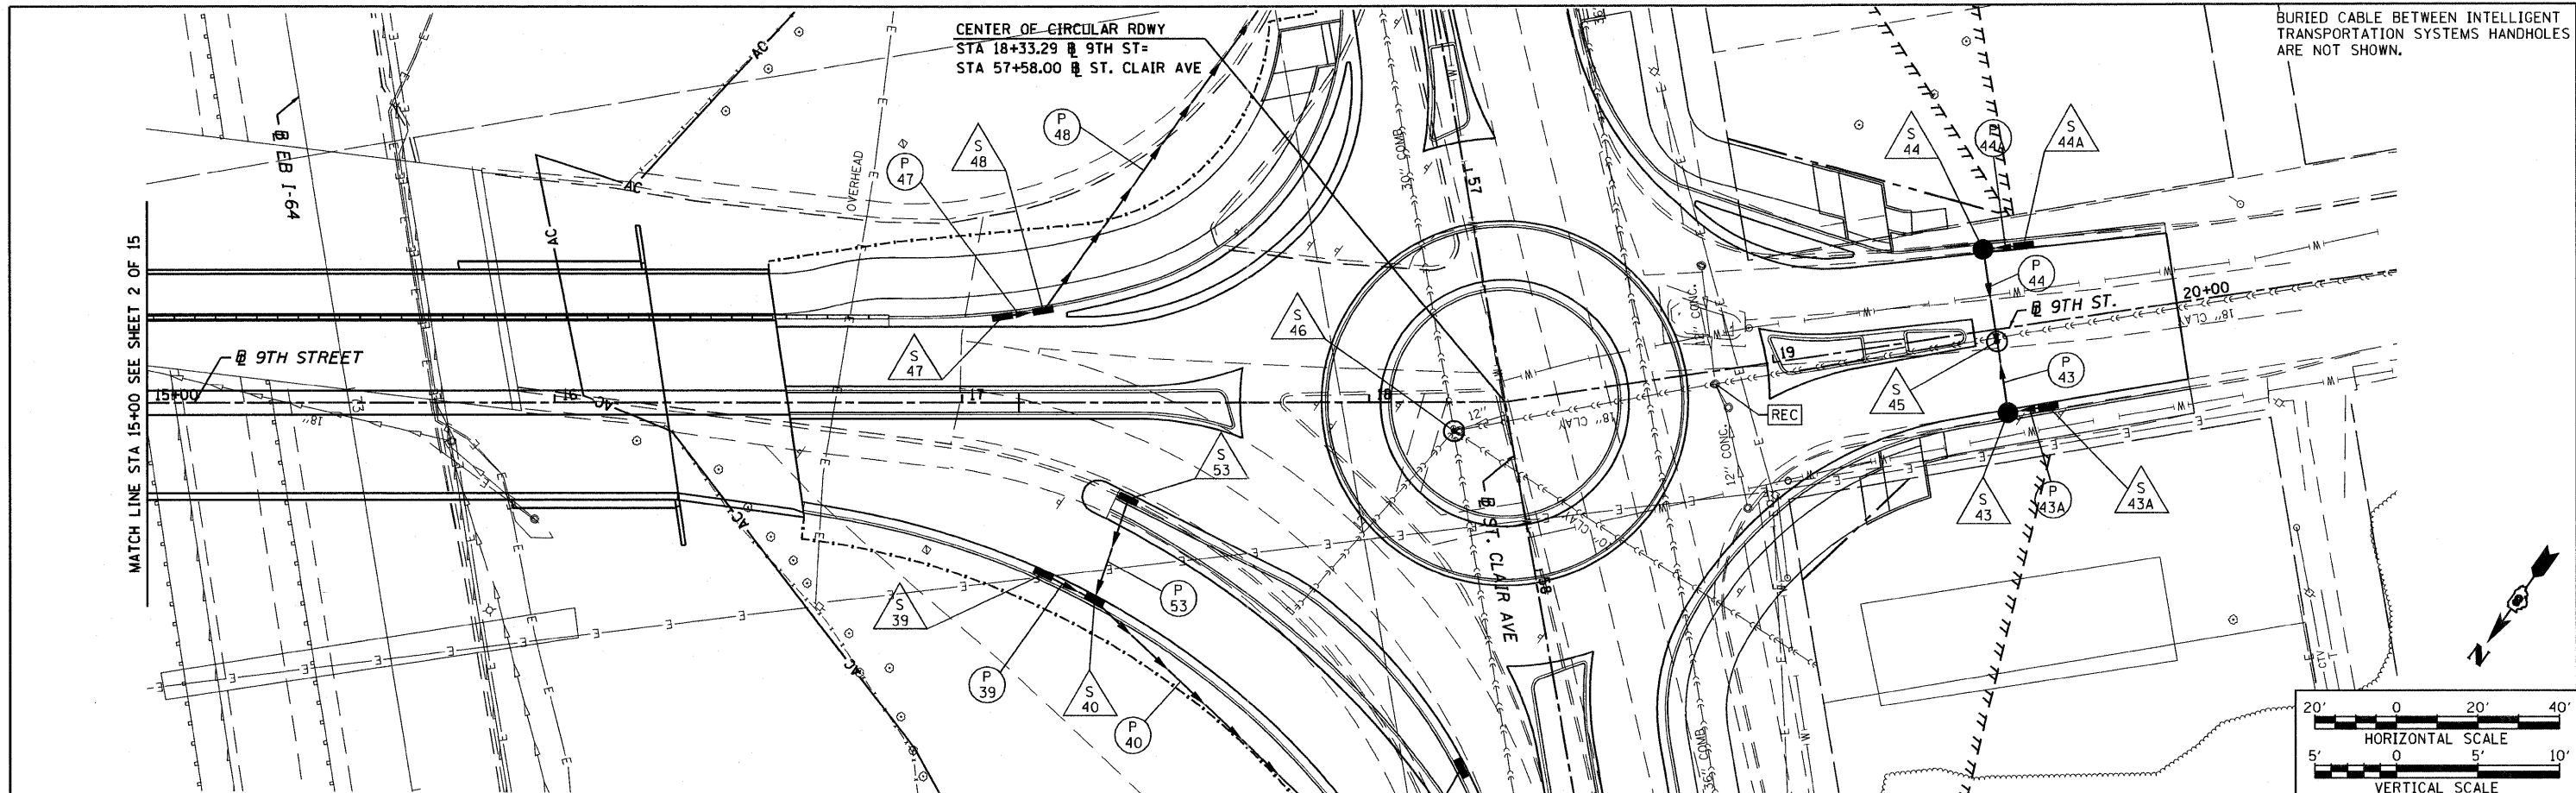

FILE NAME = DBTRI-76C51-sht-drunutil-001-014.dgn	USER NAME = jlt	DESIGNED - LDC	REVISED -	STATE OF ILLINOIS DEPARTMENT OF TRANSPORTATION	DRAINAGE AND UTILITY PLAN PROFILE 9TH STREET	F.A.U. RTE.	SECTION	COUNTY	TOTAL SHEETS	SHEET NO.
MODEL NAME = DBTRI-76C51-sht-drunutil-003	DRAWN - JDF	CHECKED - GEB	REVISED -			82-1-3HB, 82-2N, 82-1-12RS	ST. CLAIR	352	95	
PLOT SCALE = 1:40	DATE - 03/31/11	DATE - 03/31/11	REVISED -			FAI 64/9166/9180	CONTRACT NO. 76C51			
PLOT DATE = 6/8/2011						FED. ROAD DIST. NO.	ILLINOIS FED. AID PROJECT			

6/8/2011 10:48:55 AM

P:\08-0030 CTE TRILEVEL\980_CAD\980_DRAWINGS\08_CONTRACT\SHEET\CIVIL\RAINAGE\DBTRI-76C51-SHT-DRNUTIL-001-014.DGN