

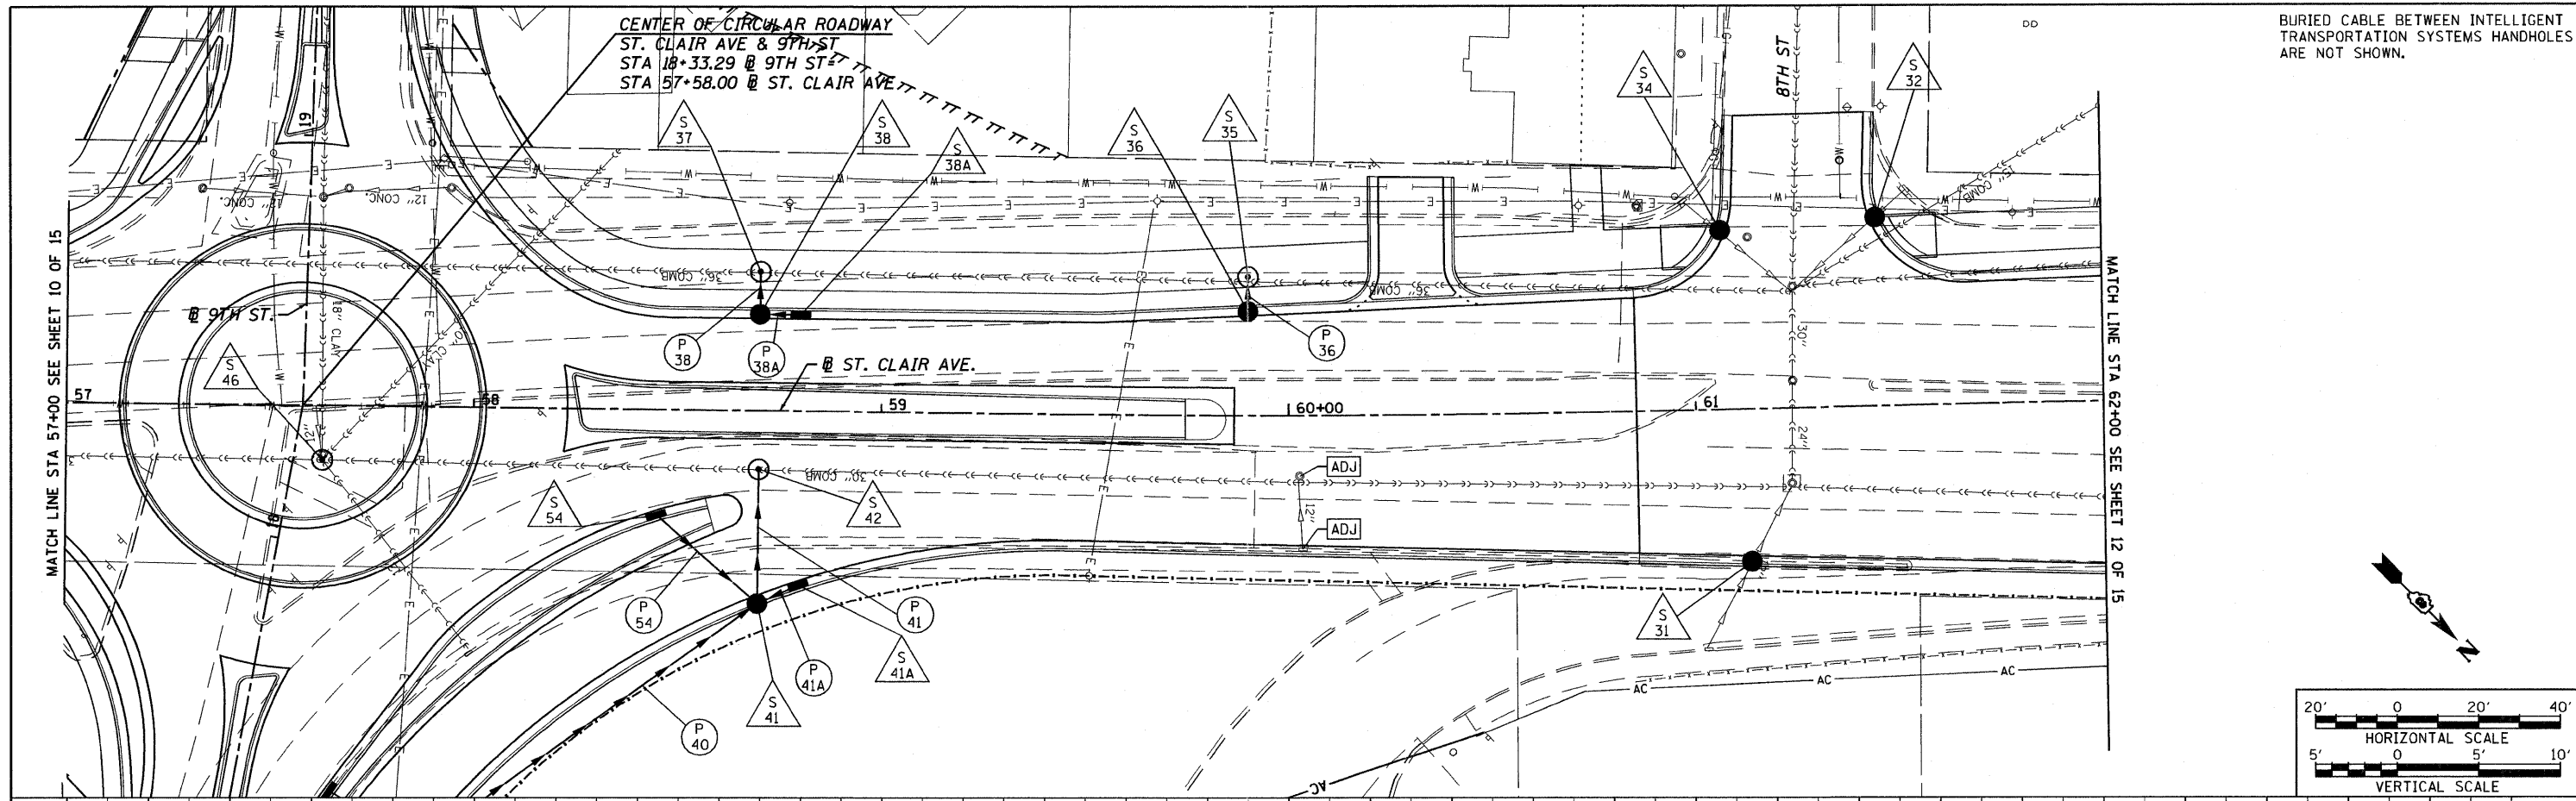


PLAN	SURVEYED	DATE
	PLOTTED	
	CHECKED	
	ATTESTED	
	FILE NAME	
	NO.	

PROFILE	SURVEYED	DATE
	PLOTTED	
	CHECKED	
	ATTESTED	
	FILE NAME	
	NO.	

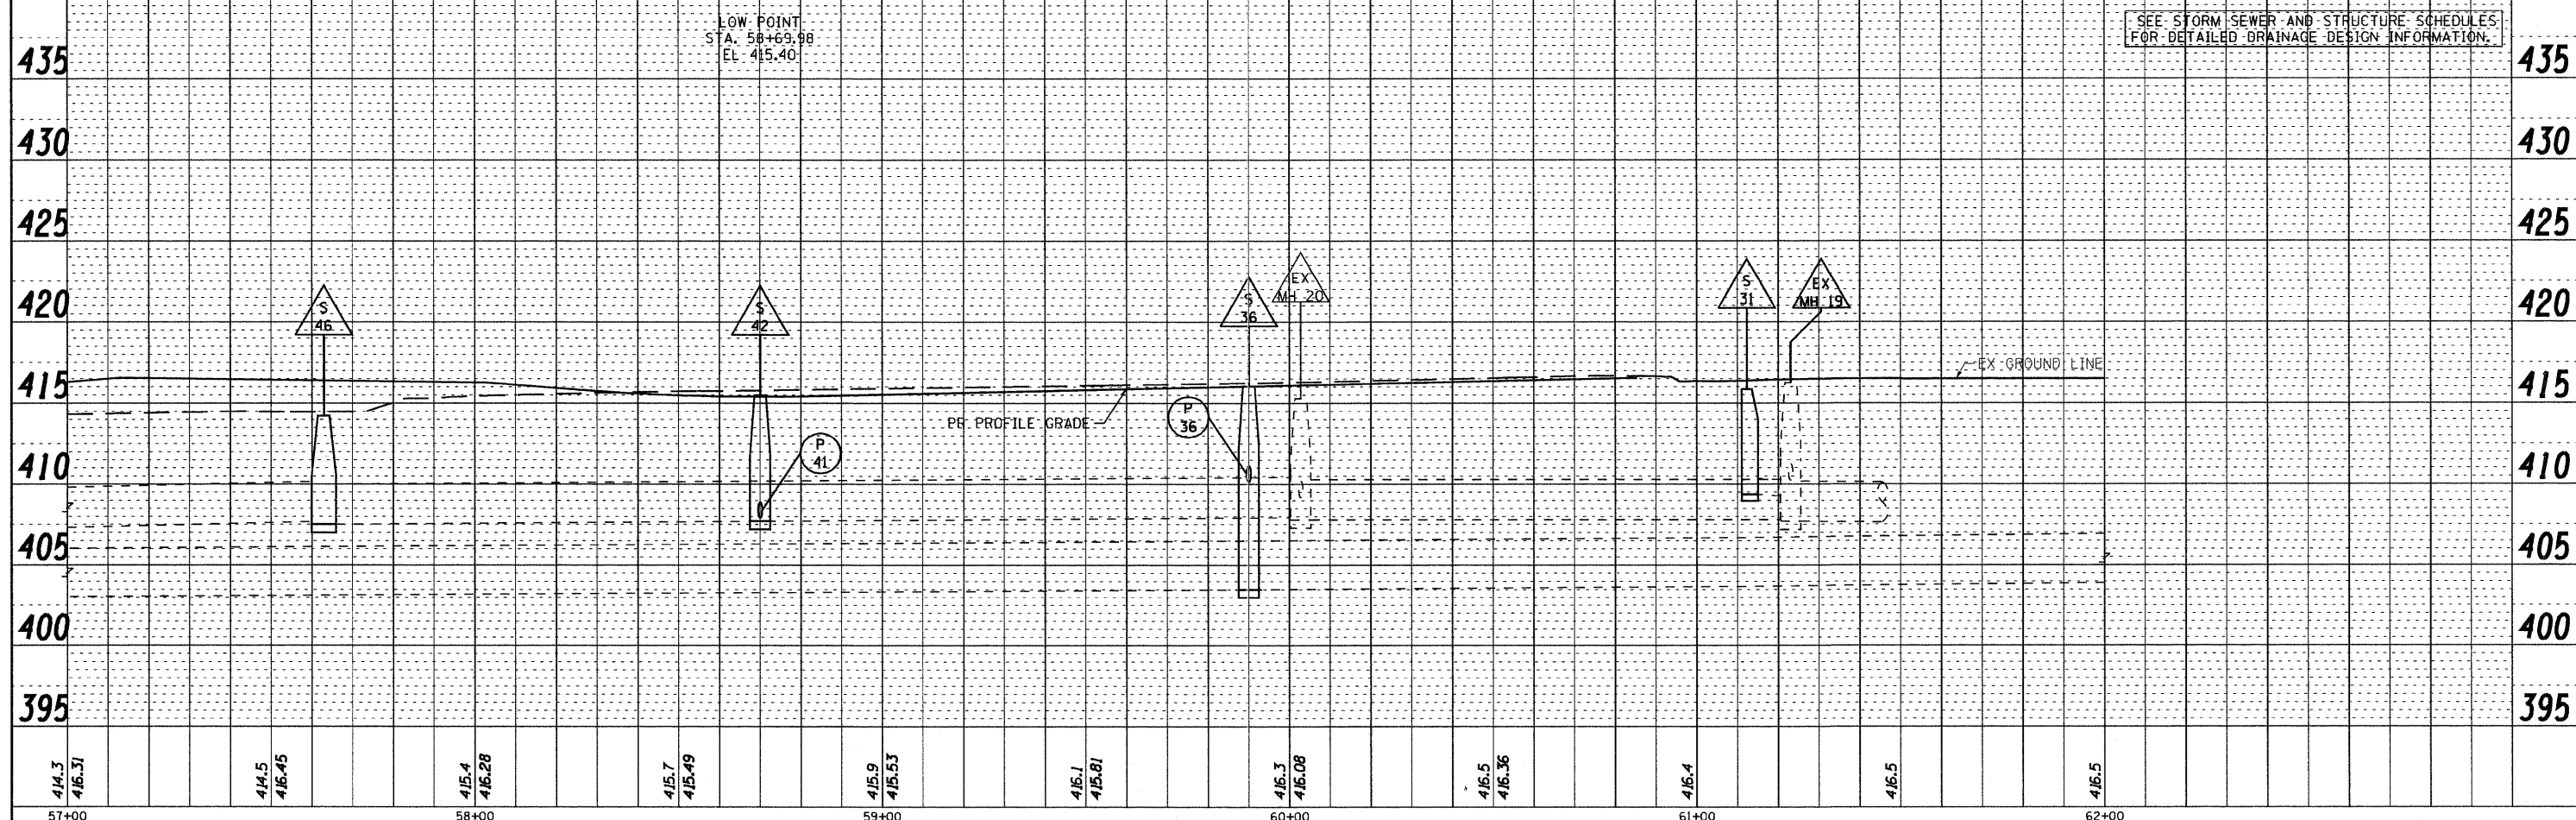

BURIED CABLE BETWEEN INTELLIGENT TRANSPORTATION SYSTEMS HANDHOLES ARE NOT SHOWN.

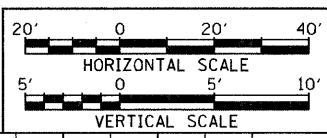

SEE STORM SEWER AND STRUCTURE SCHEDULES FOR DETAILED DRAINAGE DESIGN INFORMATION.

414.3 416.31	414.5 416.45	415.4 416.28	415.7 415.49	415.9 415.53	415.7 415.81	415.3 416.08	416.5 416.36	416.4	416.5	416.5
57+00		58+00		59+00		60+00		61+00		62+00

FILE NAME = D8TR1-76C51-sht-drnutil-001-014.dgn  
 MODEL NAME = D8TR1-76C51-sht-drnutil-011  
 PLOT SCALE = 1:40  
 PLOT DATE = 6/8/2011

USER NAME = jlt  
 DESIGNED - LDC  
 DRAWN - JDF  
 CHECKED - GEB  
 DATE - 03/31/11

REVISI  
 REVISI  
 REVISI  
 REVISI

STATE OF ILLINOIS  
 DEPARTMENT OF TRANSPORTATION

DRAINAGE AND UTILITY PLAN PROFILE ST. CLAIR AVENUE

SCALE: 1"=20' SHEET NO. 11 OF 15 SHEETS STA. 57+00.00 TO STA. 62+00.00

F.A.U. RTE.	SECTION	COUNTY	TOTAL SHEETS	SHEET NO.
	82-1-3HB, 82-2N, 82-1-12RS	ST. CLAIR	352	103
	FAI 64/9166/9180	CONTRACT NO. 76C51		
FED. ROAD DIST. NO.	ILLINOIS FED. AID PROJECT			

P:\08-0030 CTE TRILEVEL\980 CAD\980 DRAWINGS\08 CONTRACT\SHEET\CIVIL\DRAINAGE\D8TR1-76C51-SHT-DRNUTIL-001-014.DGN