

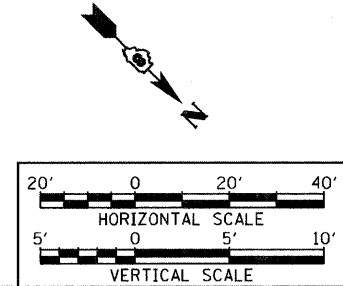


BURIED CABLE BETWEEN INTELLIGENT TRANSPORTATION SYSTEMS HANDHOLES ARE NOT SHOWN.

PLAN	SURVEYED	DATE
	PLOTTED	
	GRADES CHECKED	
	STRUCTURE NOTATIONS OK'D	
	NOTE BOOK	
	NO.	
	BY	
	DATE	

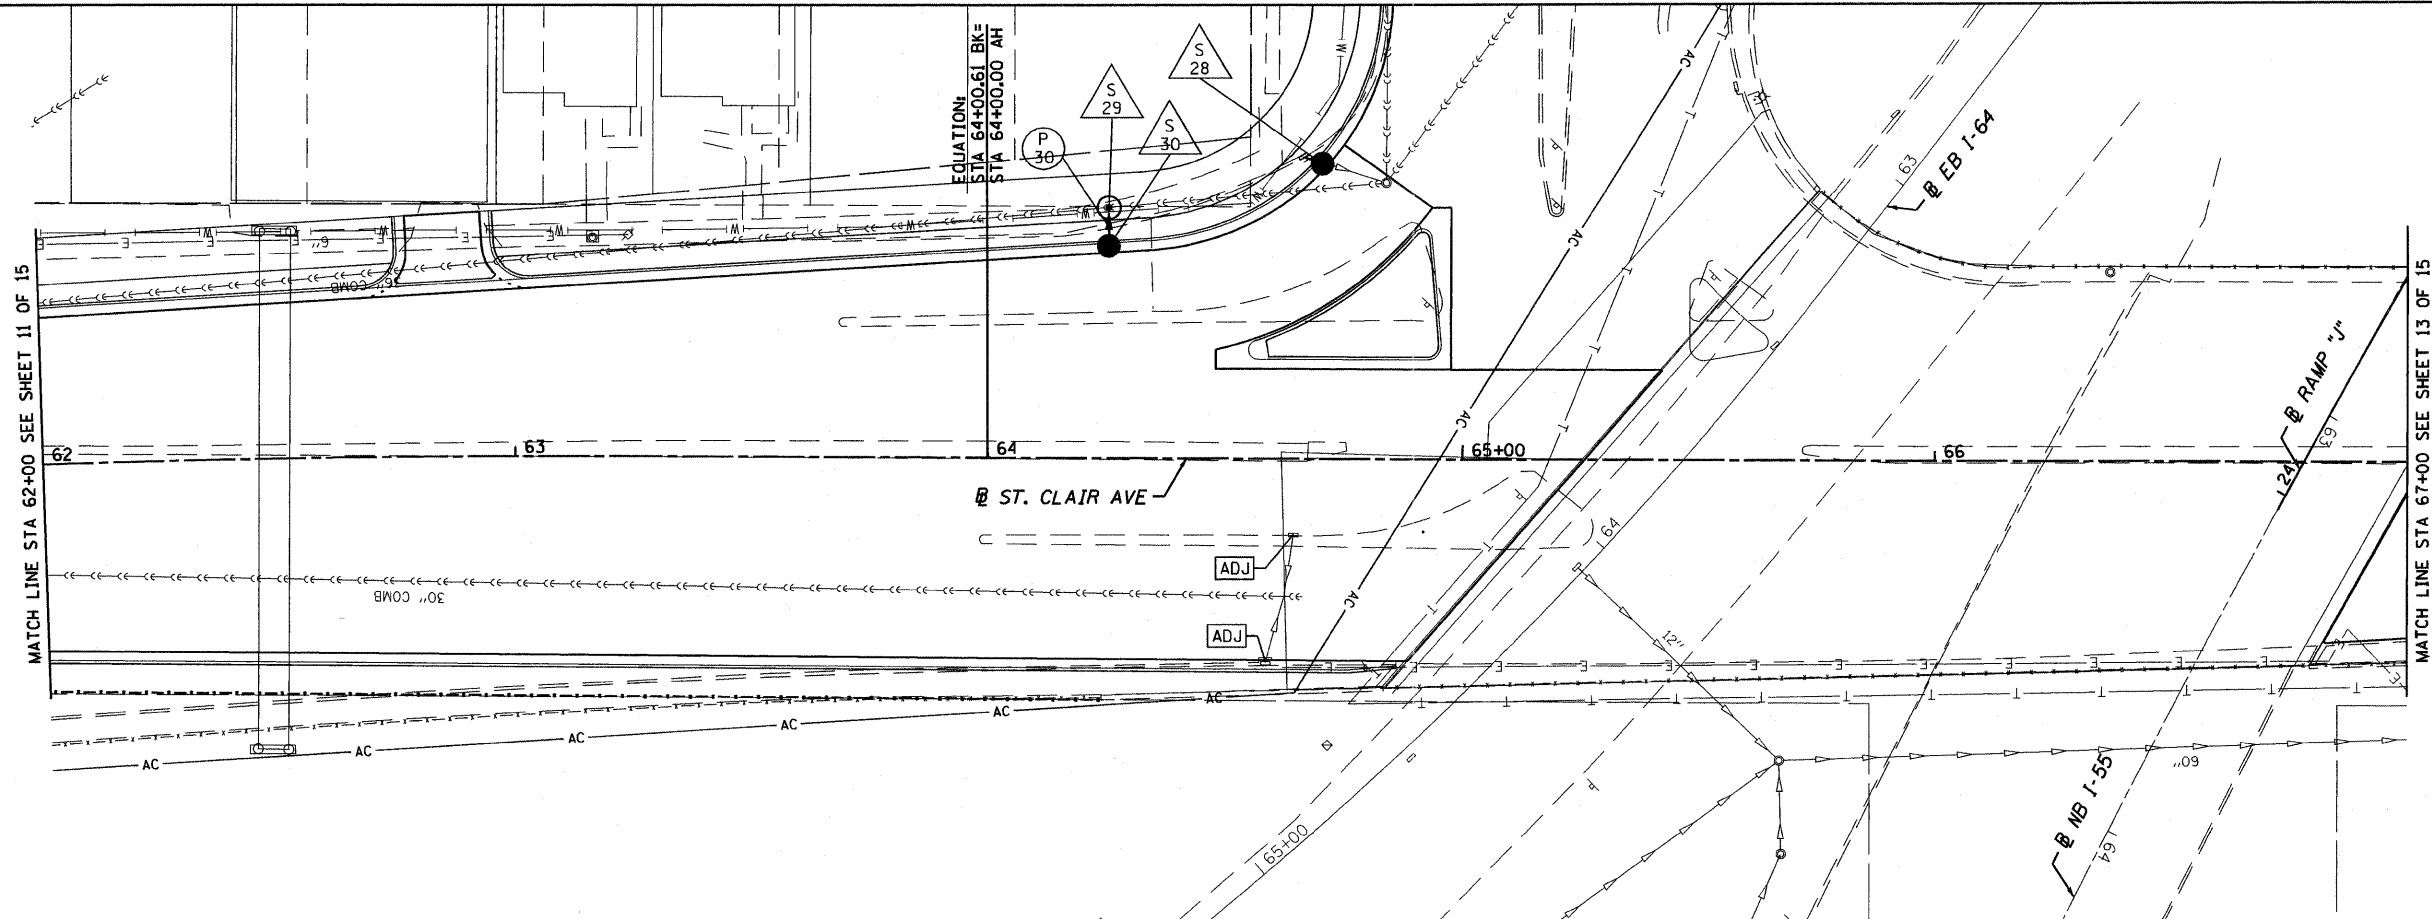

PROFILE	SURVEYED	DATE
	PLOTTED	
	GRADES CHECKED	
	STRUCTURE NOTATIONS OK'D	
	NOTE BOOK	
	NO.	
	BY	
	DATE	

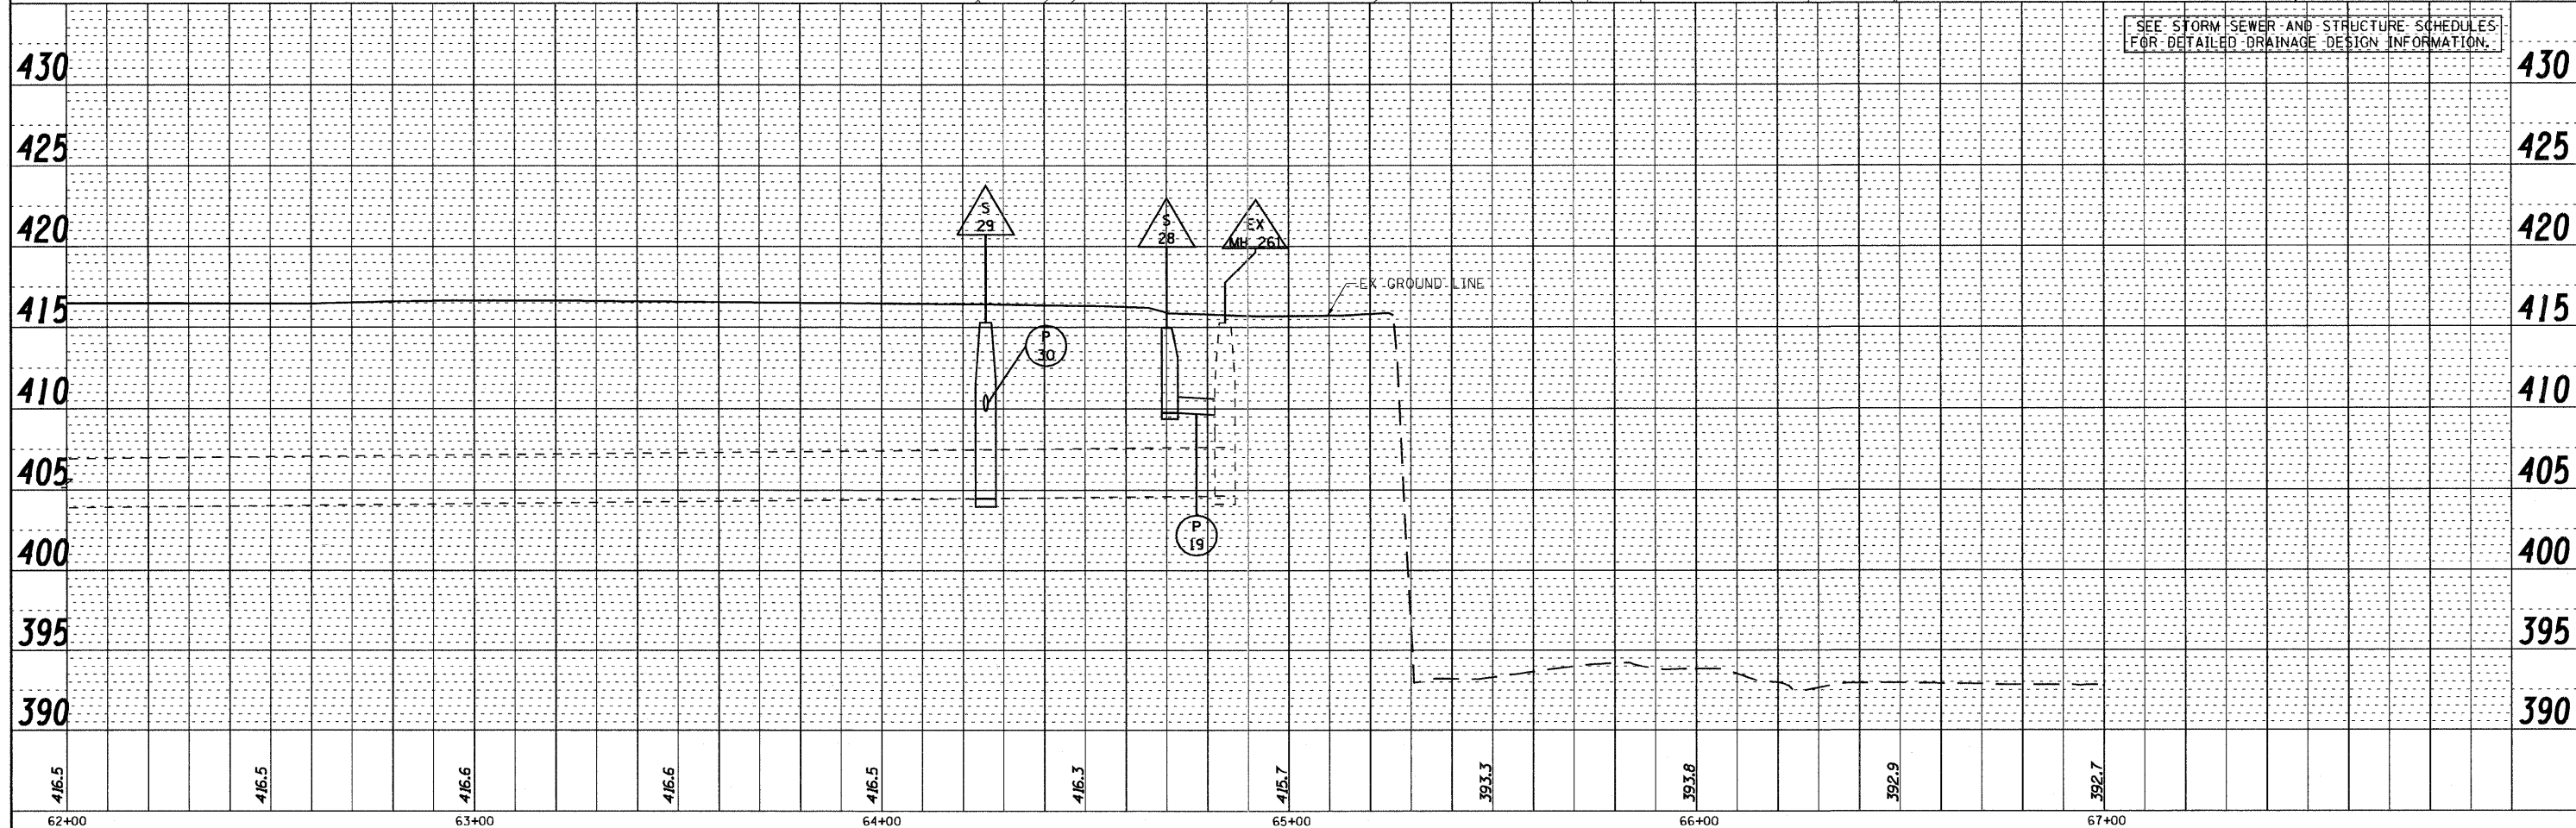

SEE STORM SEWER AND STRUCTURE SCHEDULES FOR DETAILED DRAINAGE DESIGN INFORMATION.

FILE NAME = D:\TR-76C51-sht-dmutil-001-014.dgn  
 MODEL NAME = D:\TR-76C51-sht-dmutil-012  
 PLOT SCALE = 1:40  
 PLOT DATE = 6/8/2011

USER NAME = jlt	DESIGNED - LDC	REVISED -
DRAWN - JDF	CHECKED - GEB	REVISED -
DATE - 03/31/11		

**STATE OF ILLINOIS**  
**DEPARTMENT OF TRANSPORTATION**

**DRAINAGE AND UTILITY PLAN PROFILE ST. CLAIR AVENUE**  
 SCALE: 1"=20'  
 SHEET NO. 12 OF 15 SHEETS  
 STA. 62+00.00 TO STA. 67+00.00

F.A.I. RTE.	SECTION	COUNTY	TOTAL SHEETS	SHEET NO.
	82-1-3HB, 82-2N, 82-1-12RS	ST. CLAIR	352	104
	FAI 64/9166/9180			CONTRACT NO. 76C51
	FED. ROAD DIST. NO.	ILLINOIS	FED. AID PROJECT	

P:\08-0030 CTE TRILEVEL\900 CAD\01 DRAWINGS\08 CONTRACT\SHEET\CVL\DRAINAGE\08TR-76C51-SHT-DRNUTL-001-014.DGN