



STA 62+23.00 (RAMP 70E64E)
 O/S 34.50' LT
 MANHOLES, TYPE A 8'-DIAM.
 TYPE 1 FRAME CL
 EX. RIM: 395.27
 PR. RIM: 393.68
 NW. INV (60"): 382.92
 E. INV (60"): 383.03 (EX)
 NOTE: PROPOSED STRUCTURE RIM
 TO BE ESTABLISHED IN THIS
 CONTRACT TO ACCOMMODATE
 FUTURE GRADING IN CONTRACT
 76C52.



 
STA 61+40.00 (RAMP 70E64E)
 O/S 35.00' LT
 MANHOLES, TYPE A 8'-DIAM. (FST)
 TYPE 1 FRAME CL
 RIM: 390.19
 SE. INV (60"): 382.83
 SW. INV (60"): 382.83




STA 61+05.16 (RAMP 70E64E)
 O/S 0.10' RT
 EXISTING MANHOLE
 TYPE 1 FRAME CL
 RIM: 392.50
 E. INV (12"): 385.82 (EX)
 S. INV (12"): 384.82




STA 61+12.00 (RAMP 70E64E)
 O/S 4.50' RT
 MANHOLES, TYPE A 8'-DIAM. (FST)
 TYPE 1 FRAME CL
 RIM: 392.02
 N. INV (12"): 384.78
 E. INV (60"): 382.78
 W. INV (60"): 382.78



STA 61+02.00 (RAMP 70E64E)
 O/S 19.75' RT
 MANHOLES, TYPE A 9'-DIAM. (FST)
 TYPE 1 FRAME CL
 RIM: 391.62
 NW. INV (60"): 382.72 (EX)
 E. INV (60"): 382.76
 S. INV (12"): 385.42 (EX)

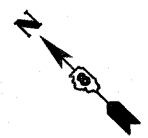


I-70 OVER I-55, CSX, KCS RAILROADS
 BRIDGE STR 082-0322 & 082-0324
 STA 51+92.00 TO STA 74+78.50
 STA 54+99.00 TO STA 64+88.50
 SEE BRIDGE PLANS

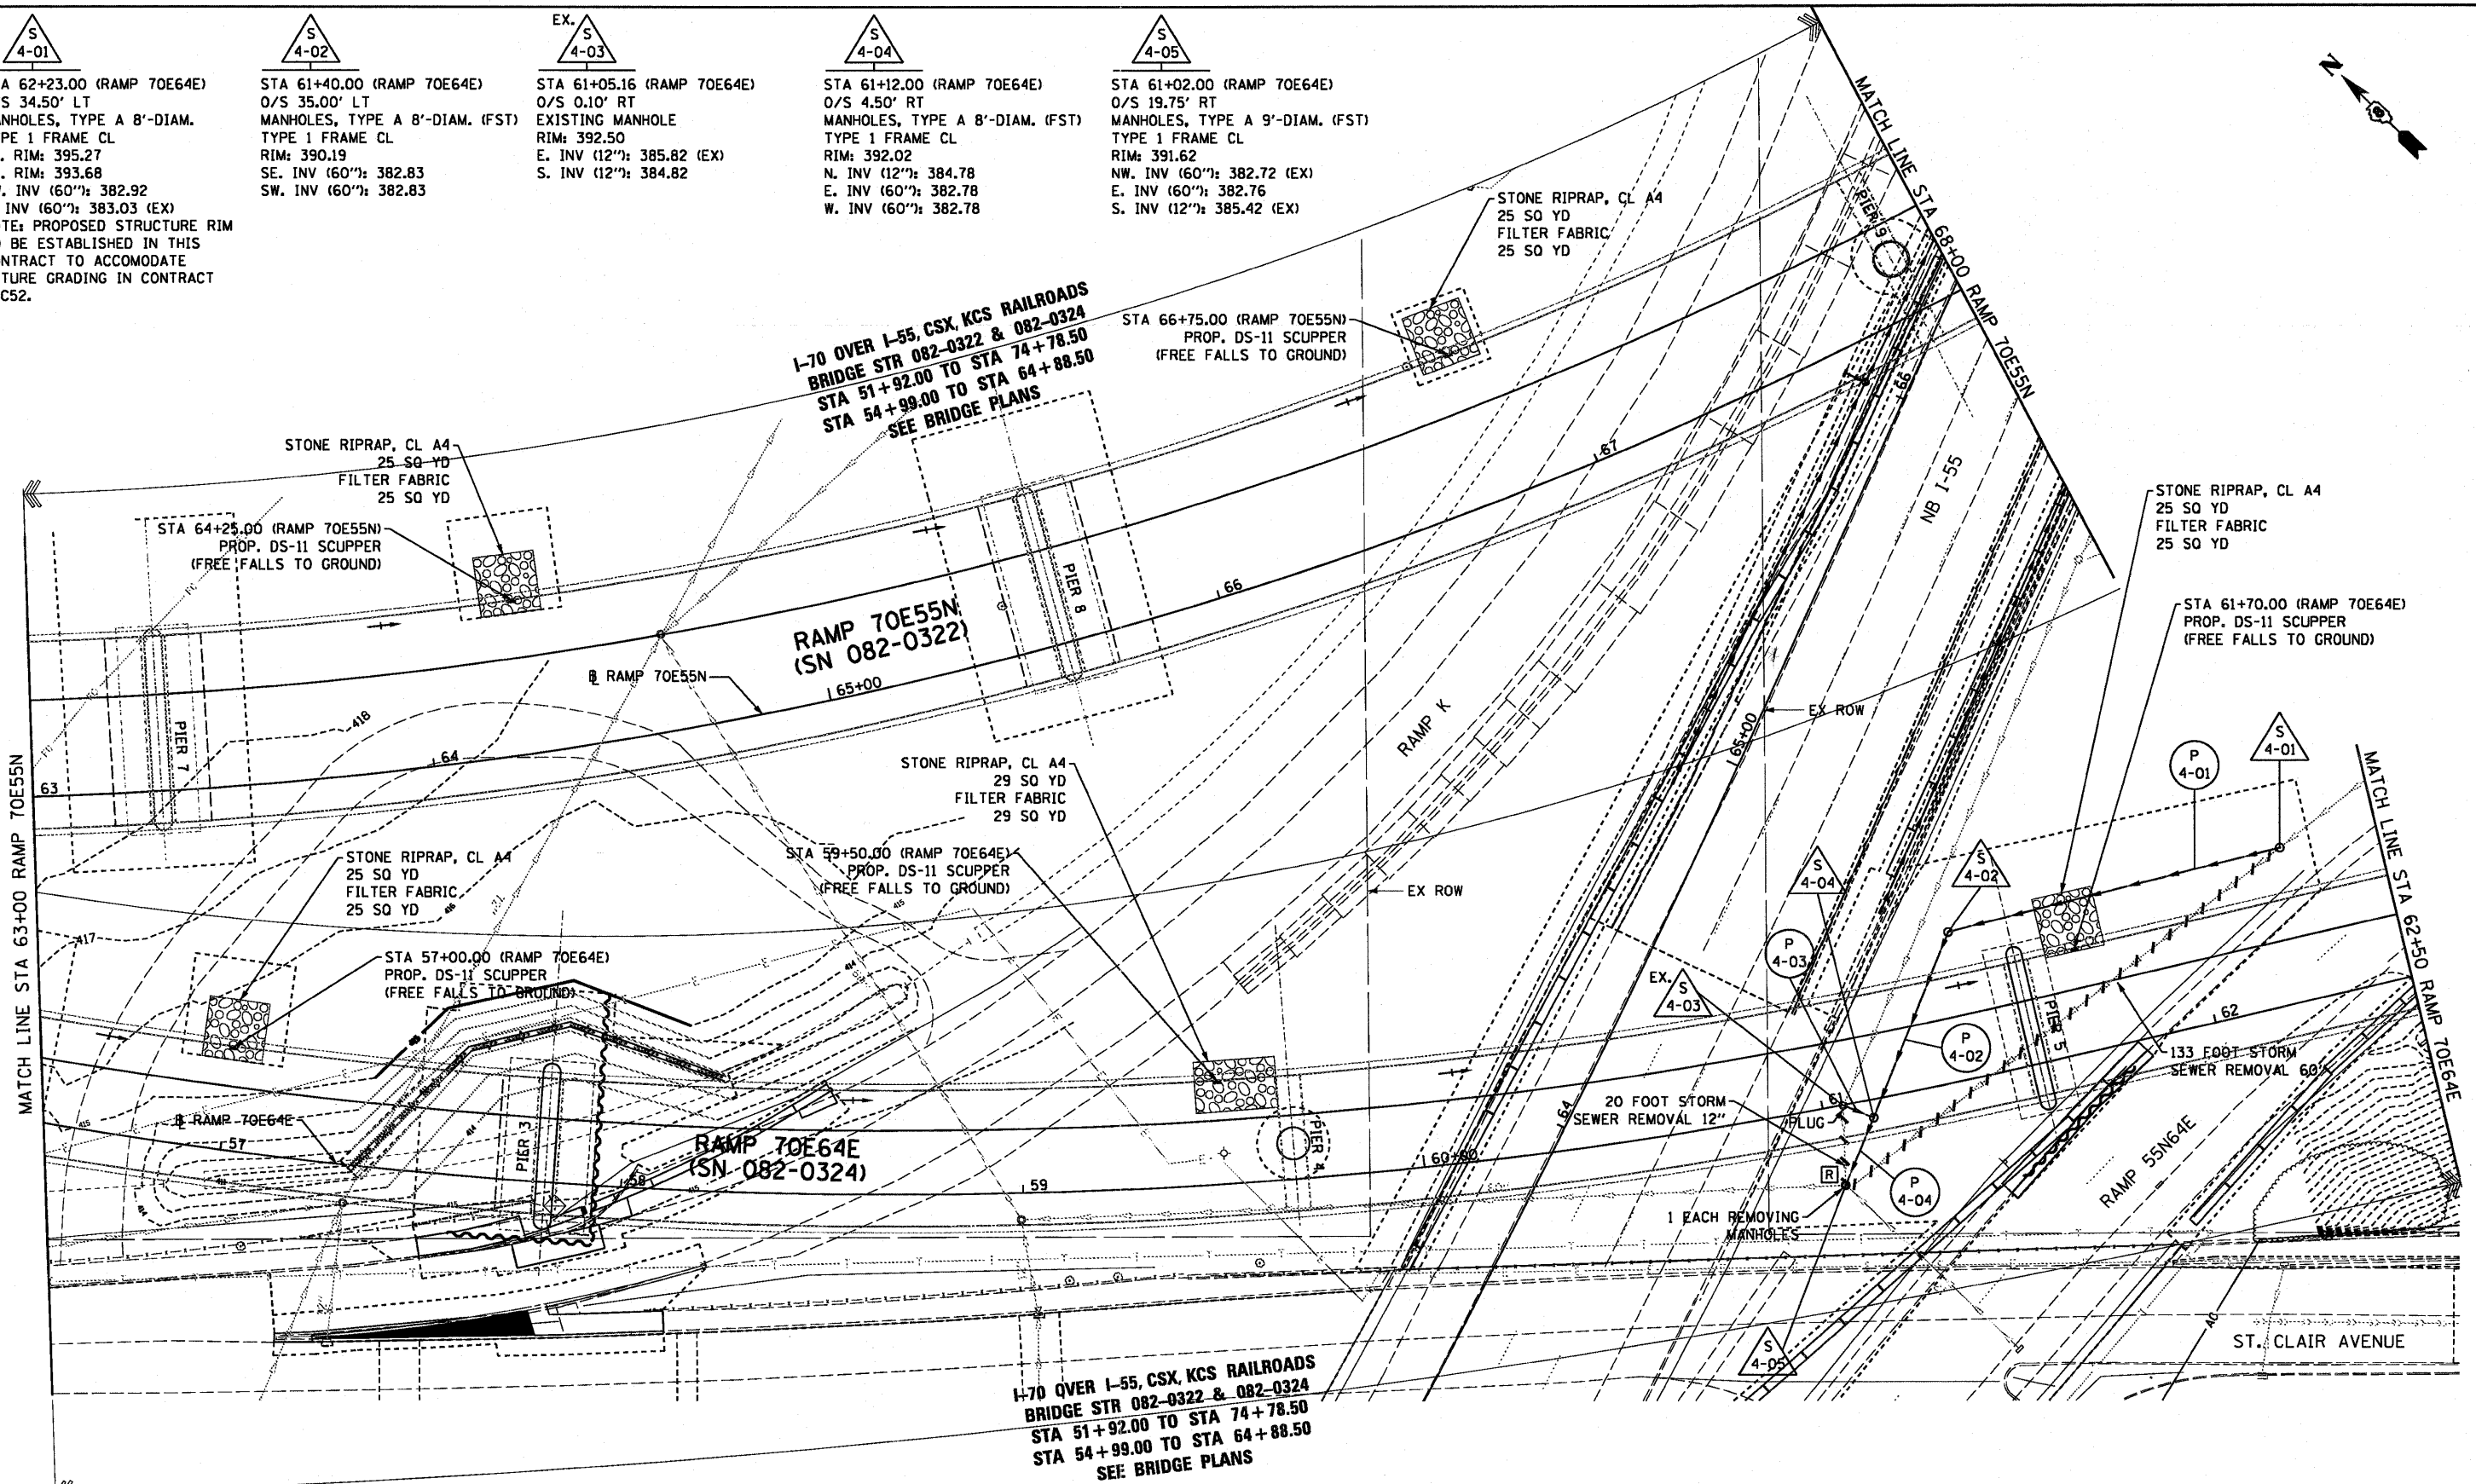

MATCH LINE STA 63+00 RAMP 70E55N

MATCH LINE STA 62+50 RAMP 70E64E

 I-70 OVER I-55, CSX, KCS RAILROADS
 BRIDGE STR 082-0322 & 082-0324
 STA 51+92.00 TO STA 74+78.50
 STA 54+99.00 TO STA 64+88.50
 SEE BRIDGE PLANS



82 FOOT STORM SEWERS
 CLASS A, TYPE 1 60" @ 0.10%
 TBF = 0.0 CU YD



48 FOOT STORM SEWERS
 CLASS A, TYPE 1 60" @ 0.10%
 TBF = 0.0 CU YD



8 FOOT STORM SEWERS
 CLASS A, TYPE 2 12" @ 0.50%
 TBF = 0.0 CU YD



18 FOOT STORM SEWERS
 CLASS A, TYPE 2 60" @ 0.10%
 TBF = 0.0 CU YD

USER NAME = pimarno	DESIGNED KLK	REVISED -
	DRAWN KLK	REVISED -
PLOT SCALE = 40.0000' / 1"	CHECKED EEY	REVISED -
PLOT DATE = 8/9/2011	DATE 08-12-11	REVISED -

STATE OF ILLINOIS
 DEPARTMENT OF TRANSPORTATION

DRAINAGE AND UTILITY PLAN

SCALE: 1" = 20' SHEET NO. 4 OF 7 SHEETS STA. 63+00 TO STA. 68+00

F.A.I. RTE. 64/998	SECTION 82-1-B-2	COUNTY ST. CLAIR	TOTAL SHEETS 399	SHEET NO. 64
FED. ROAD DIST. NO. ILLINOIS FED. AID PROJECT		CONTRACT NO. 76C76		