
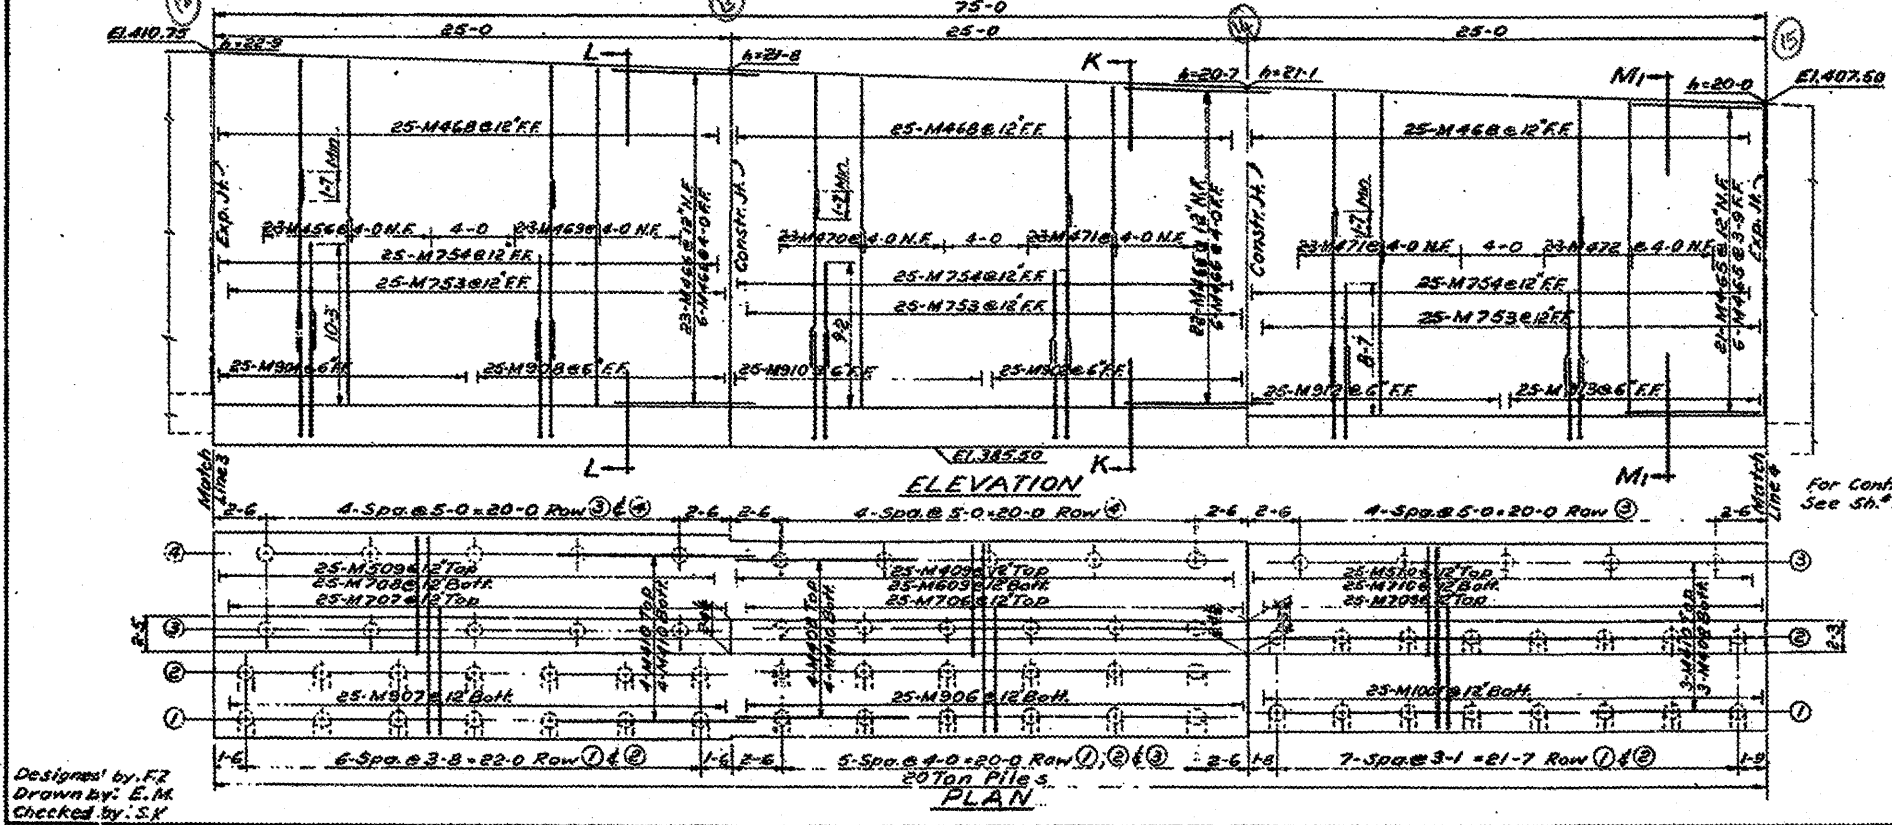
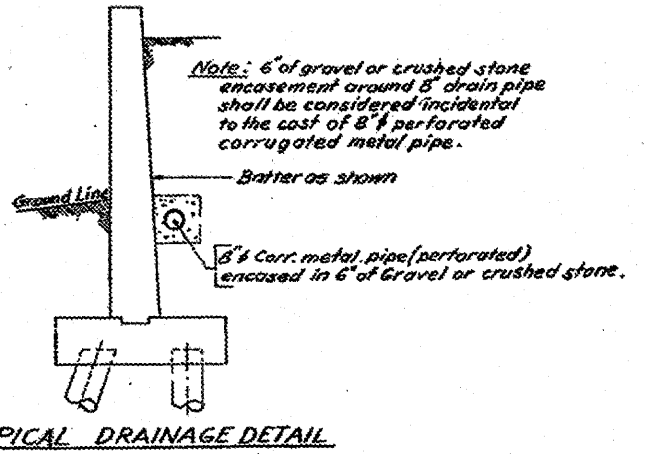
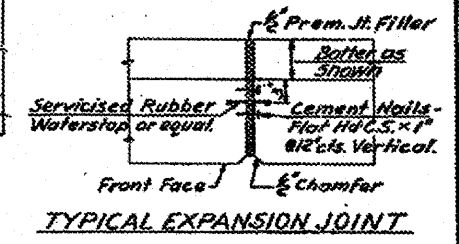
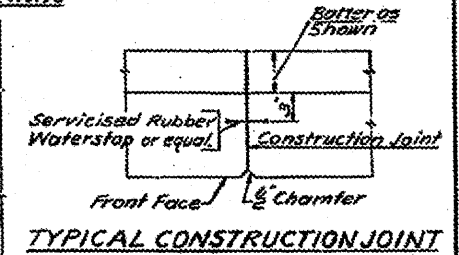


FOR INFORMATION ONLY

PROJECT NO.	82-1-B-2	SHEET NO.	36
SECTION	ST. CLAIR	DATE	4/5
F.A.I. - 7			

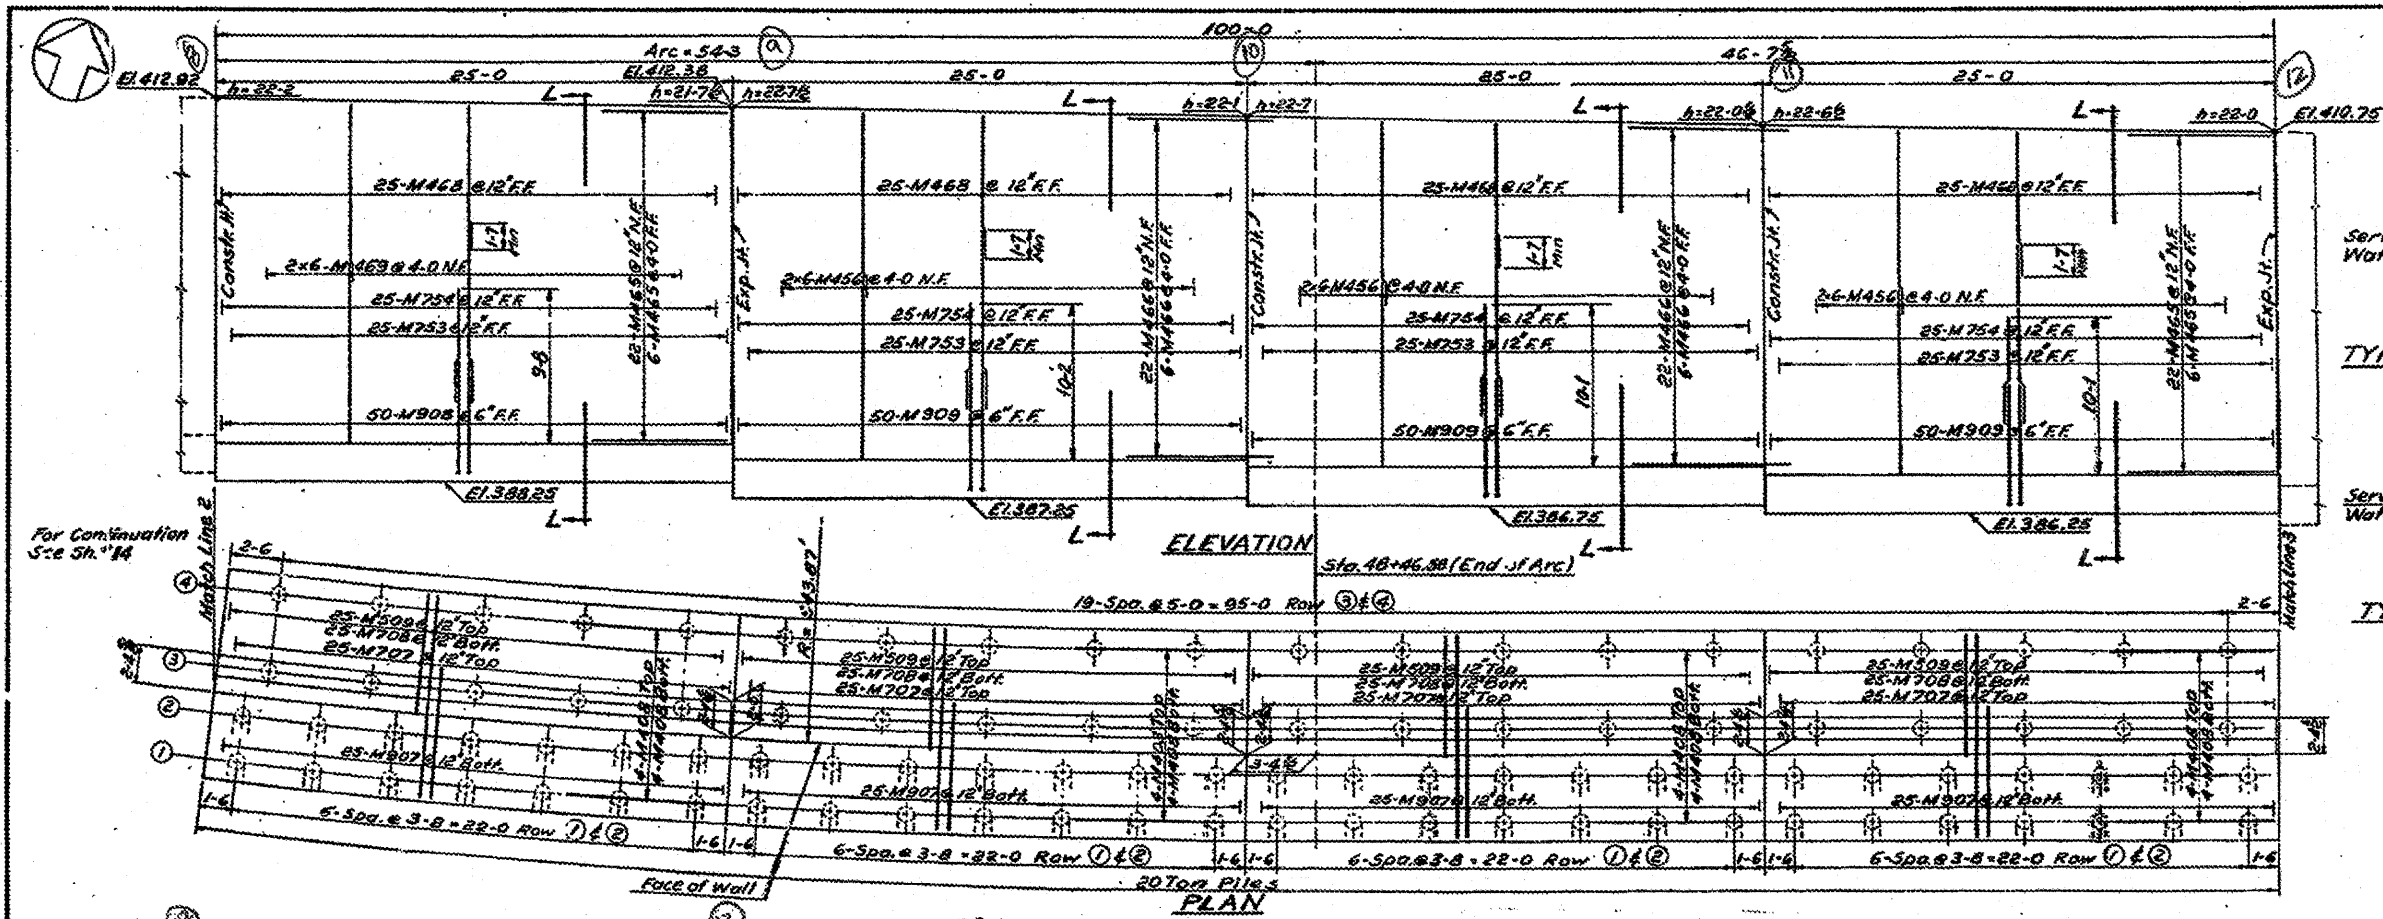

For Continuation See Sh. #16

For Drainage Layout see General Plan

Designed by: FZ
Drawn by: E.M.
Checked by: S.K.

STATE OF ILLINOIS
DEPARTMENT OF PUBLIC WORKS & BLDGS.
DIVISION OF HIGHWAYS
&
CITY OF EAST ST. LOUIS
EAST ST. LOUIS EXPRESSWAY
RETAINING WALL "M"
DETAILS
H.W. LOCHNER, INC.
ENGINEERS
CHICAGO, ILLINOIS
DATE: MAY 1958 SHEET NO. 15.

FILE NAME =	USER NAME = Bhatta	DESIGNED -	REVISED -	STATE OF ILLINOIS DEPARTMENT OF TRANSPORTATION	EXISTING RETAINING WALL PLANS	F.A.I. RTE.	SECTION	COUNTY	TOTAL SHEETS	SHEET NO.	
8FILEL6	PLOT SCALE = 40,000' / in.	DRAWN - GF	REVISED -			TO	82-1-B-2	ST. CLAIR	399	364	
	PLOT DATE = 6/30/2011	CHECKED - AB	REVISED -			CONTRACT NO. 76C76					
		DATE - 07/01/2011	REVISED -			FED. ROAD DIST. NO. ILLINOIS FED. AID PROJECT					
						SCALE: NONE	SHEET 3 OF 7 SHEETS	STA.	TO STA.		