
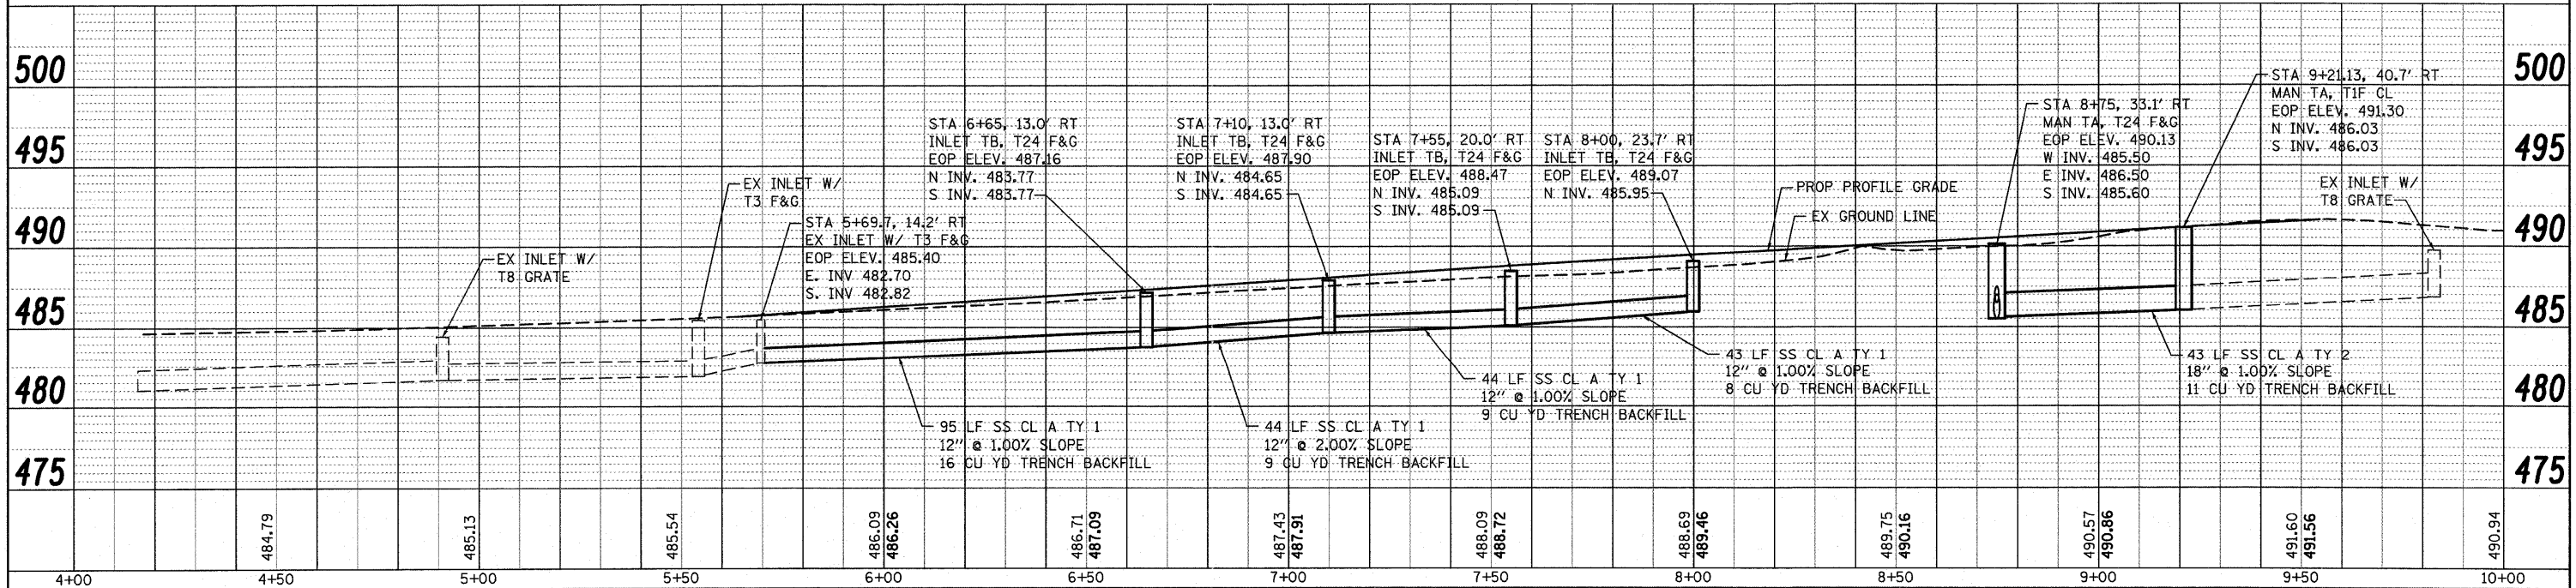


DATE	
BY	
PLANNED	
DESIGNED	
DRAWN	
CHECKED	
DATE	

DATE	
BY	
PLANNED	
DESIGNED	
DRAWN	
CHECKED	
DATE	

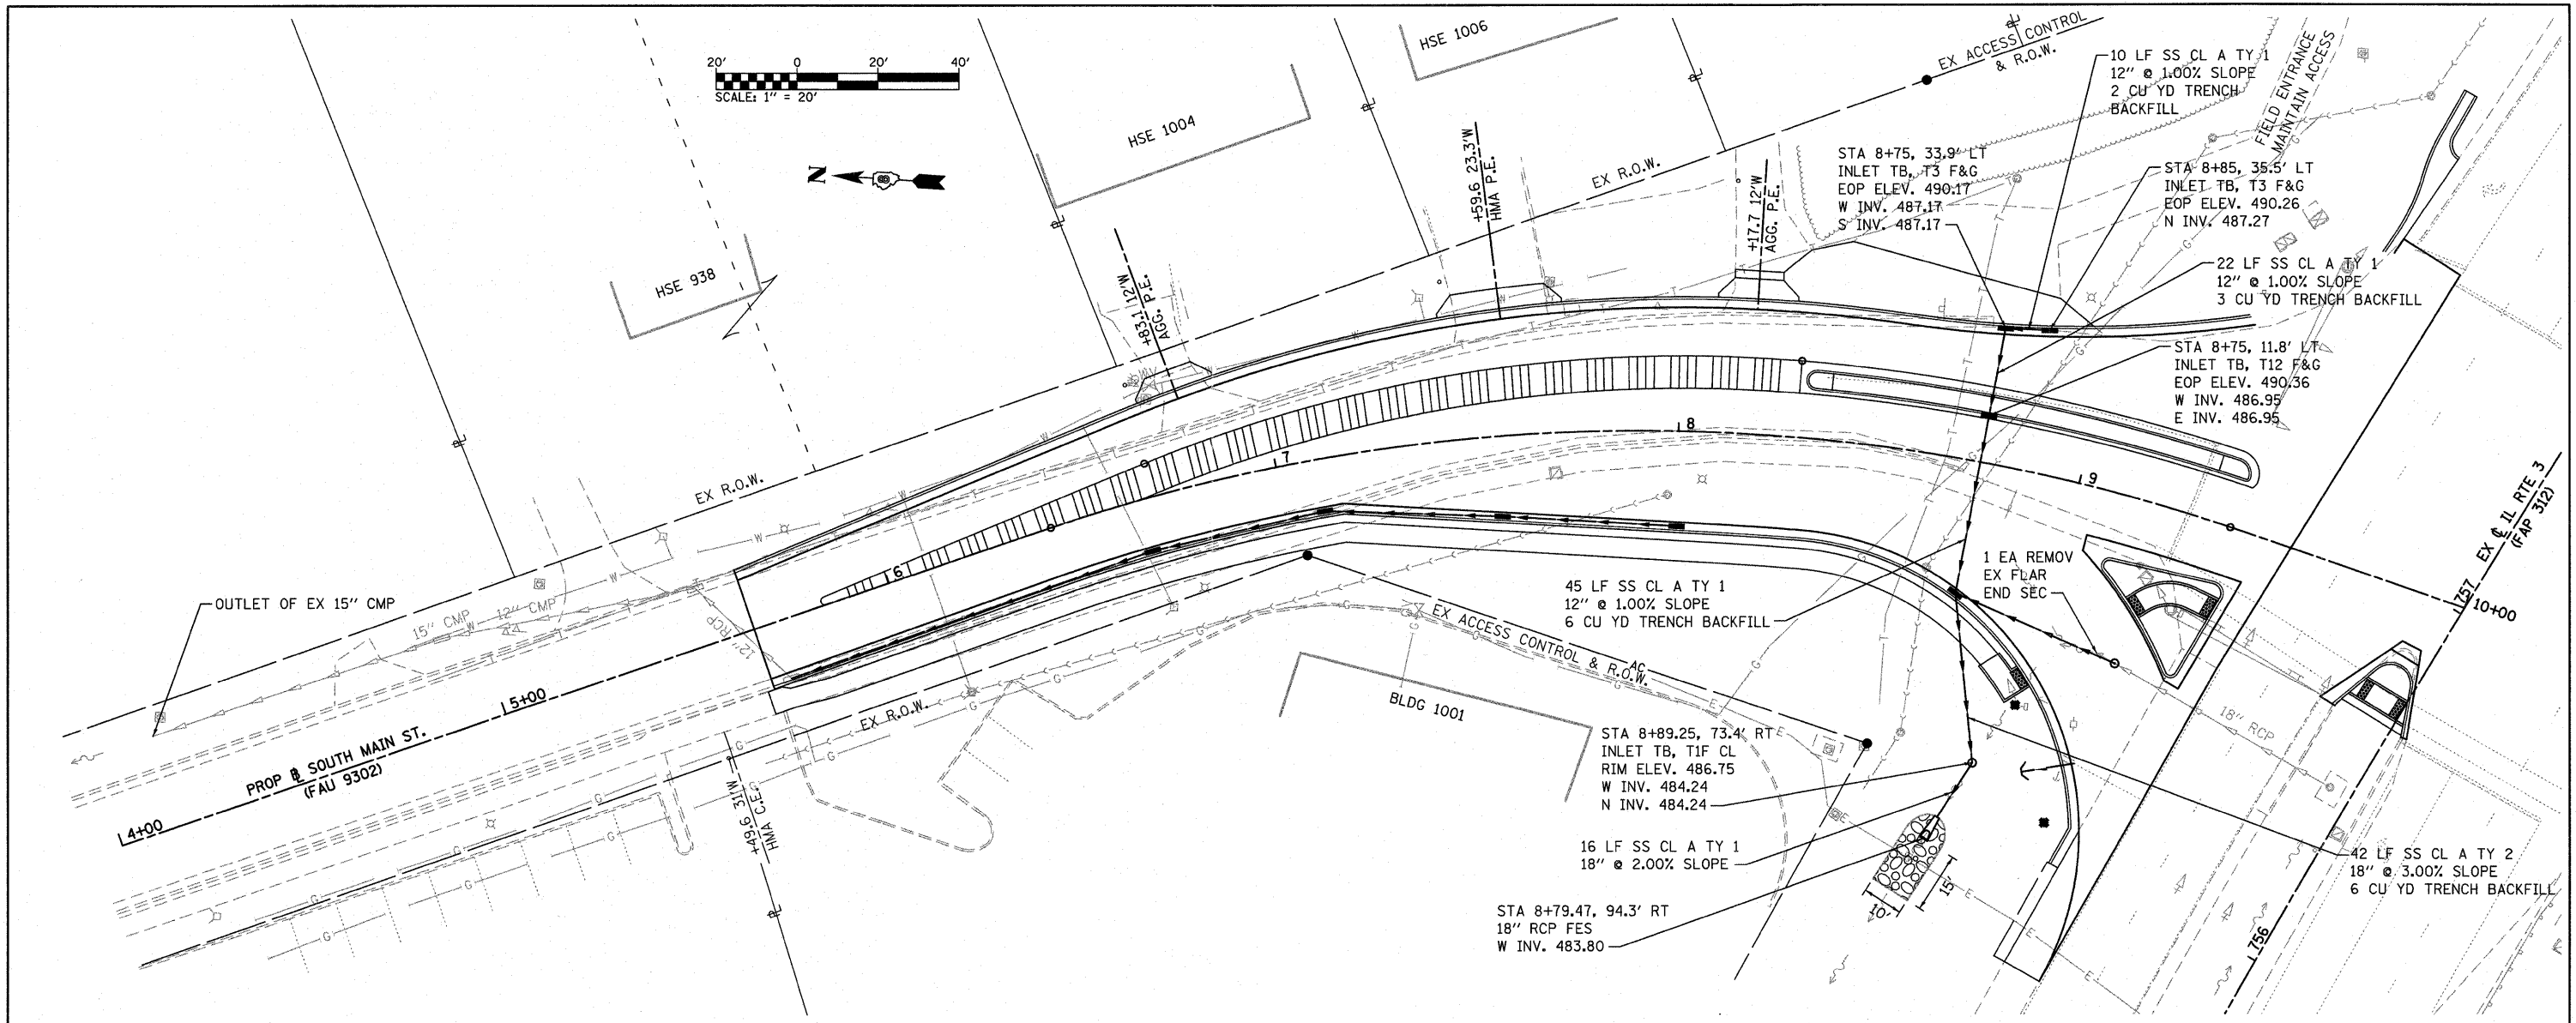

FILE NAME =	USER NAME = randy	DESIGNED - TLC	REVISED -	F.A.U. RTE.	SECTION	COUNTY	TOTAL SHEETS	SHEET NO.
h:\p\28013\murostation\oadd sheets\082280	3-sht-drain.dgn	DRAWN - RGV	REVISED -	9302	08-00047-00-PV	MONROE	25	10
PLOT SCALE = 20.0000 / IN.	CHECKED -	REVISIED -	REVISIED -	S MAIN ST RECONSTRUCTION CONTRACT NO. 97467				
PLOT DATE = 7/28/2011	DATE -	REVISIED -	REVISIED -	ILLINOIS FED. AID PROJECT				

**STATE OF ILLINOIS
DEPARTMENT OF TRANSPORTATION**

DRAINAGE PLAN & PROFILE SHEET
SCALE: 1" = 20' SHEET NO. 1 OF 1 SHEETS STA. 5+00 TO STA. 10+00