


FILE NAME = G:\115\1150223\Work - 3 MO Ave - P12\ACADD Sheets\DB76699-arch-KL.A Plumbing.dwg

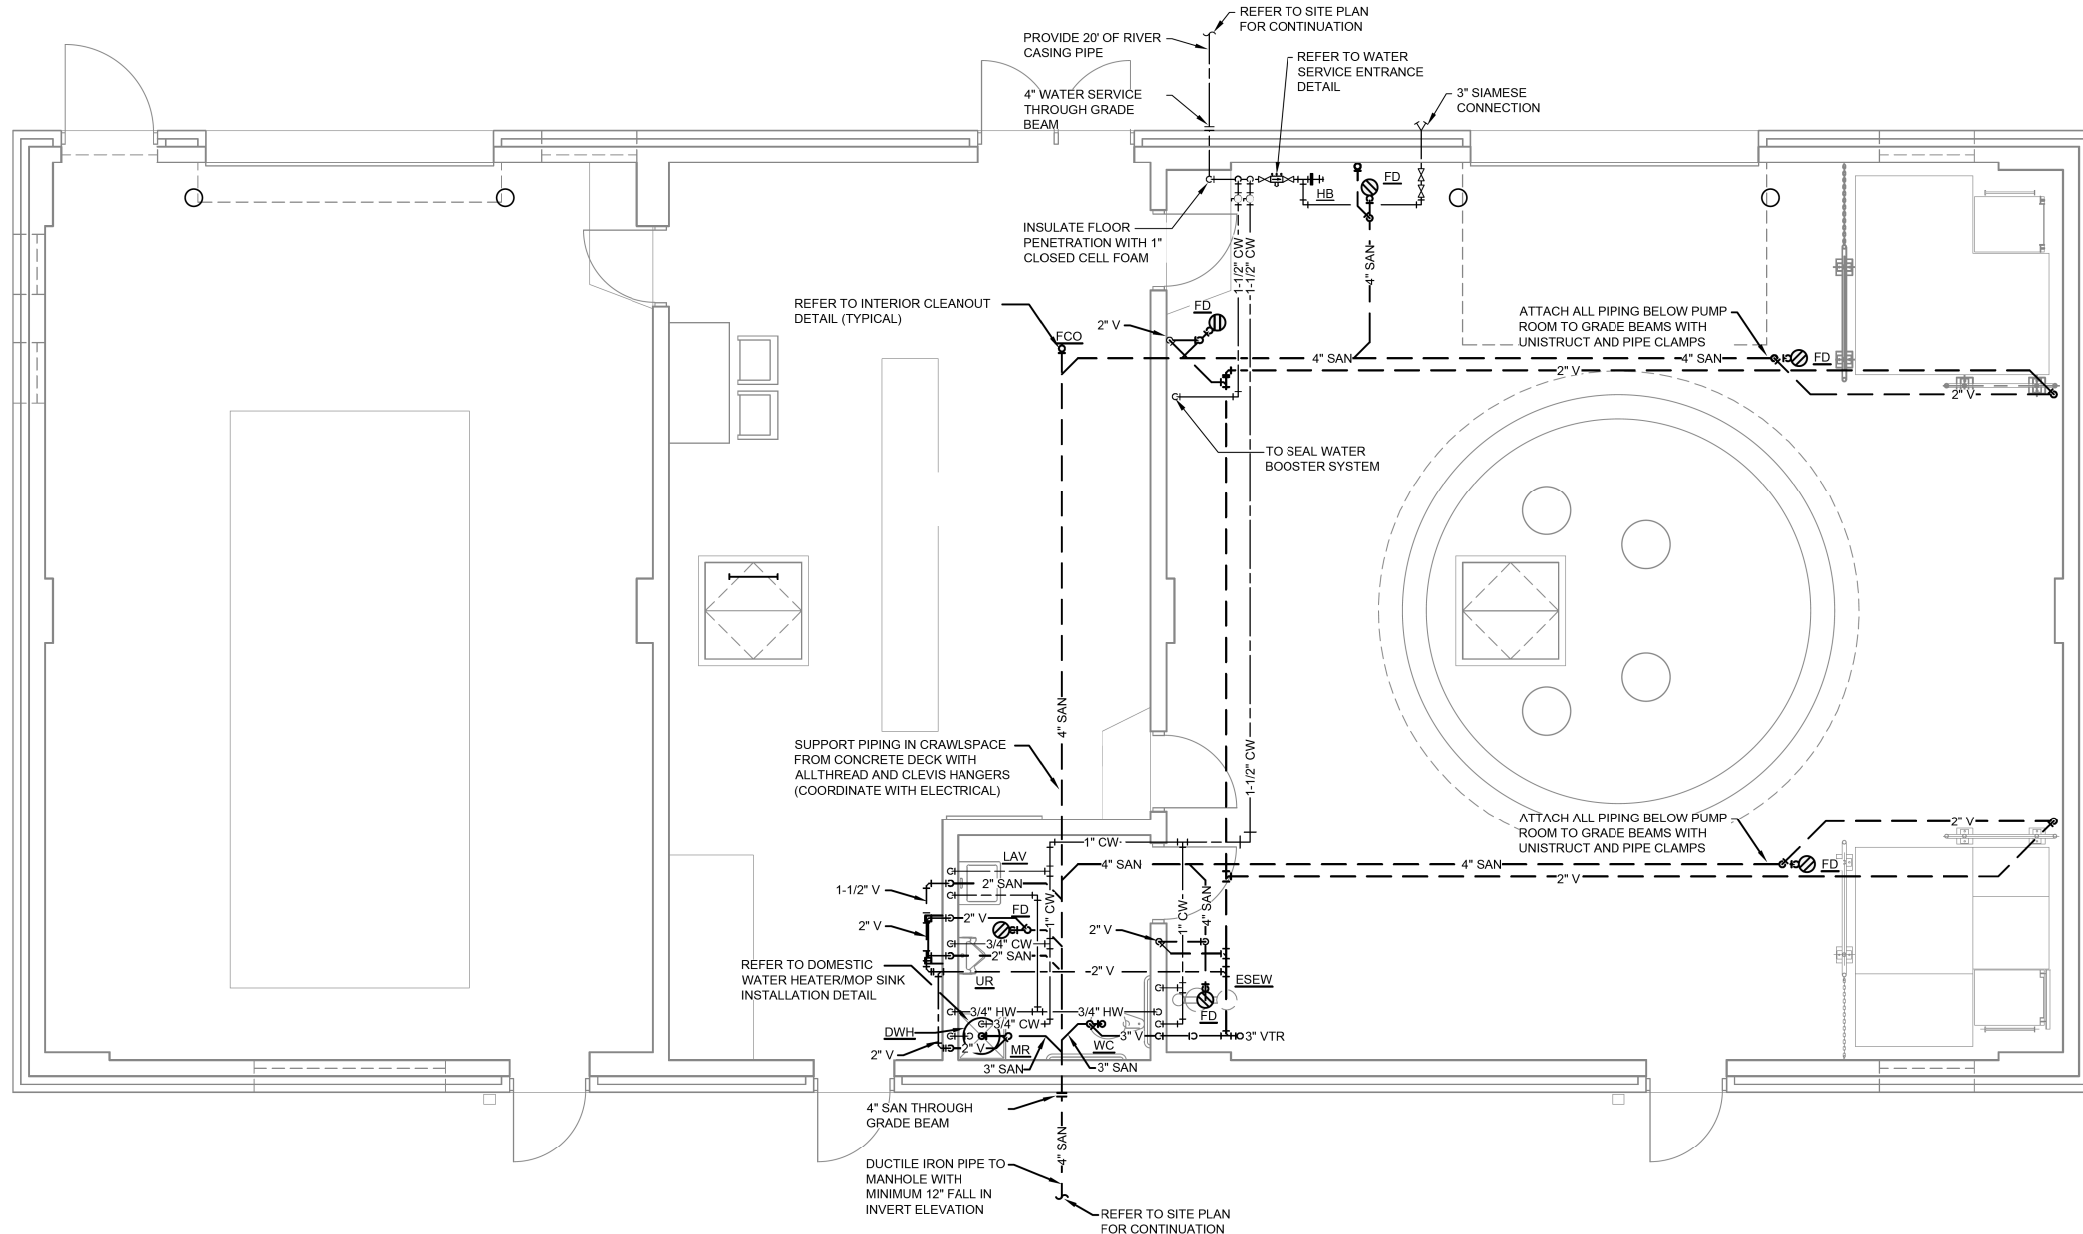

PLUMBING LEGEND	
	2" VENT RISER
	4" VENT THROUGH ROOF
	DOMESTIC COLD WATER (CW)
	DOMESTIC 115° HOT WATER (HW)
	DOMESTIC 140° HOT WATER (HW)
	SEAL WATER SUPPLY (SW)
	SEWER OR WASTE (SAN)
	VENT LINE (V)
	RISE IN PIPE
	DROP IN PIPE
	CAP ON END OF PIPE
	POINT OF CONNECTION
	CLEAN OUT (WALL OR SIDE OF PIPE)
	FLOOR CLEAN OUT (C.O., RISER)
	EXTERIOR CLEAN OUT
	BALL VALVE
	FLOOR DRAIN

WELL HOUSE BUILDING- DOMESTIC PLUMBING PLAN

SCALE: 1/4" = 1'-0"

GENERAL NOTES

1. ALL CORE DRILLED HOLES THROUGH GRADE BEAMS SHALL BE COORDINATED WITH THE STRUCTURAL ENGINEER. PROVIDE PROPOSED HOLE LOCATIONS TO ENGINEER FOR REVIEW PRIOR TO DRILLING HOLES.

