



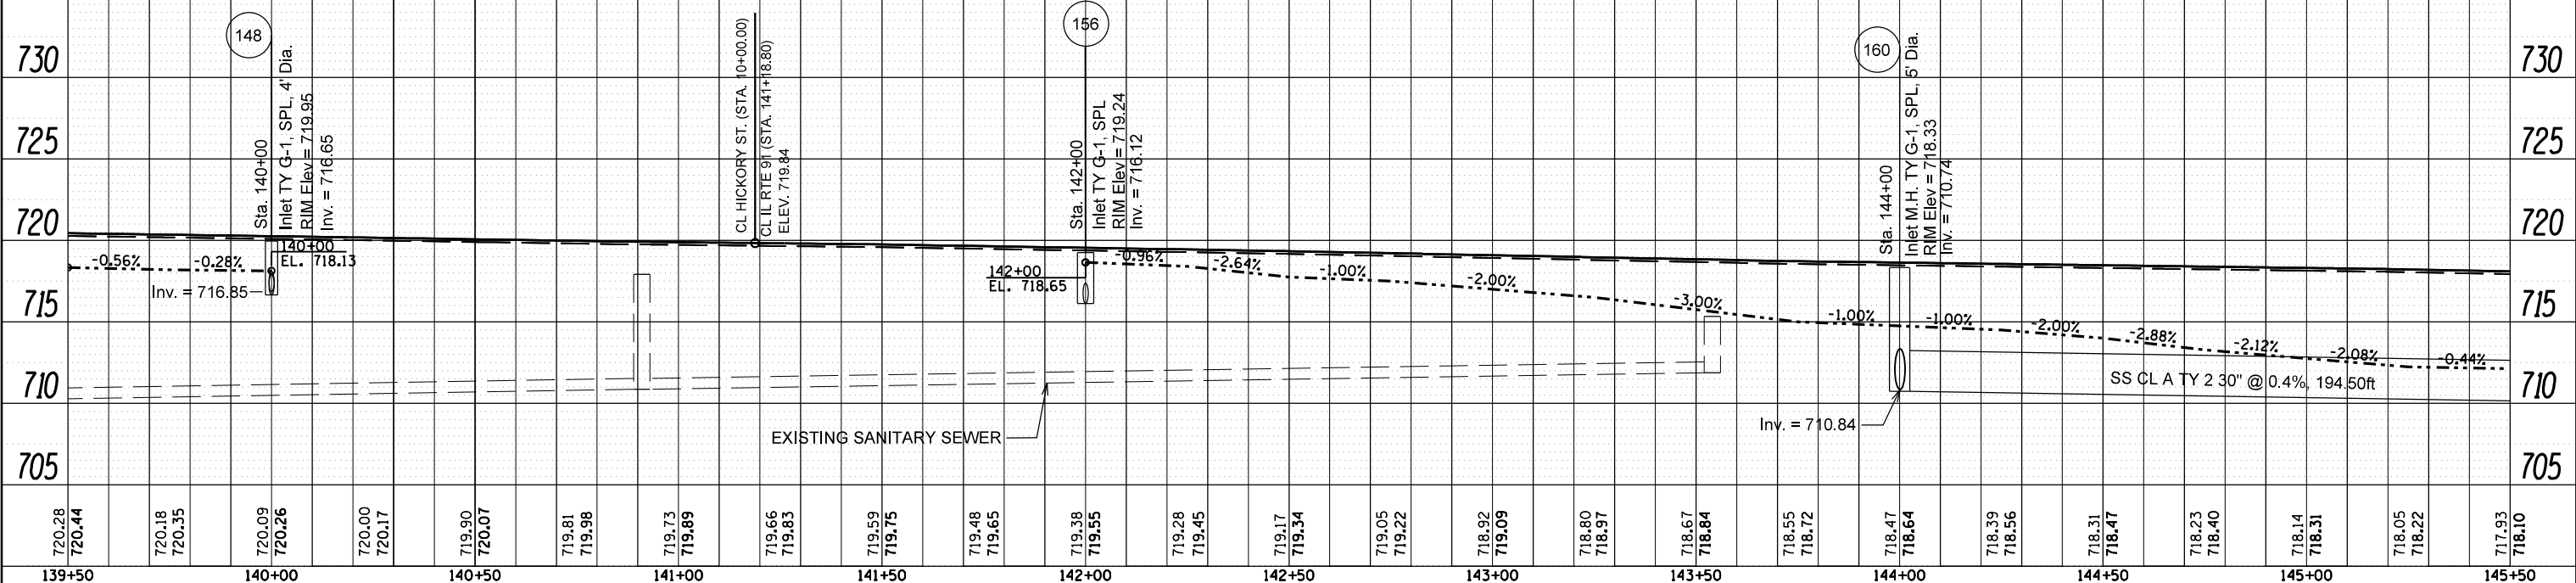

PLAN	SURVEYED	DATE
	PLOTTED	BY
	GRADES CHECKED	
	ALIGNED	
	NOTATIS CHKD	
	NO.	

PROFILE	SURVEYED	DATE
	PLOTTED	BY
	GRADES CHECKED	
	ALIGNED	
	NOTATIS CHKD	
	NO.	

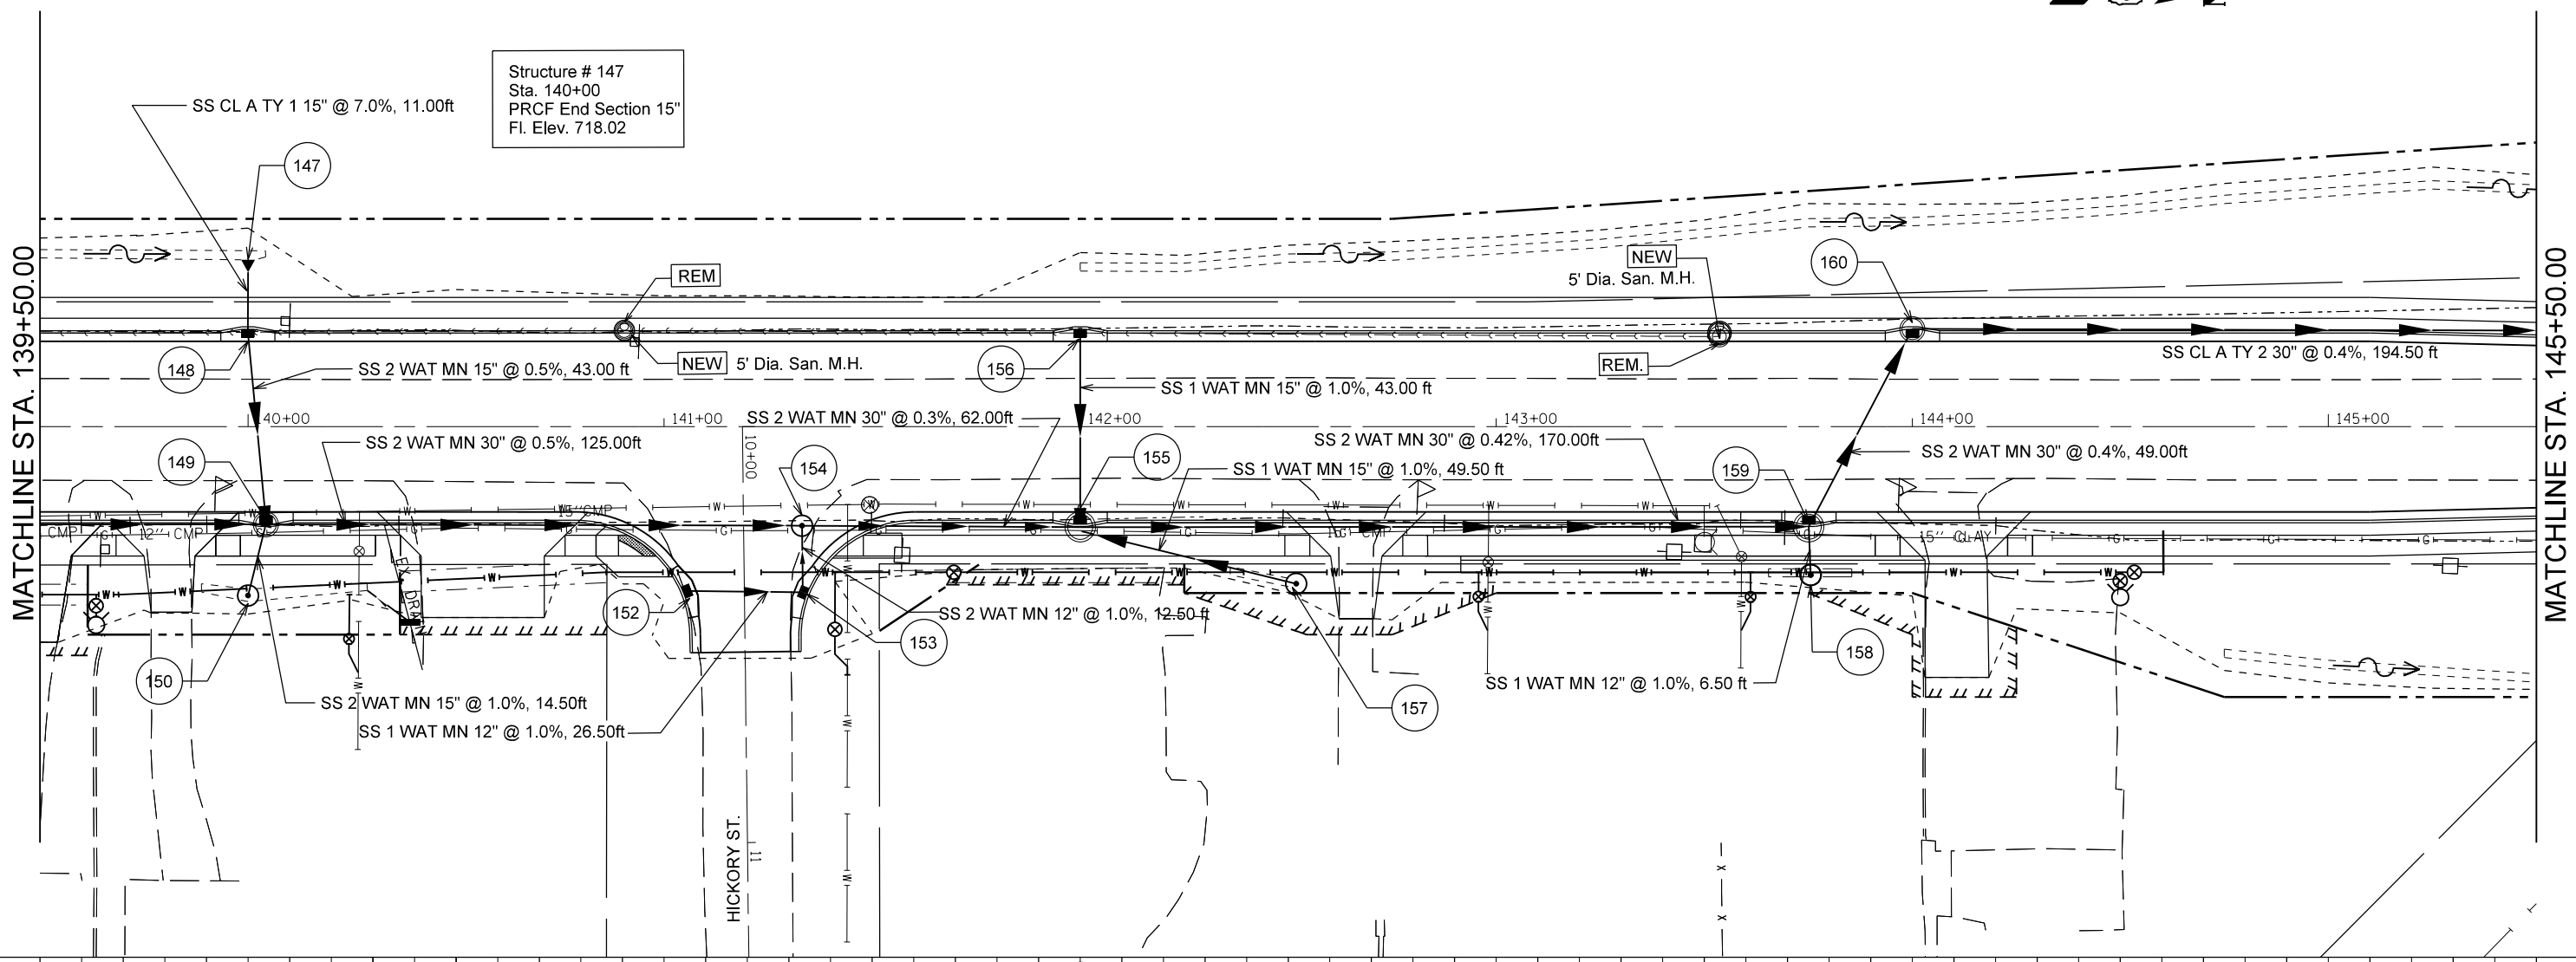

FILE NAME =	USER NAME = crespole	DESIGNED -	REVISED -	<b>STATE OF ILLINOIS DEPARTMENT OF TRANSPORTATION</b>	<b>IL RTE 91 DRAINAGE PLANS LT SIDE</b>			F.A.S. RT. =	SECTION	COUNTY	TOTAL SHEETS	SHEET NO.
c:\pwork\pwork\crespole\d0330150\04887	p2-SHT-DRAIN-LT-rev.DGN	DRAWN -	REVISED -		1380	7W-1,RS-3	Peoria	617	234			
Default	PLOT SCALE = 40.0000' / in.	CHECKED -	REVISED -		CONTRACT NO. 88792							
	PLOT DATE = 8/16/2013	DATE -	REVISED -		ILLINOIS FED. AID PROJECT							