

PLAN	SURVEYED	DATE
	PLOTTED	BY
	GRADES CHECKED	
	ALIGNED	
	STRUCTURE	
	NOTATIS	
	CHP	
	NO.	

PROFILE	SURVEYED	DATE
	PLOTTED	BY
	GRADES CHECKED	
	ALIGNED	
	STRUCTURE	
	NOTATIS	
	CHP	
	NO.	

MATCHLINE STA. 145+50.00





Structure # 164
Sta. 146+00
PRCF End Sec 30"
Fl. Elev. 710.12

Structure # 166
Sta. 148+75.00
PRCF End Sec 42"
Fl. Elev. 705.65

Structure # 161
Sta. 146+87
Class SI Outlet
Inv. = 715.01

Structure # 162
Sta. 146+00
PRCF End Sec 30"
Fl. Elev. 710.40

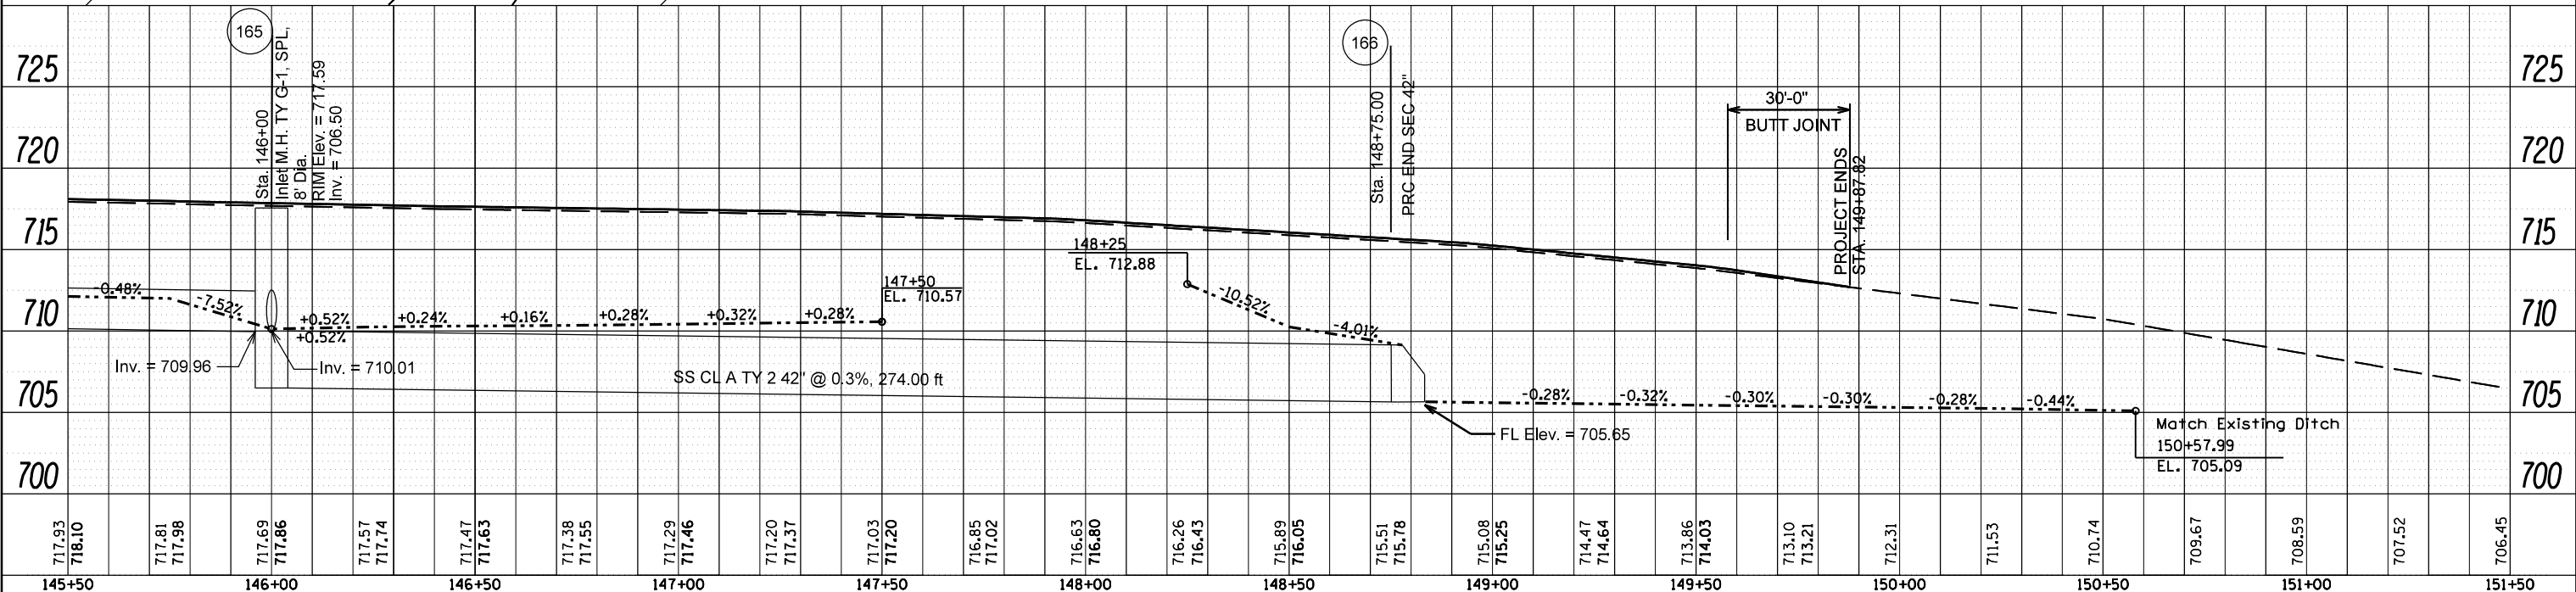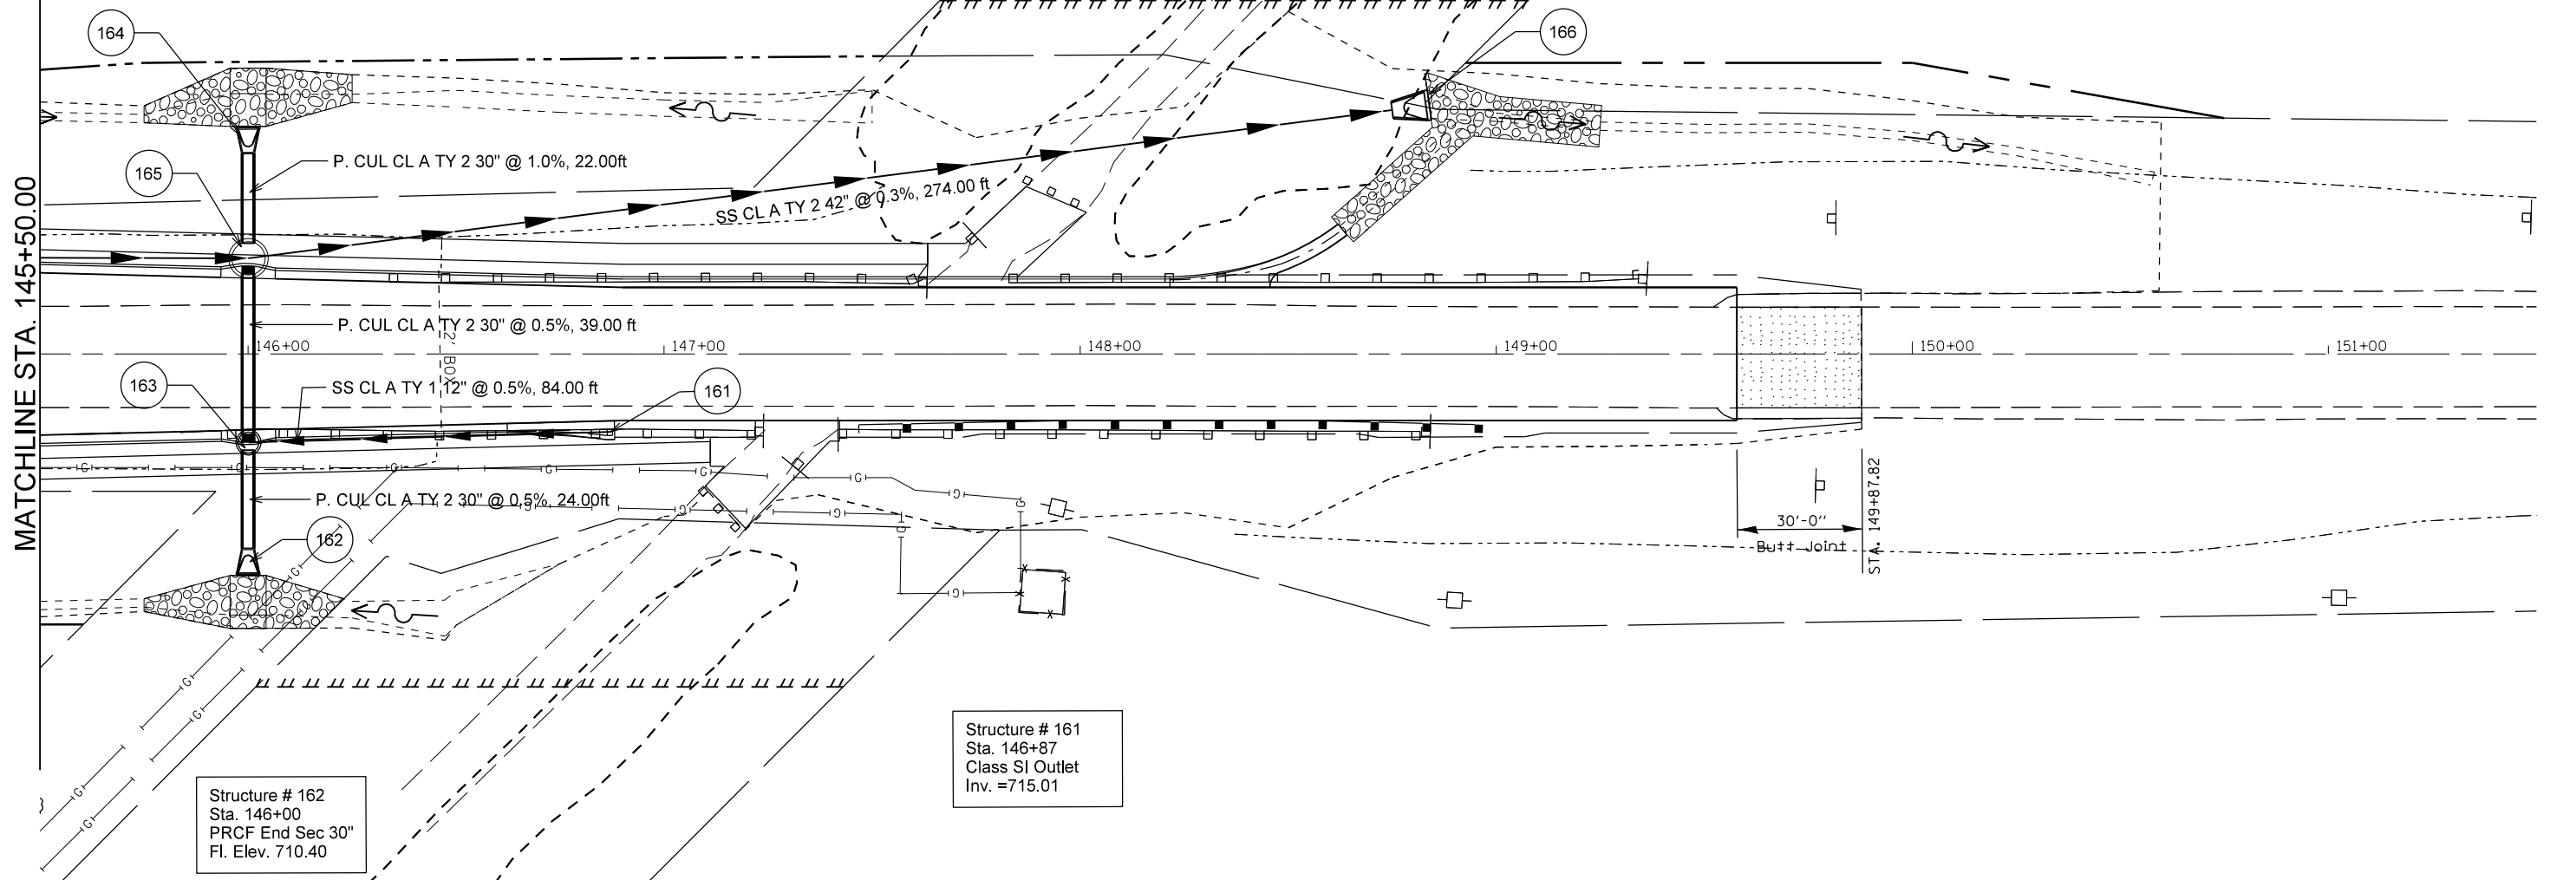

FILE NAME =	USER NAME = crespole	DESIGNED -	REVISED -	STATE OF ILLINOIS DEPARTMENT OF TRANSPORTATION	IL RTE 91 DRAINAGE PLANS LT SIDE	F.A.S. R.E.	SECTION	COUNTY	TOTAL SHEETS	SHEET NO.	
c:\pwork\pwork\crespole\0330150\04887	P2-SHT-DRAIN-LT-rev.DGN	DRAWN -	REVISED -			1380	7W-1,RS-3	Peoria	617	235	
Default	PLOT SCALE = 40.0000' / in.	CHECKED -	REVISED -			CONTRACT NO. 88792					
	PLOT DATE = 8/16/2013	DATE -	REVISED -			ILLINOIS FED. AID PROJECT					