
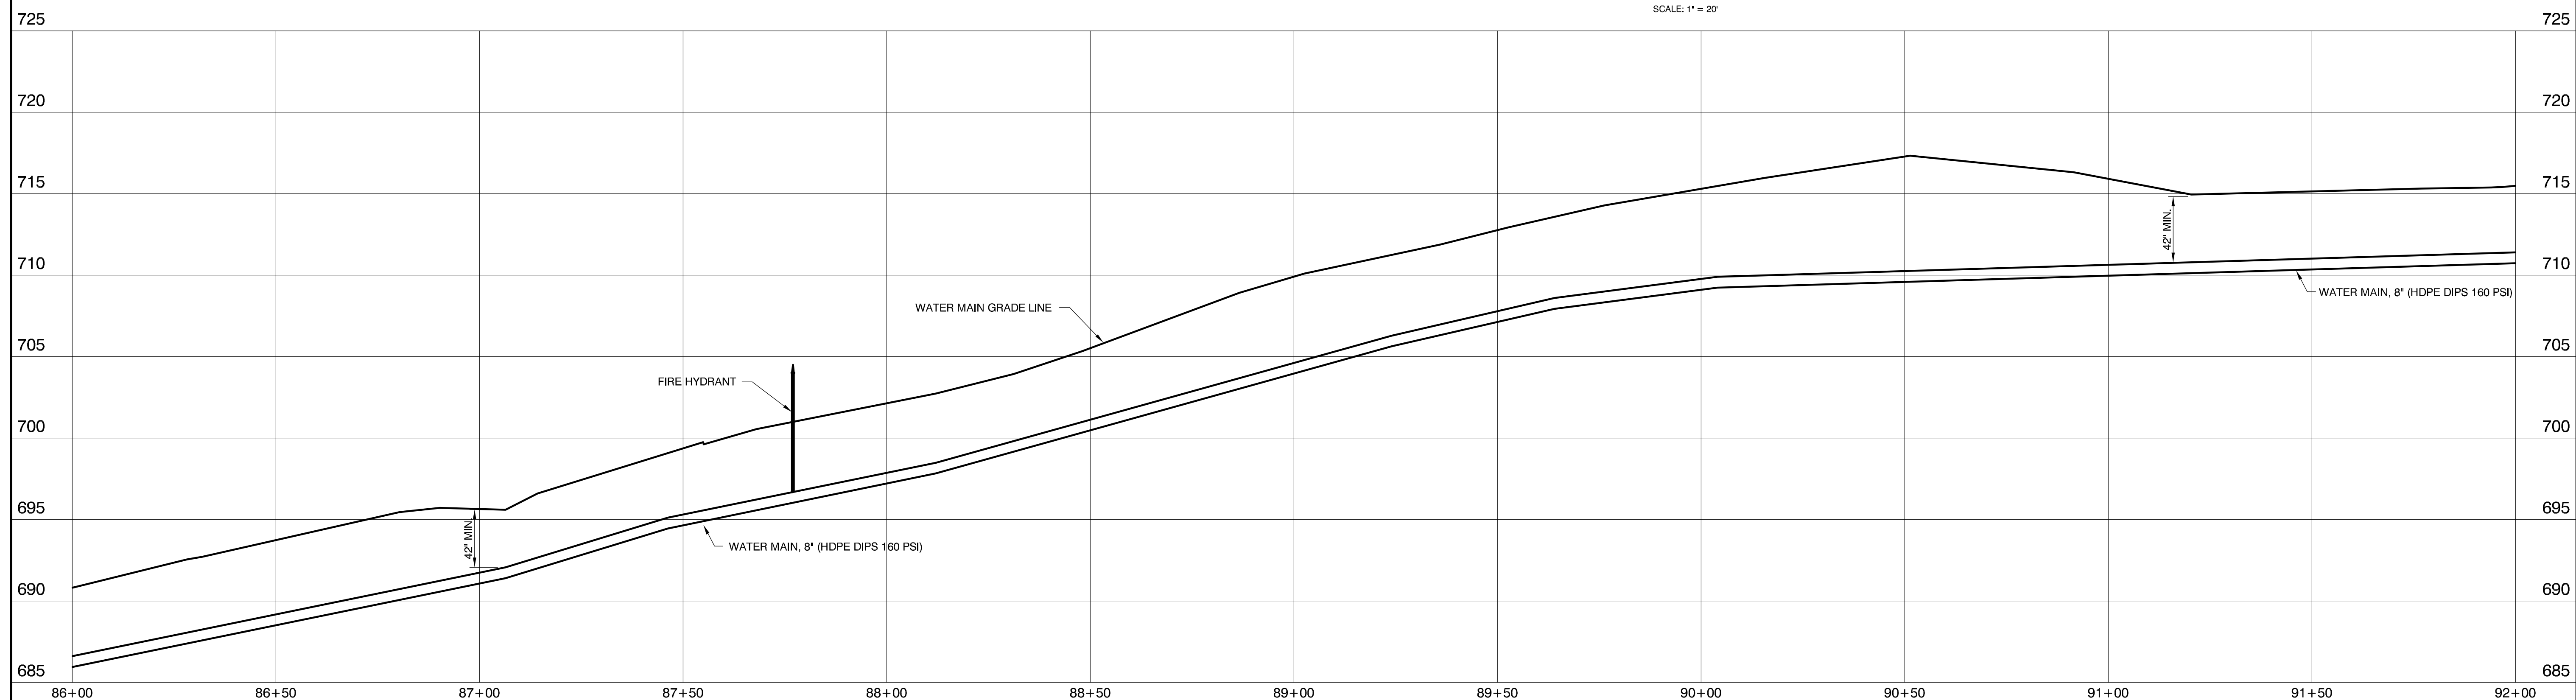


ALL EXISTING UTILITIES LOCATIONS AND DEPTHS TO BE VERIFIED PRIOR TO ALL DRILLING AND BORES.

WATER MAIN TEE 8"x6"	FIRE HYDRANT AND VALVE (SPECIAL)	WATER MAIN, 8"
LOCATION LT. STA. 87+77	LOCATION 47' LT. STA. 87+77	LOCATION LT. STA. 86+00 TO STA. 92+00
1 EA.	1 EA.	600 FT.
SHEET TOTAL 1 EA.	SHEET TOTAL 1 EA.	SHEET TOTAL 600 FT.

PLAN VIEW

SCALE: 1" = 20' HOR

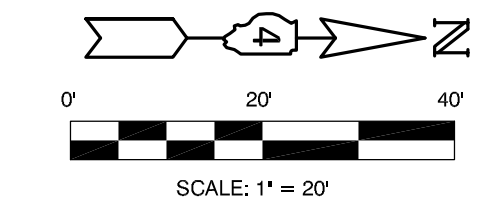

PROFILE VIEW

SCALES: 1" = 20' HOR
1" = 5' VER

M MOHR & KERR ENGINEERING & LAND SURVEYING, P.C.
7336 N. University Ave. Office: (309) 692-8500
Peoria, Illinois 61614 Fax: (309) 692-8501
www.mohrandkerr.com Professional Design Firm #184.005091

DESIGNED	WFS	REVISED
DRAWN	DEH	REVISED
CHECKED	WFS	REVISED
DATE	08-30-13	REVISED

STATE OF ILLINOIS
DEPARTMENT OF TRANSPORTATION

IL RTE 91
WATER MAIN PLANS
PLAN AND PROFILE SHEET
SCALE: 1" = 20' SHEET NO. 5 OF 17 SHEETS STA. 86+00 TO STA. 92+00

F.A. ROUTE 1380	SECTION 7W-1, RS-3	COUNTY PEORIA	TOTAL SHEETS 617	SHEET NO. 259
CONTRACT NO. 88792				
ILLINOIS FEDERAL ROAD DIST NO.				

12-108