


PLAN VIEW

SCALE: 1" = 20' HOR

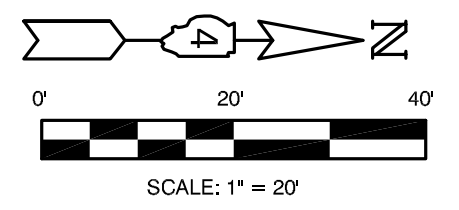

ALL EXISTING UTILITIES LOCATIONS AND DEPTHS TO BE VERIFIED PRIOR TO ALL DRILLING AND BORES.

WATER MAIN TEE 8"x6"

LOCATION	
RT. STA. 116+32	1 EA.
RT. STA. 117+00	1 EA.
LT. STA. 120+41	1 EA.
SHEET TOTAL	3 EA.

DUCTILE IRON WATER MAIN FITTINGS 8" x 8" CROSS

LOCATION	
RT. STA. 120+41	1 EA.
SHEET TOTAL	1 EA.

CONNECTION TO EXISTING WATER MAIN, 4"

LOCATION	
WILEY RD. 4"	1 EA.
SHEET TOTALS	1 EA.

CONNECTION TO EXISTING WATER MAIN, 8"

LOCATION	
E. ASH ST. 8"	1 EA.
W. ASH ST. 8"	1 EA.
SHEET TOTALS	2 EA.

FIRE HYDRANTS TO BE REMOVED

LOCATION	
LT. STA. 120+59	1 EA.
SHEET TOTAL	1 EA.

REMOVE EXISTING WATER VALVE

LOCATION	
RT. STA. 117+03	1 EA.
LT. STA. 120+47	1 EA.
RT. STA. 120+47	1 EA.
RT. STA. 120+71	1 EA.
SHEET TOTAL	4 EA.

WATER SERVICE CONNECTION

LOCATION	
LT. STA. 116+75	1 EA.
LT. STA. 117+25	1 EA.
LT. STA. 117+87	1 EA.
RT. STA. 118+60	1 EA.
LT. STA. 118+84	1 EA.
RT. STA. 119+40	1 EA.
LT. STA. 119+80	1 EA.
LT. STA. 121+27	1 EA.
LT. STA. 121+73	1 EA.
RT. STA. 121+91	1 EA.
SHEET TOTALS	10 EA.

FIRE HYDRANT AND VALVE (SPECIAL)

LOCATION	
34' RT. STA. 116+32	1 EA.
48' LT. STA. 120+67	1 EA.
SHEET TOTALS	2 EA.

WATER VALVES, 6"

LOCATION	
RT. STA. 117+00	1 EA.
SHEET TOTAL	1 EA.

WATER VALVES, 8"

LOCATION	
RT. STA. 117+18	1 EA.
RT. STA. 120+41	1 EA.
RT. STA. 120+41	1 EA.
RT. STA. 120+52	1 EA.
SHEET TOTALS	4 EA.

STEEL CASINGS 12"


LOCATION	
58' LT. STA. 120+54 (6" F.H. LEAD) (18" SS)	22 FT.
SHEET TOTAL	22 FT.

DUCTILE IRON WATER MAIN, 6"

LOCATION	
RT. STA. 117+00	12 FT.
SHEET TOTAL	12 FT.

WATER MAIN, 8"

LOCATION	
RT. STA. 116+00 TO STA. 120+00	600 FT.
LT. STA. 120+42 (HDPE)	115 FT.
RT. STA. 120+42	25 FT.
SHEET TOTAL	740 FT.

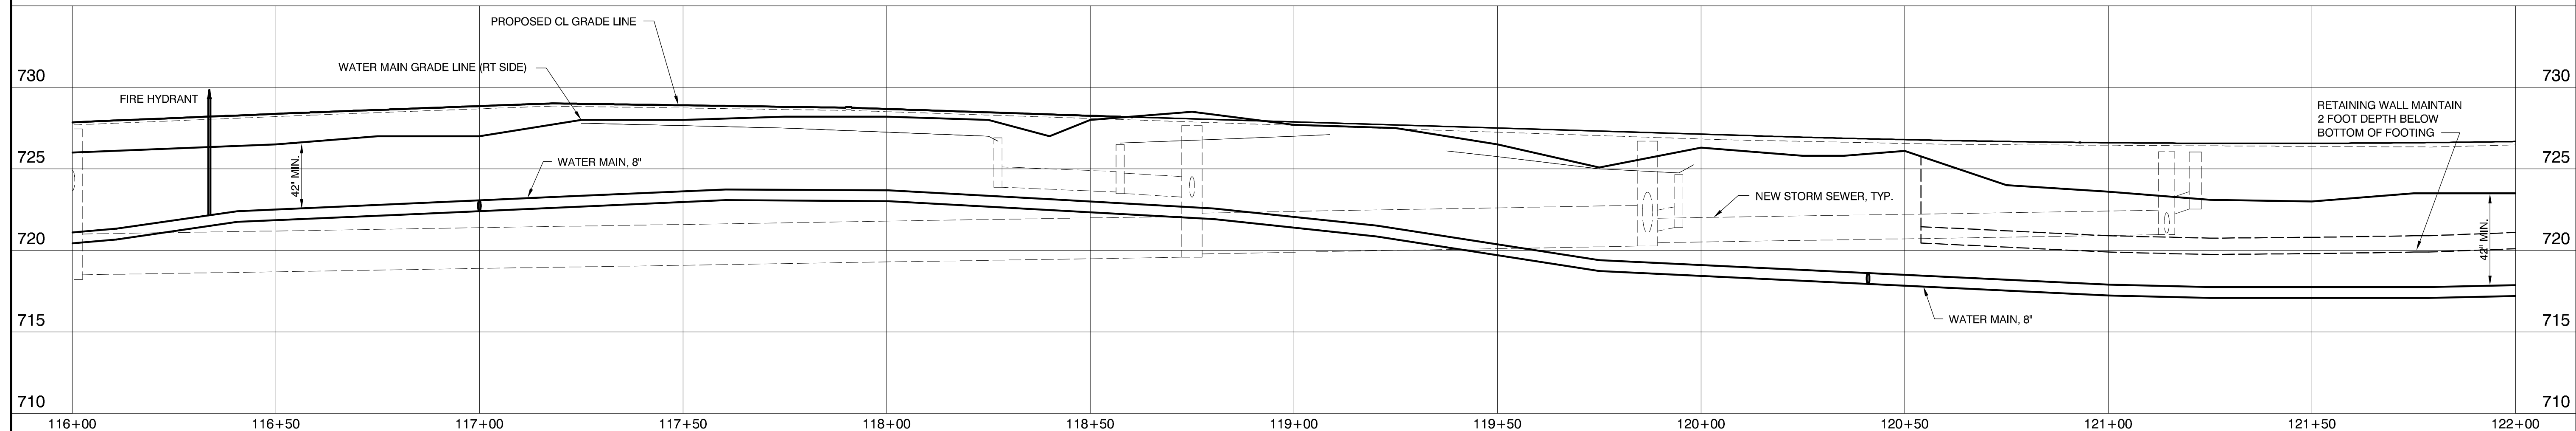

PROFILE VIEW

SCALE: 1" = 20' HOR
1" = 5' VER

M MOHR & KERR ENGINEERING & LAND SURVEYING, P.C.
7336 N. University Ave. Office: (309) 692-8500
Peoria, Illinois 61614 Fax: (309) 692-9501
www.mohrandkerr.com Professional Design Firm #184.005091

DESIGNED	WFS	REVISED
DRAWN	DEH	REVISED
CHECKED	WFS	REVISED
DATE	08-30-13	REVISED

STATE OF ILLINOIS
DEPARTMENT OF TRANSPORTATION

IL RTE 91
WATER MAIN PLANS
PLAN AND PROFILE SHEET
SCALE: 1" = 20' SHEET NO. 10 OF 17 SHEETS STA. 116+00 TO STA. 122+00

F.A. ROUTE	SECTION	COUNTY	TOTAL SHEETS	SHEET NO.
1380	7W-1, RS-3	PEORIA	617	264
CONTRACT NO. 88792				
ILLINOIS FEDERAL ROAD DIST NO.				