



PLAN VIEW

SCALES: 1" = 20' HOR

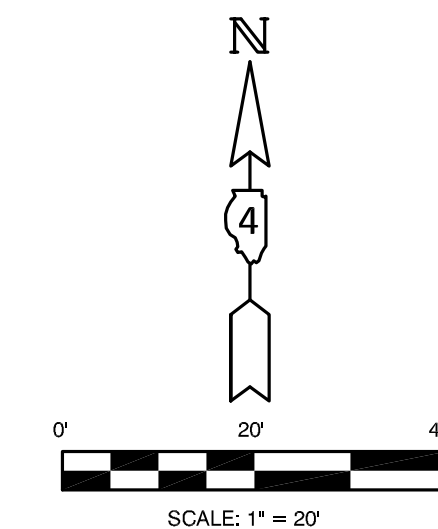

WATER SERVICE CONNECTION

LOCATION		
LT. STA. 18+17 (2) (1 1/2" SERVICE SUPPLY)		2 EA.
SHEET TOTALS		2 EA.

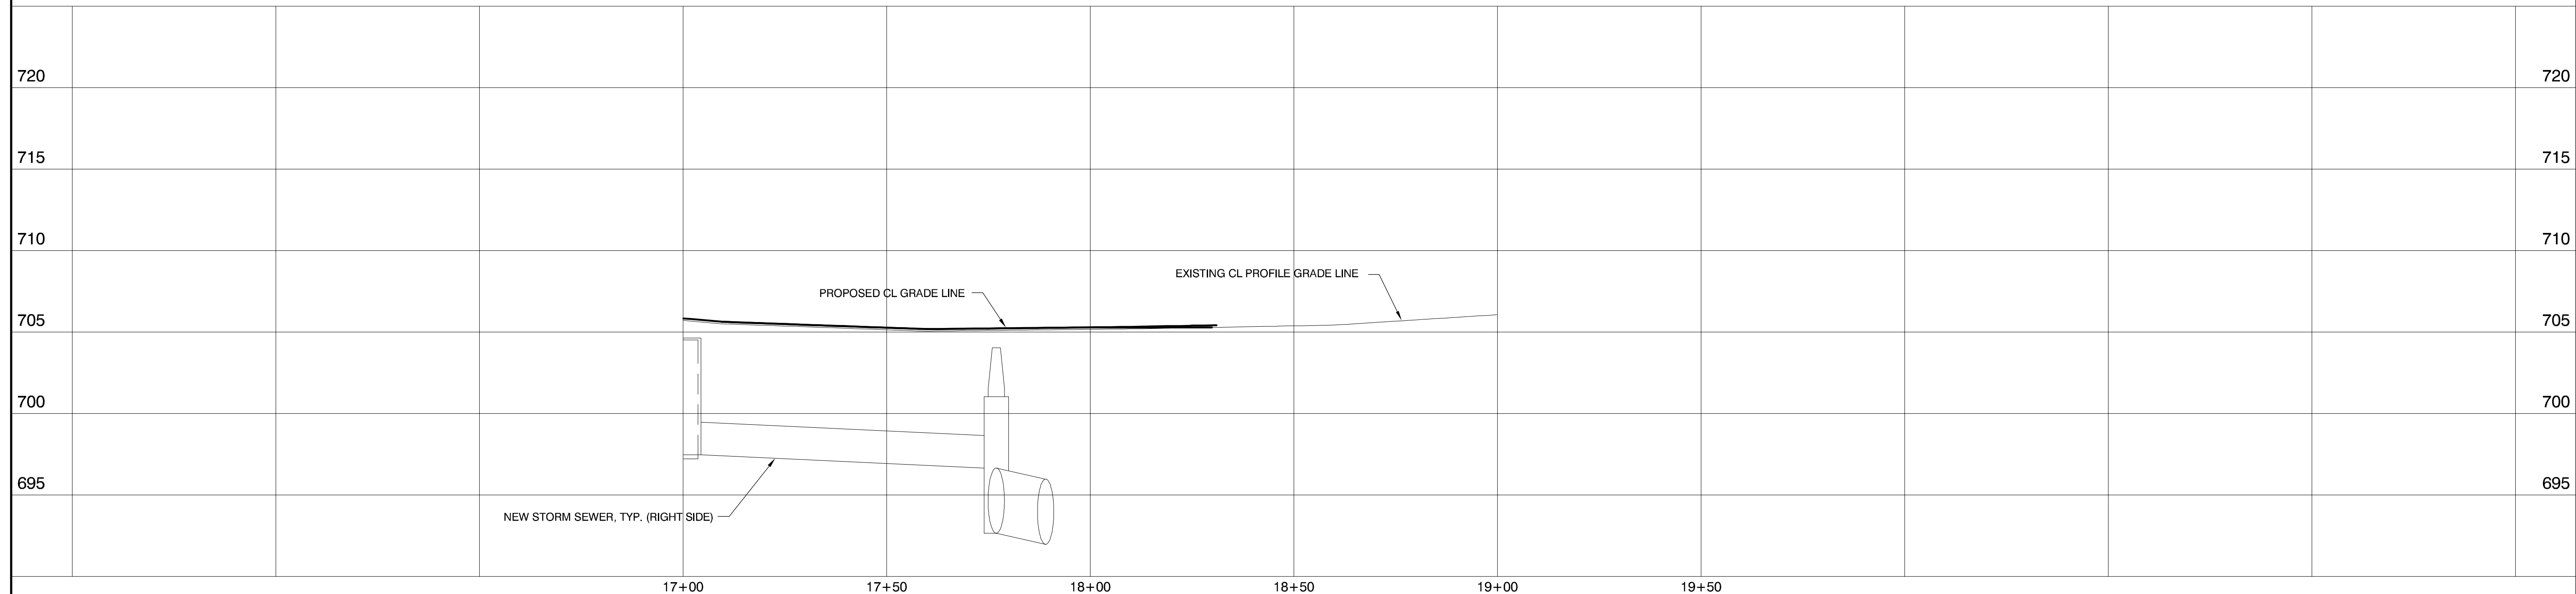

PROFILE VIEW

SCALES: 1" = 20' HOR
1" = 5' VER

M MOHR & KERR ENGINEERING & LAND SURVEYING, P.C.
7336 N. University Ave. Office: (309) 692-8500
Peoria, Illinois 61614 Fax: (309) 692-8501
www.mohrandkerr.com Professional Design Firm #184.005091

DESIGNED	WFS	REVISED
DRAWN	DEH	REVISED
CHECKED	WFS	REVISED
DATE	08-30-13	REVISED

STATE OF ILLINOIS
DEPARTMENT OF TRANSPORTATION

LEGION HALL ROAD
WATER MAIN PLANS
PLAN AND PROFILE SHEET

SCALE: 1" = 20' SHEET NO. 16 OF 17 SHEETS STA. 17+00 TO STA. 19+00

F.A. ROUTE	SECTION	COUNTY	TOTAL SHEETS	SHEET NO.
1380	7W-1, RS-3	PEORIA	617	270
CONTRACT NO. 88792				
ILLINOIS FEDERAL ROAD DIST NO.				