




F.A. RTE.	SECTION	COUNTY	TOTAL SHEETS	SHEET NO.
1362	06-00047-00-LS	COOK	59	37
STA.		TO STA.		
FED. ROAD DIST. NO. ILLINOIS FED. AID PROJECT				

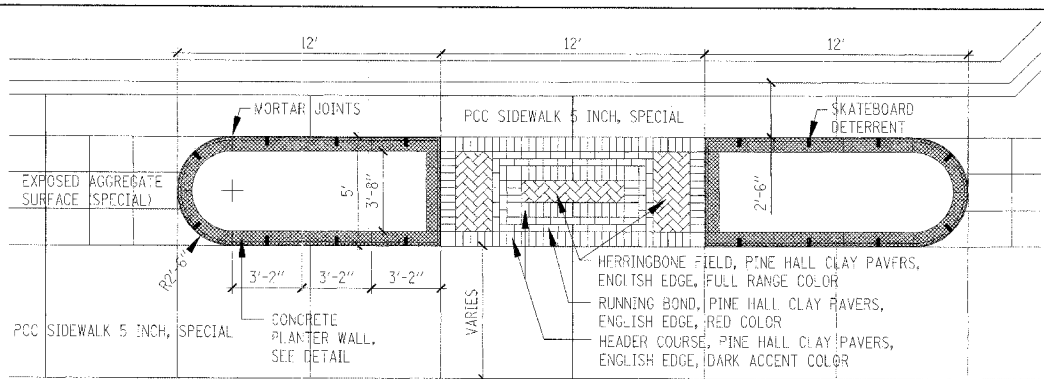


NOTES:
 DIMENSIONS FOR CONCRETE PLANTER WALL SECTIONS AS SHOWN DO NOT ACCOUNT FOR MORTAR JOINT WIDTHS. ADJUST DIMENSIONS TO ACHIEVE OVERALL PLANTER SIZING.
 SUBMIT SHOP DRAWINGS FOR ALL PLANTER WALL SECTIONS FOR APPROVAL PRIOR TO FABRICATION.

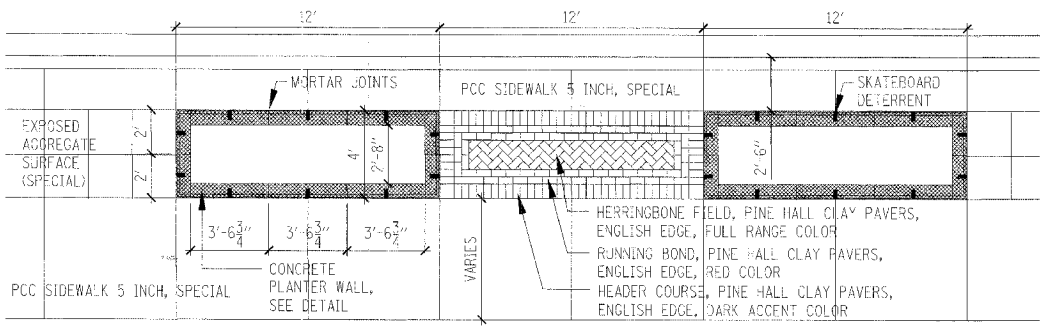


CONCRETE PLANTER WALLS / BRICK PAVERS PLAN
 1/4" = 1'-0"

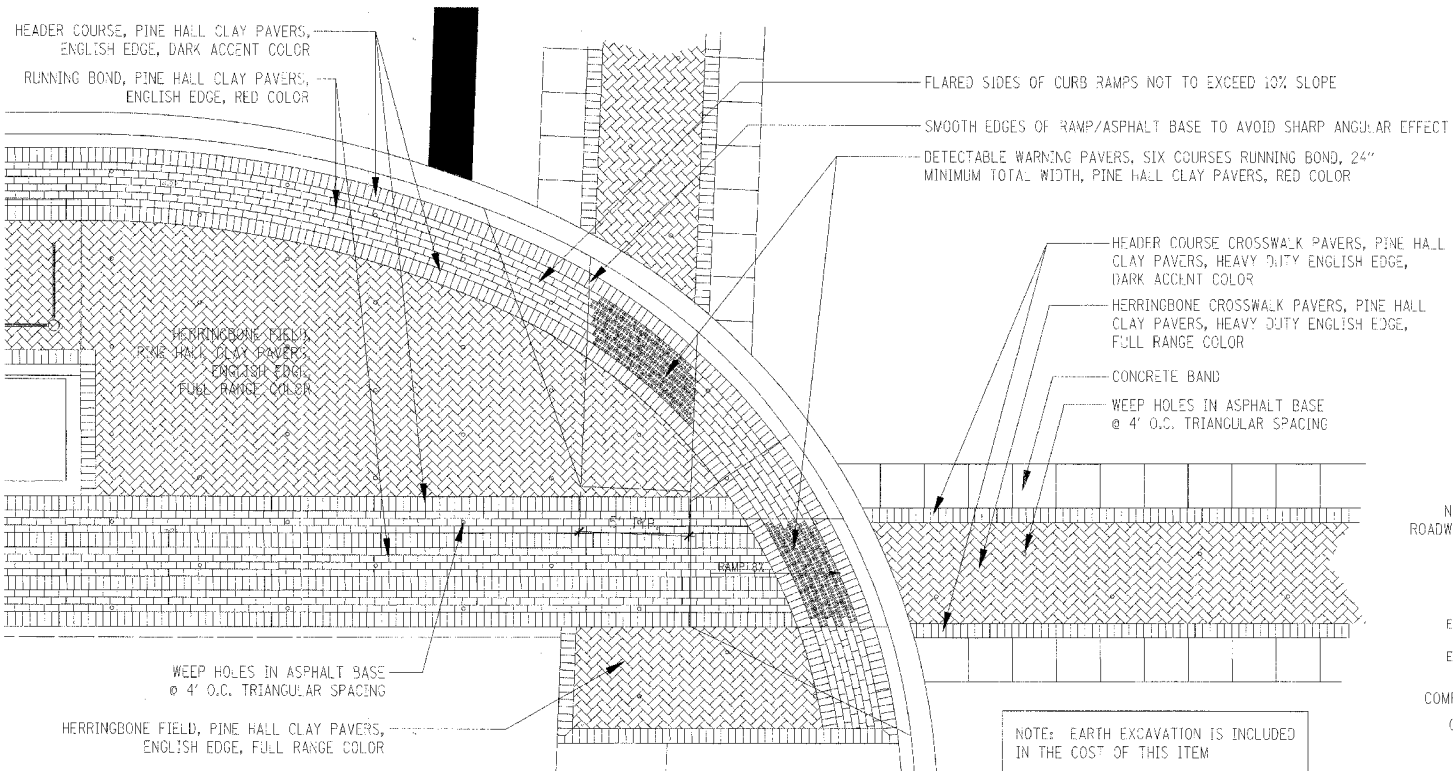


BRICK PAVERS / CURB RAMPS PLAN
 1/4" = 1'-0"

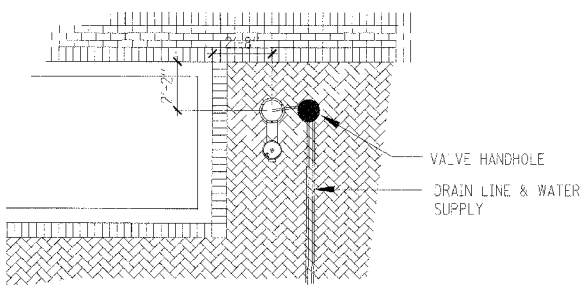


DRINKING FOUNTAIN
 1/4" = 1'-0"
 SURFACE MOUNTED DRINKING FOUNTAIN, MOST DEPENDABLE FOUNTAINS 410 SM, COLOR BLACK, OR APPROVED EQUAL, INSTALL PER MANUFACTURER'S INSTRUCTIONS.
 WATER SUPPLY & SHUT-OFF VALVES IN COVERED HANDHOLE. SEE ENGINEERING DWGS.

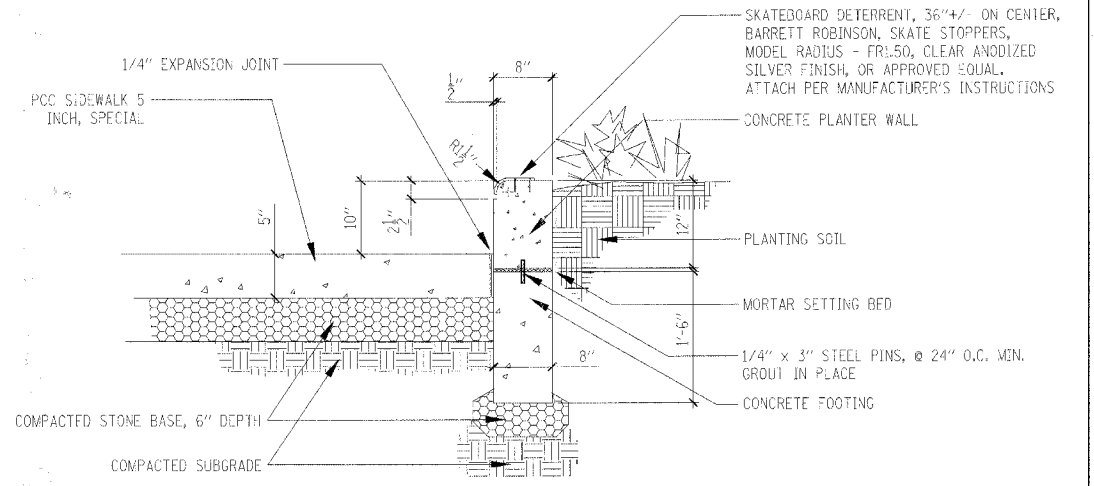

PCC SIDEWALK 5 INCH SPECIAL / CONCRETE PLANTER WALL SECTION
 1" = 1'-0"

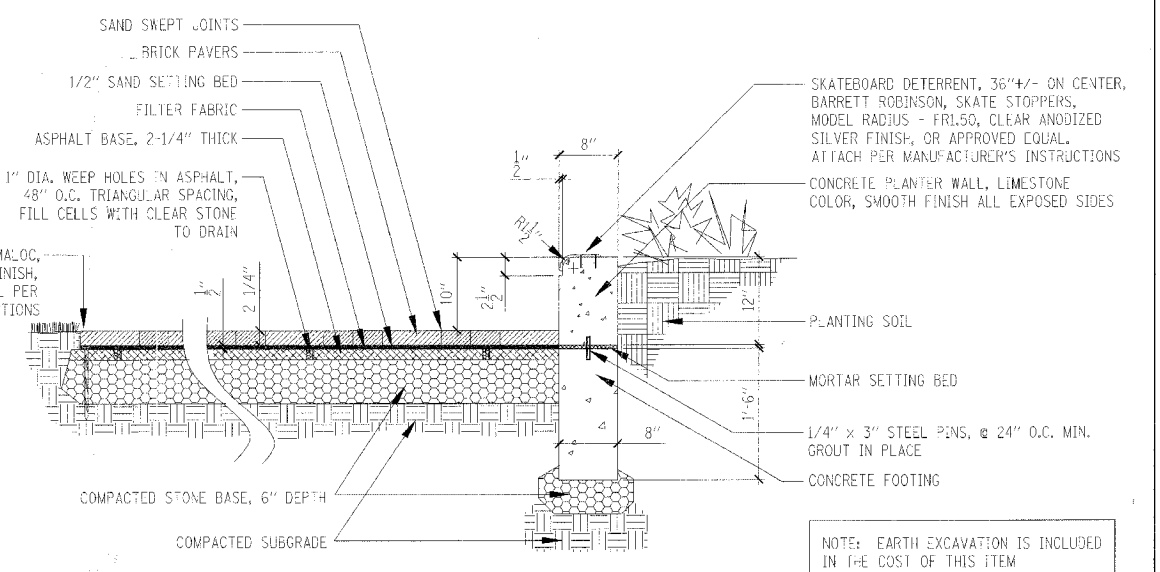

BRICK PAVERS / CONCRETE PLANTER WALL SECTION
 1" = 1'-0"

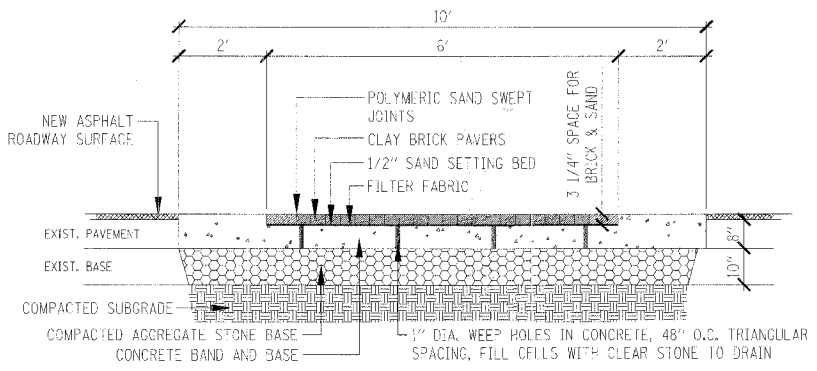

BRICK PAVES CROSSWALK
 1/2" = 1'-0"

REVISIONS	
NAME	DATE

ILLINOIS DEPARTMENT OF TRANSPORTATION
STREETSCAPE DETAILS
 LAWRENCE AVENUE

SCALE: VERT. AS NOTED
 HORIZ. 1/2" = 1'-0"
 DATE 1/08/07
 DRAWN BY JDS
 CHECKED BY JDS

PLOT DATE = 10/29/2007
 FILE NAME = N:\WORK\DDHEIGHTS\08279\CD\1\08279LSP.LSP
 PLOT SCALE = 1"
 USER NAME = PIGNELLI