


F.A.U. RTE.	SECTION	COUNTY	TOTAL SHEETS	SHEET NO.
1338	05-00083-00-FR	COOK	167	111
LIGHTING PLAN - STA. 60+50 TO STA. 65+14				
FED. ROAD DIST. NO. 7 ILLINOIS FED. AID PROJECT M-8003(S)2				

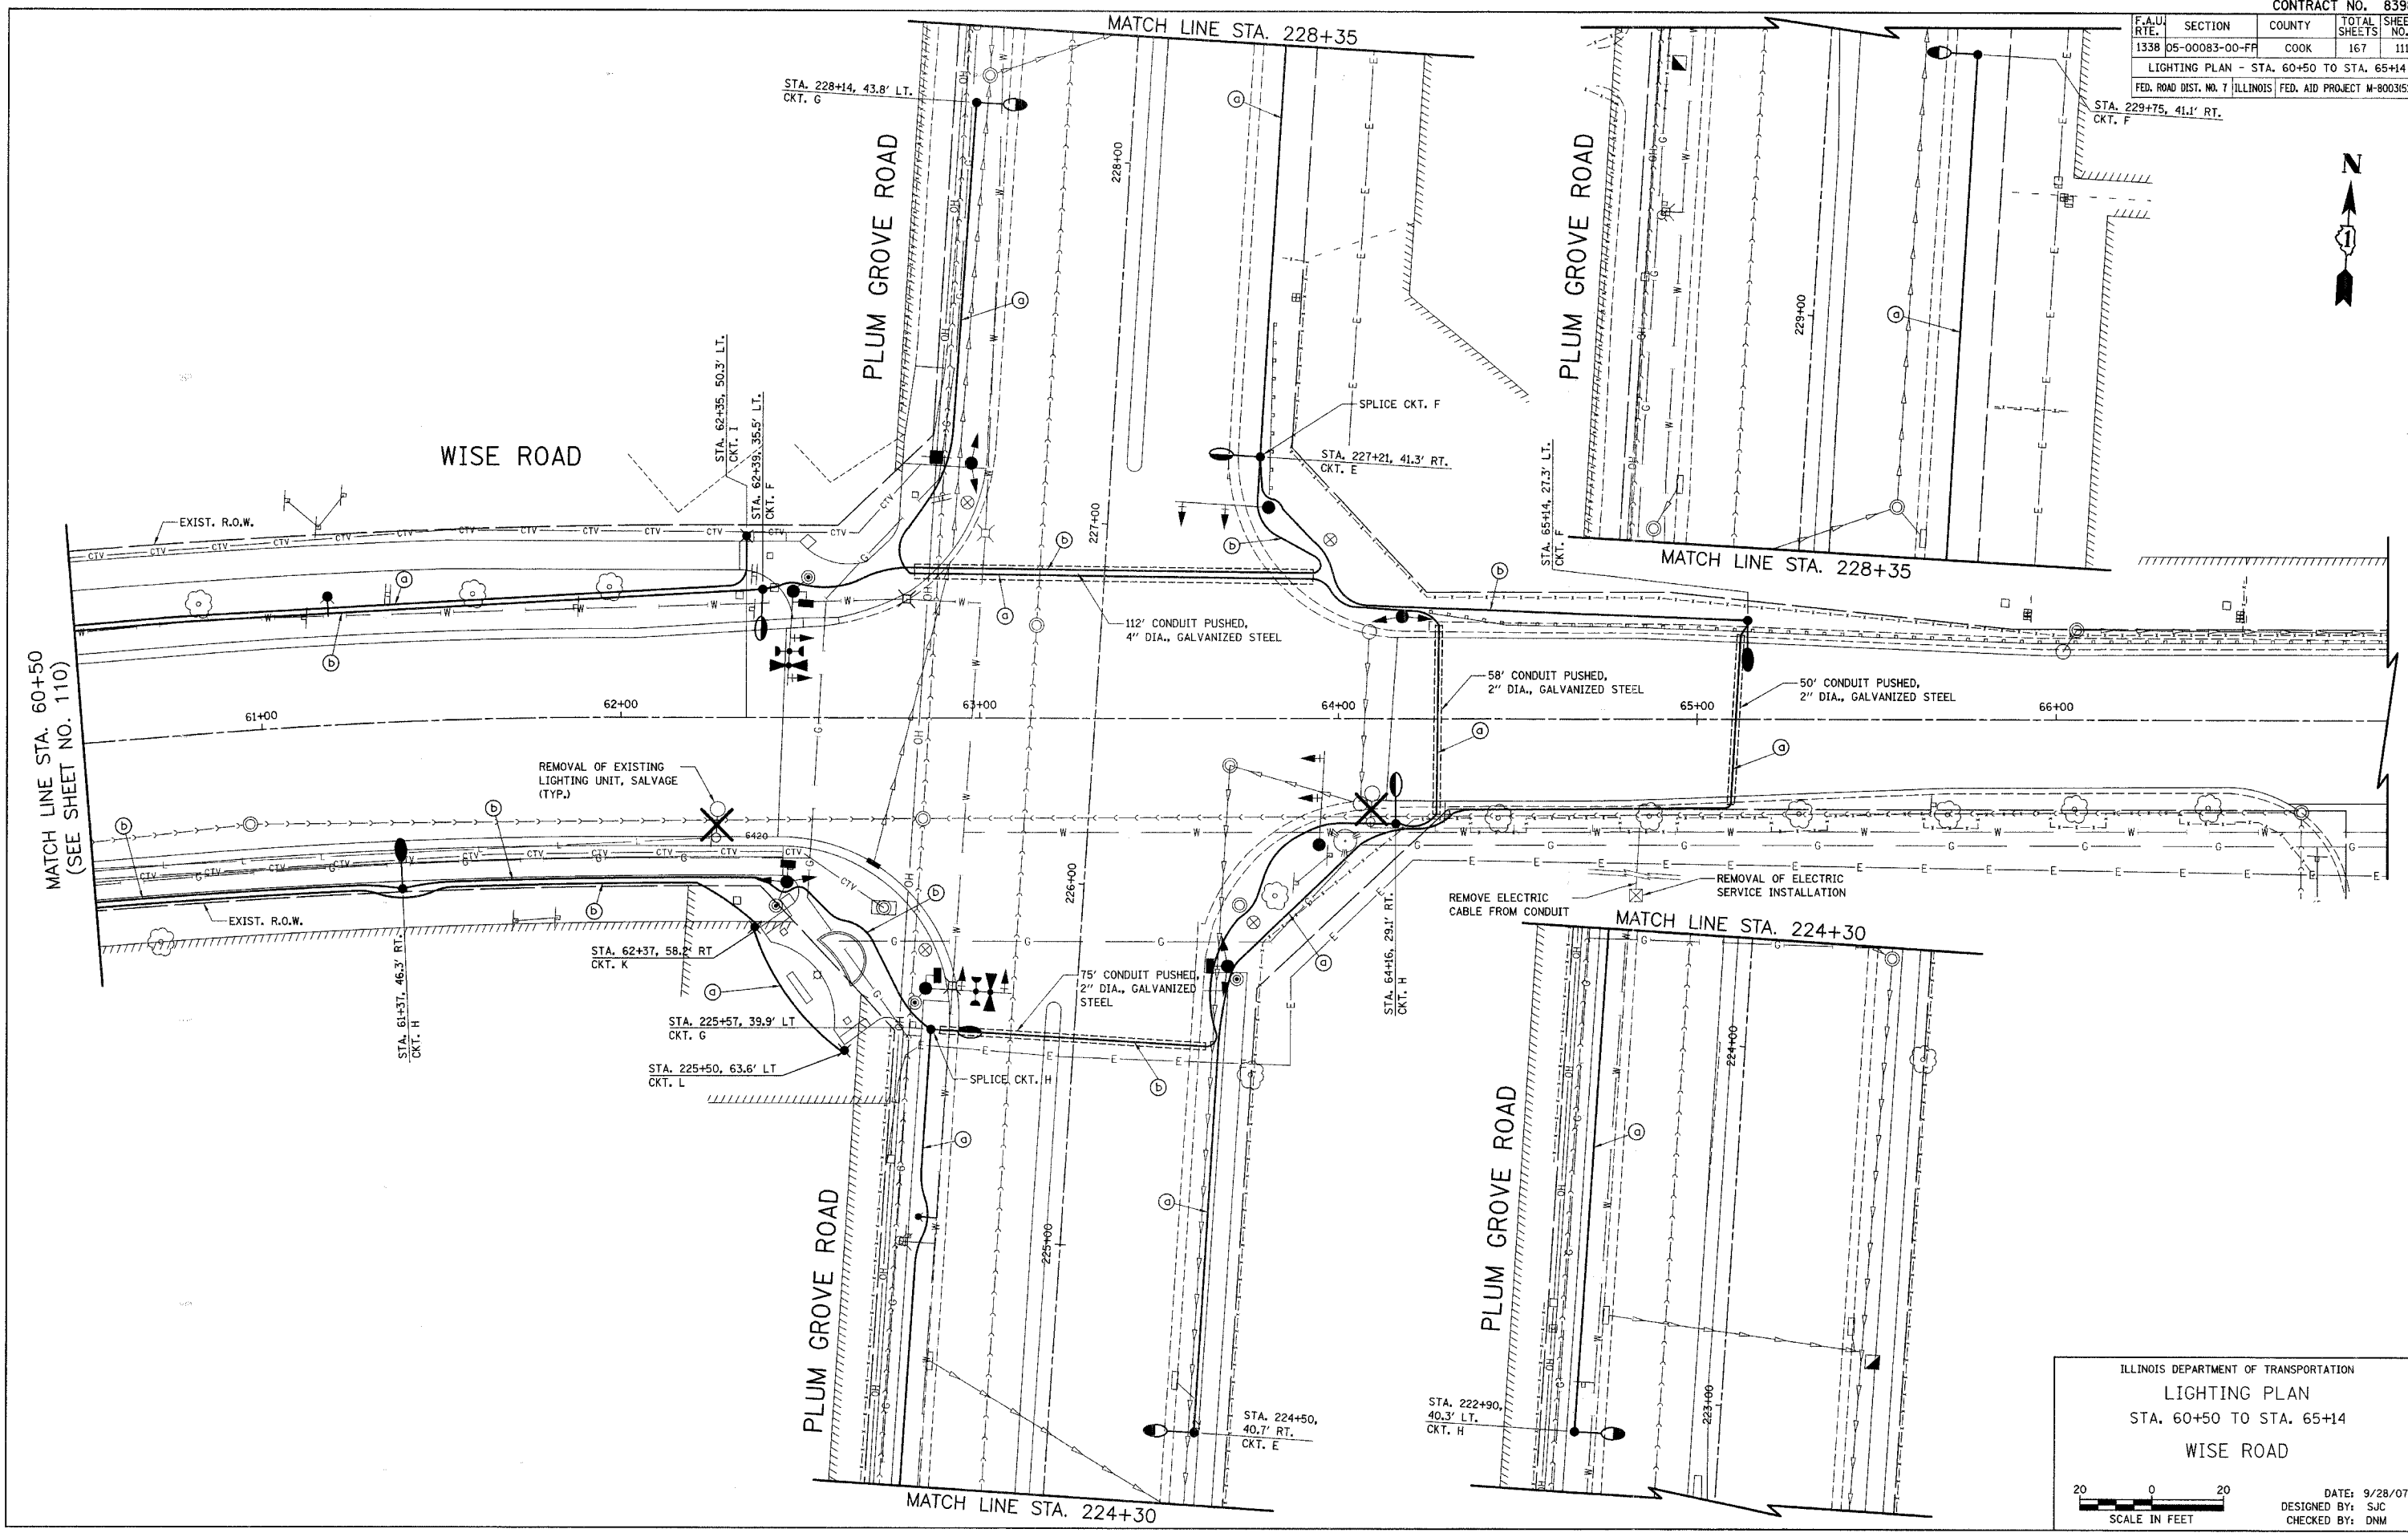

ILLINOIS DEPARTMENT OF TRANSPORTATION
 LIGHTING PLAN
 STA. 60+50 TO STA. 65+14
 WISEL ROAD

DATE: 9/28/07
 DESIGNED BY: SJC
 CHECKED BY: DNM

SCALE IN FEET