
 
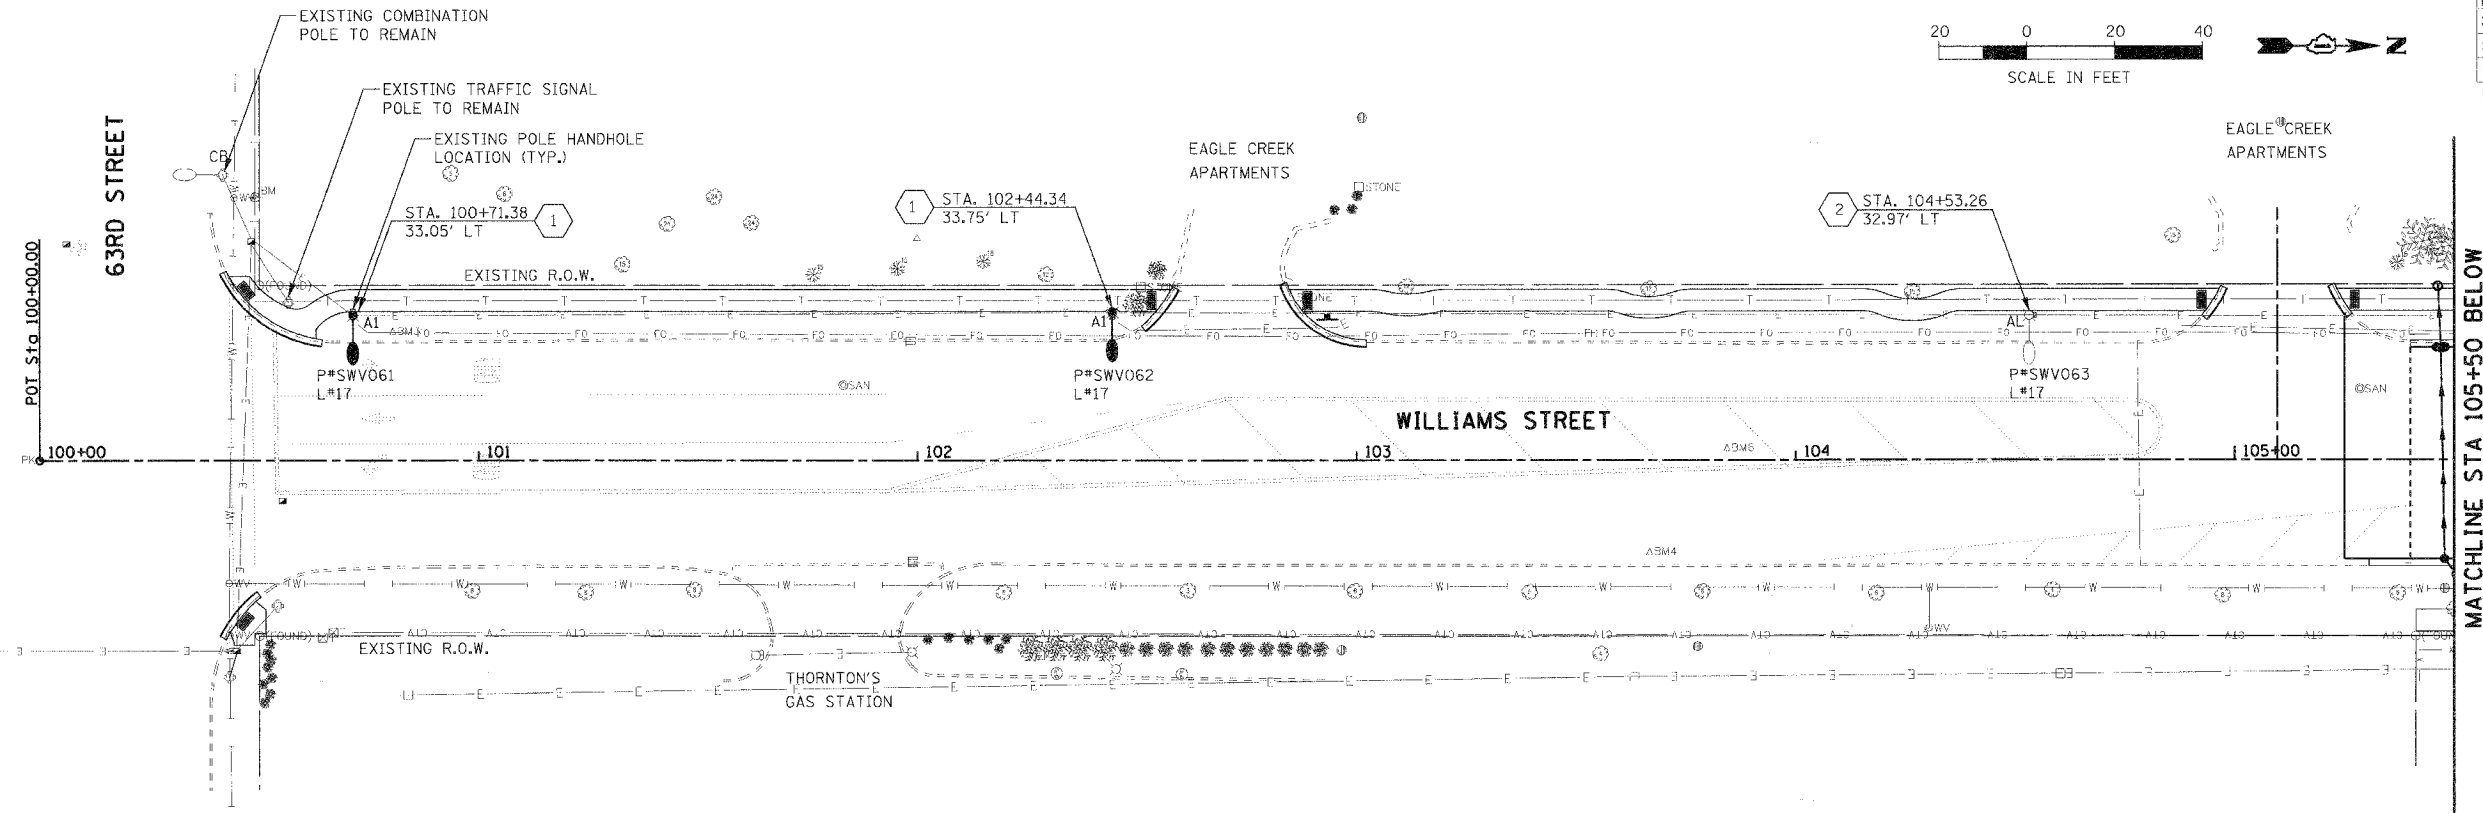


F.A.U. R.T.E.	SECTION	COUNTY	TOTAL SHEETS	SHEET NO.
2993	05-00094-00-WR	DUPAGE	67	45
STA. 100+00		TO STA. 111+00		
FED. ROAD DIST. NO. 1 ILLINOIS FED. AID PROJECT				
PROJECT NO.: M-8003 (707)				



PLAN	SURVEYED	DATE
NOTE BOOK NO.	BY	
	DATE	

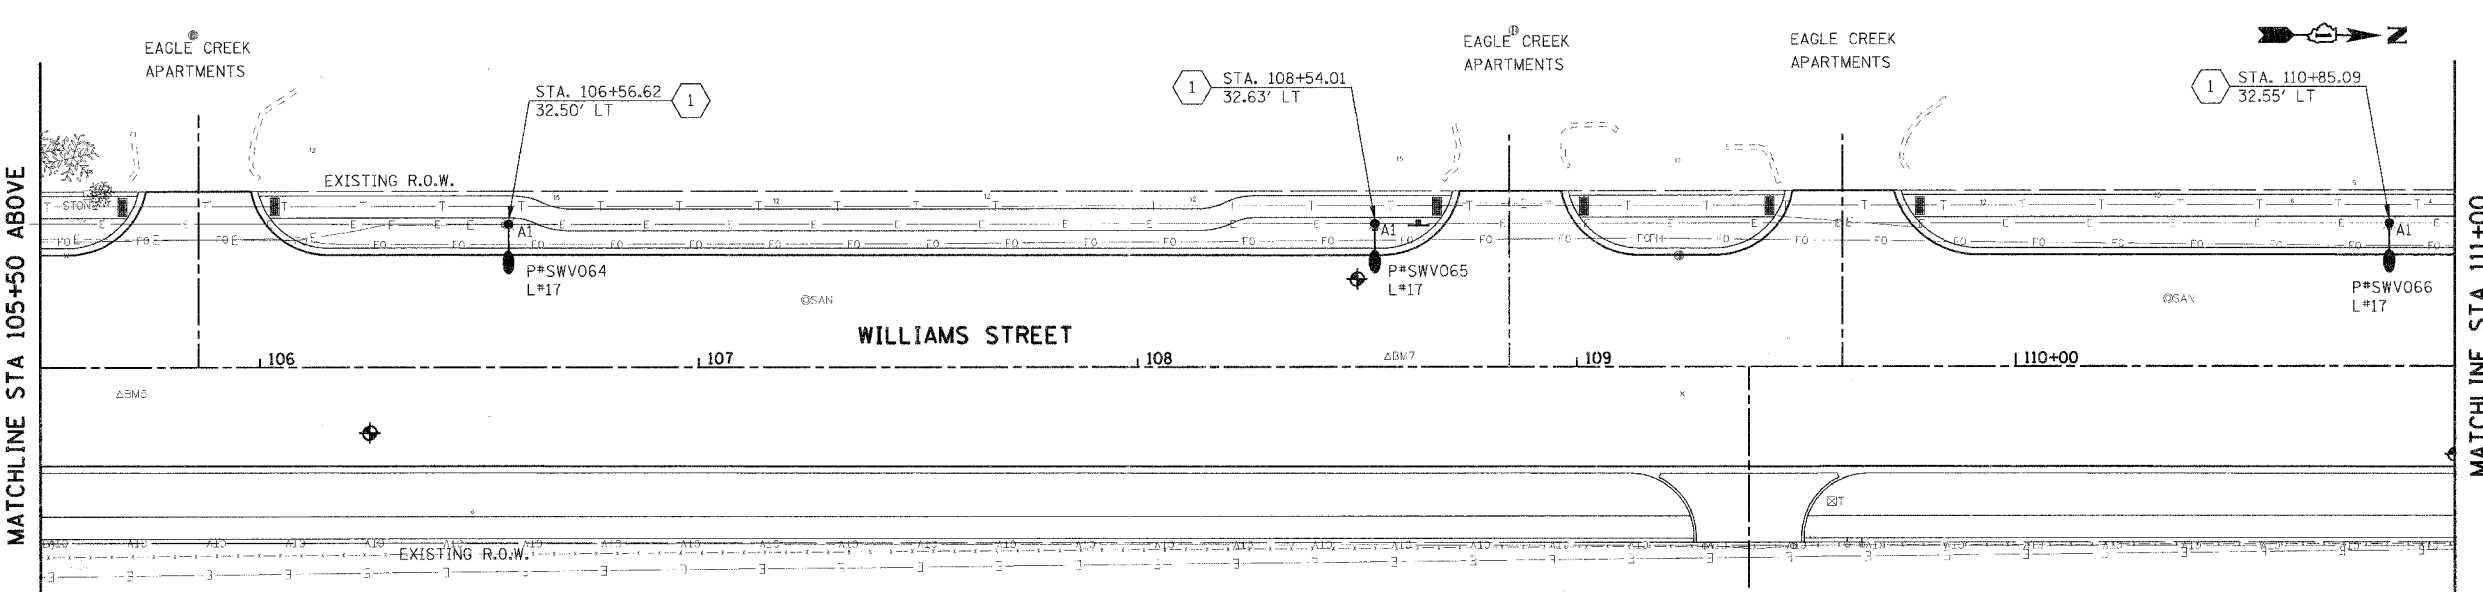

PROFILE	SURVEYED	DATE
NOTE BOOK NO.	BY	
	DATE	

**GENERAL NOTES**

- REFER TO DRAWING E-01 FOR GENERAL NOTES, LEGEND AND ABBREVIATIONS.
- EXISTING LIGHT POLE AND ASSOCIATED CIRCUIT, CABLE, FOUNDATION, FIXTURE, ETC. TO REMAIN.
- LOCATION OF EXISTING LIGHT POLES ARE APPROXIMATE. FIELD VERIFY EXACT LOCATION.

**KEY NOTES**

- PROVIDE NEW LIGHT POLE AND LIGHT FIXTURE IN ACCORDANCE WITH DETAILS ON SHEET E-08.
- EXISTING ALUMINUM LIGHT POLE TO REMAIN. CLEAN AND RELAMP EXISTING LUMINAIRE.

PLOT DATE = #DATE#  
 FILE NAME = #FILE#  
 PLOT SCALE = #SCALE#  
 USER NAME = #USER#

E-05 5 OF 12

REVISIONS		ILLINOIS DEPARTMENT OF TRANSPORTATION
NAME	DATE	
		VILLAGE OF WESTMONT WILLIAMS STREET RECONSTRUCTION PROPOSED LIGHTING PLAN SHEET 1 OF 3 SCALE: 1:20 DATE: 09/21/07 DRAWN BY: FO CHECKED BY: DEM