
 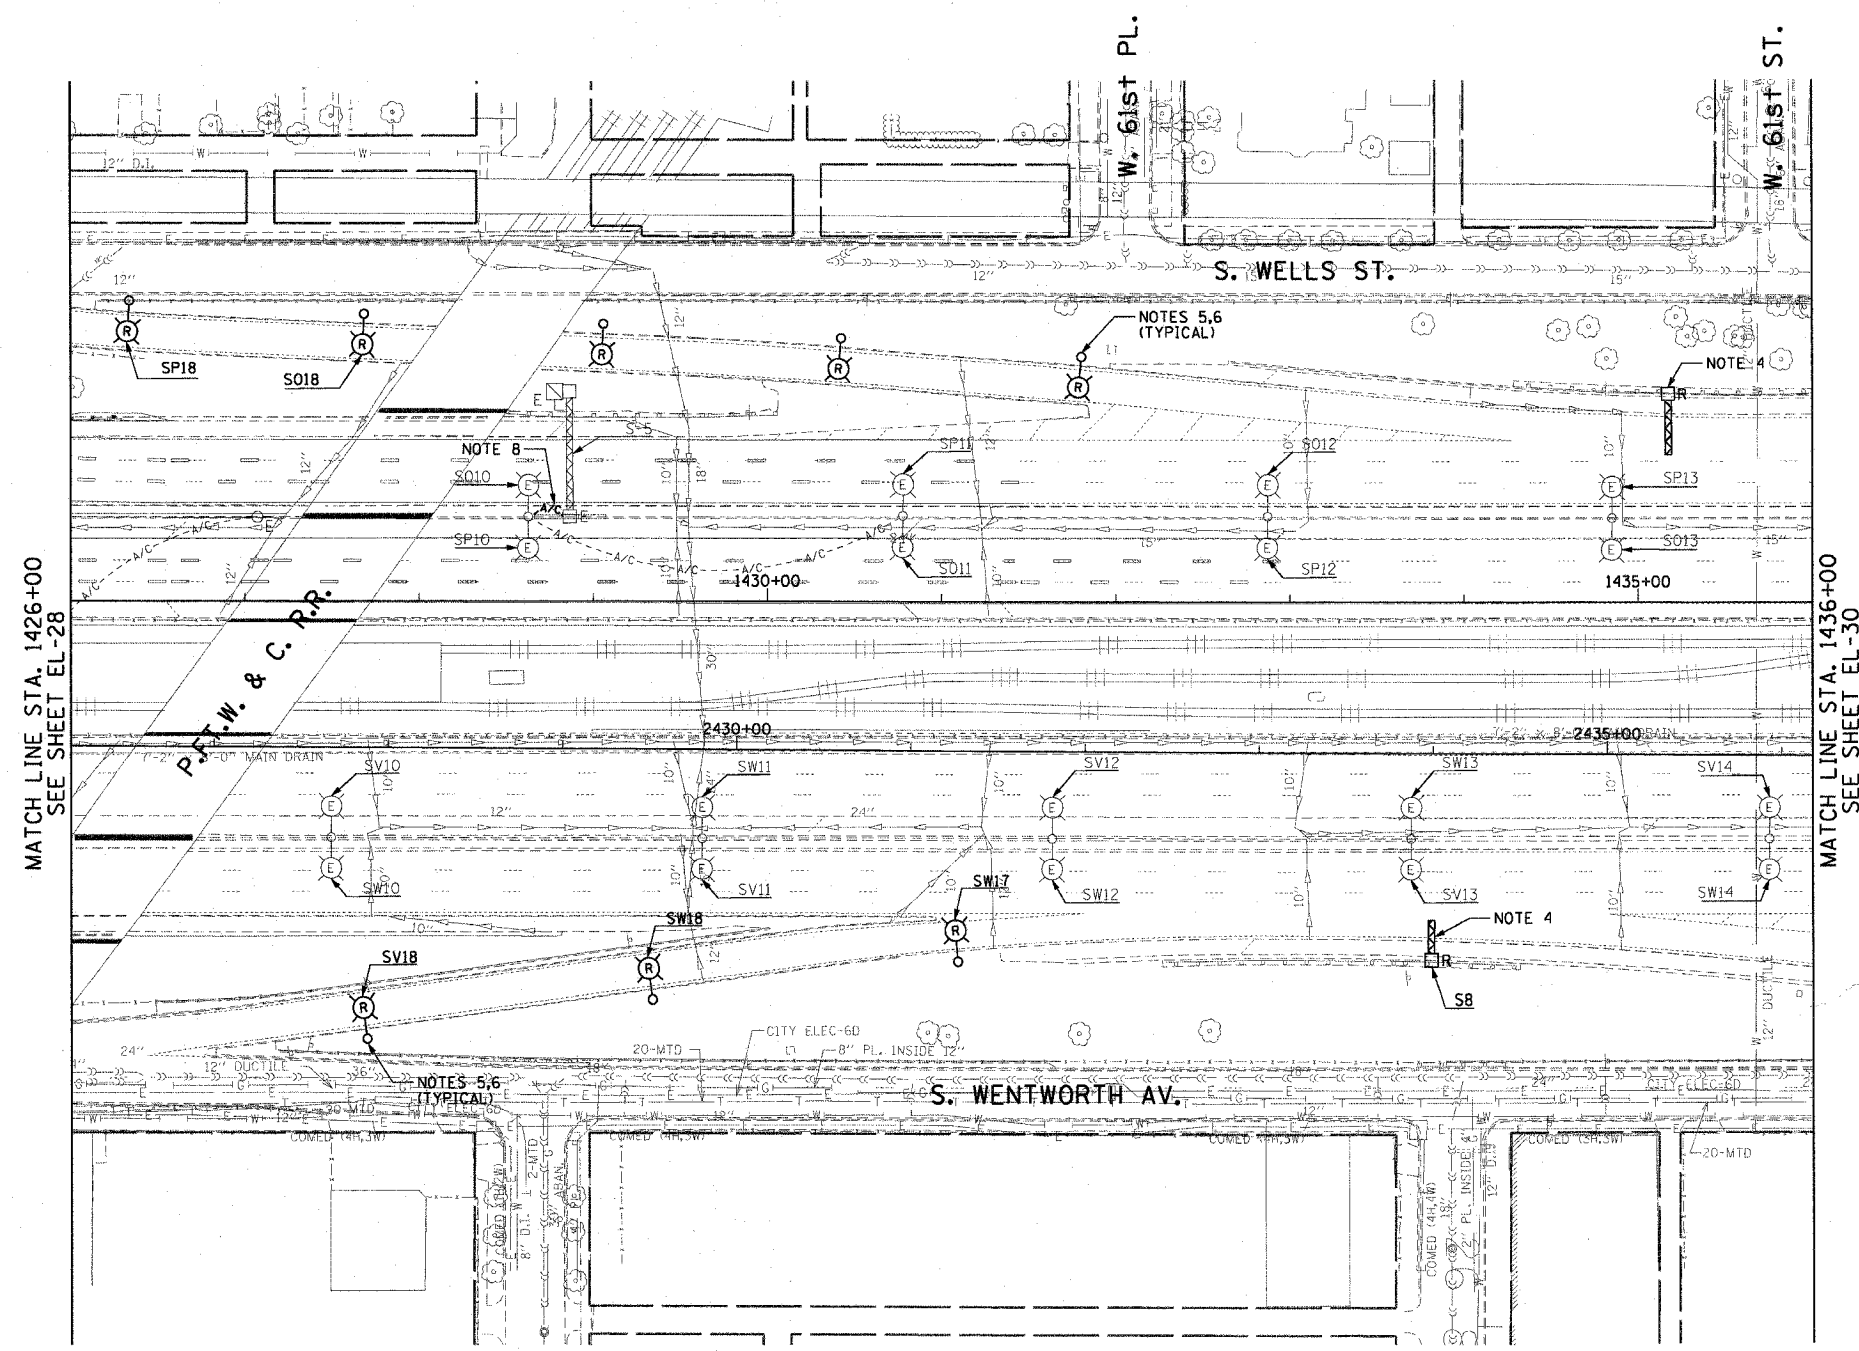


F.A.I. RTE.	SECTION	COUNTY	TOTAL SHEETS	SHEET NO.
90/94	2003-0311	COOK	976	101
STA. 1426+00.00		TO STA. 1436+00.00		
FED. ROAD DIST. NO. 1 ILLINOIS FED. AID PROJECT				

62583

NOTES:

 
- SEE DRAWINGS ME-01 AND ME-02 FOR ELECTRICAL SYMBOLS AND ABBREVIATIONS.
- COORDINATE ALL WORK WITH IDOT CONTRACT NO. 62693.
- UNLESS NOTED OTHERWISE, ALL ITEMS AND WORK SHOWN IN HEAVY LINE WEIGHT ON THIS DRAWING ARE PROPOSED ITEMS AND WORK.
- REMOVE EXISTING SIGN LUMINAIRES, DISCONNECT THE EXISTING SIGN LIGHTING ELECTRIC SERVICE, AND REMOVE CABLES TO NEAREST SPLICE, STRUCTURE AND FOUNDATIONS WILL BE REMOVED BY OTHERS.
- THE EXISTING IDOT RAMP LIGHTING MUST REMAIN IN OPERATION UNTIL THE RAMPS ARE CLOSED FOR CONSTRUCTION UNDER IDOT CONTRACT NO. 62693. NO LIGHTING UNITS SHALL BE REMOVED WITHOUT APPROVAL FROM THE ENGINEER.
- LIGHTING UNIT CONCRETE FOUNDATION WILL BE REMOVED IN IDOT CONTRACT NO. 62693.
- THE EXISTING ROADWAY LIGHTING MOUNTED ON THE MEDIAN BARRIER WALL NORTH OF 63rd ST. TO 59th ST. MUST REMAIN IN OPERATION UNTIL THE PROPOSED ROADWAY LIGHTING SYSTEM HAS BEEN INSTALLED, ENERGIZED, TESTED, AND ACCEPTED BY THE ENGINEER, UNLESS OTHERWISE DIRECTED.
- DISCONNECT THE EXISTING TEMPORARY AERIAL CABLE FROM SIGN STRUCTURE "S-5" AND COIL AT THE NEAREST LIGHTING UNIT TO REMAIN. THE TEMPORARY AERIAL CABLE SHALL NOT BE DISCONNECTED UNTIL THE PERMANENT FEED TO THE SIGN STRUCTURE HAS BEEN INSTALLED, TESTED, AND ACCEPTED BY THE ENGINEER.



MATCH LINE STA. 1426+00
SEE SHEET EL-28

MATCH LINE STA. 1436+00
SEE SHEET EL-30

HIGH MAST LIGHT TOWERS, CONTROLLERS, AND WIRING ARE INSTALLED IN IDOT CONTRACT NO. 62733.



EL-29

REVISIONS	
NAME	DATE

ILLINOIS DEPARTMENT OF TRANSPORTATION
F.A.I. 90/94 (DAN RYAN EXPRESSWAY)
31st STREET TO I-57

**ROADWAY LIGHTING PLANS
EXISTING CONDITIONS AND DEMOLITION**

SCALE: 1"=50'
DATE: October 29, 2004

DRAWN BY: CJM
CHECKED BY: WDS

CTE ENGINEERS
CONSER TOWNSEND ENVIRO/DINE ENGINEERS, INC.
303 EAST WACKER DRIVE, SUITE 600
CHICAGO, ILLINOIS 60601-5202, PHONE: (312) 938-0300

10/15/2004 02:34:21 PM