


| F.A.I. RTE.           | SECTION   | COUNTY                    | TOTAL SHEETS | SHEET NO. |
|-----------------------|-----------|---------------------------|--------------|-----------|
| 90/94                 | 2003-0311 | COOK                      | 976          | 104       |
| STA. 1458+50.00       |           | TO STA. 1471+00.00        |              |           |
| FED. ROAD DIST. NO. 1 |           | ILLINOIS FED. AID PROJECT |              |           |

62583

 
NOTES:  
 1. SEE DRAWINGS ME-01 AND ME-02 FOR ELECTRICAL SYMBOLS AND ABBREVIATIONS.

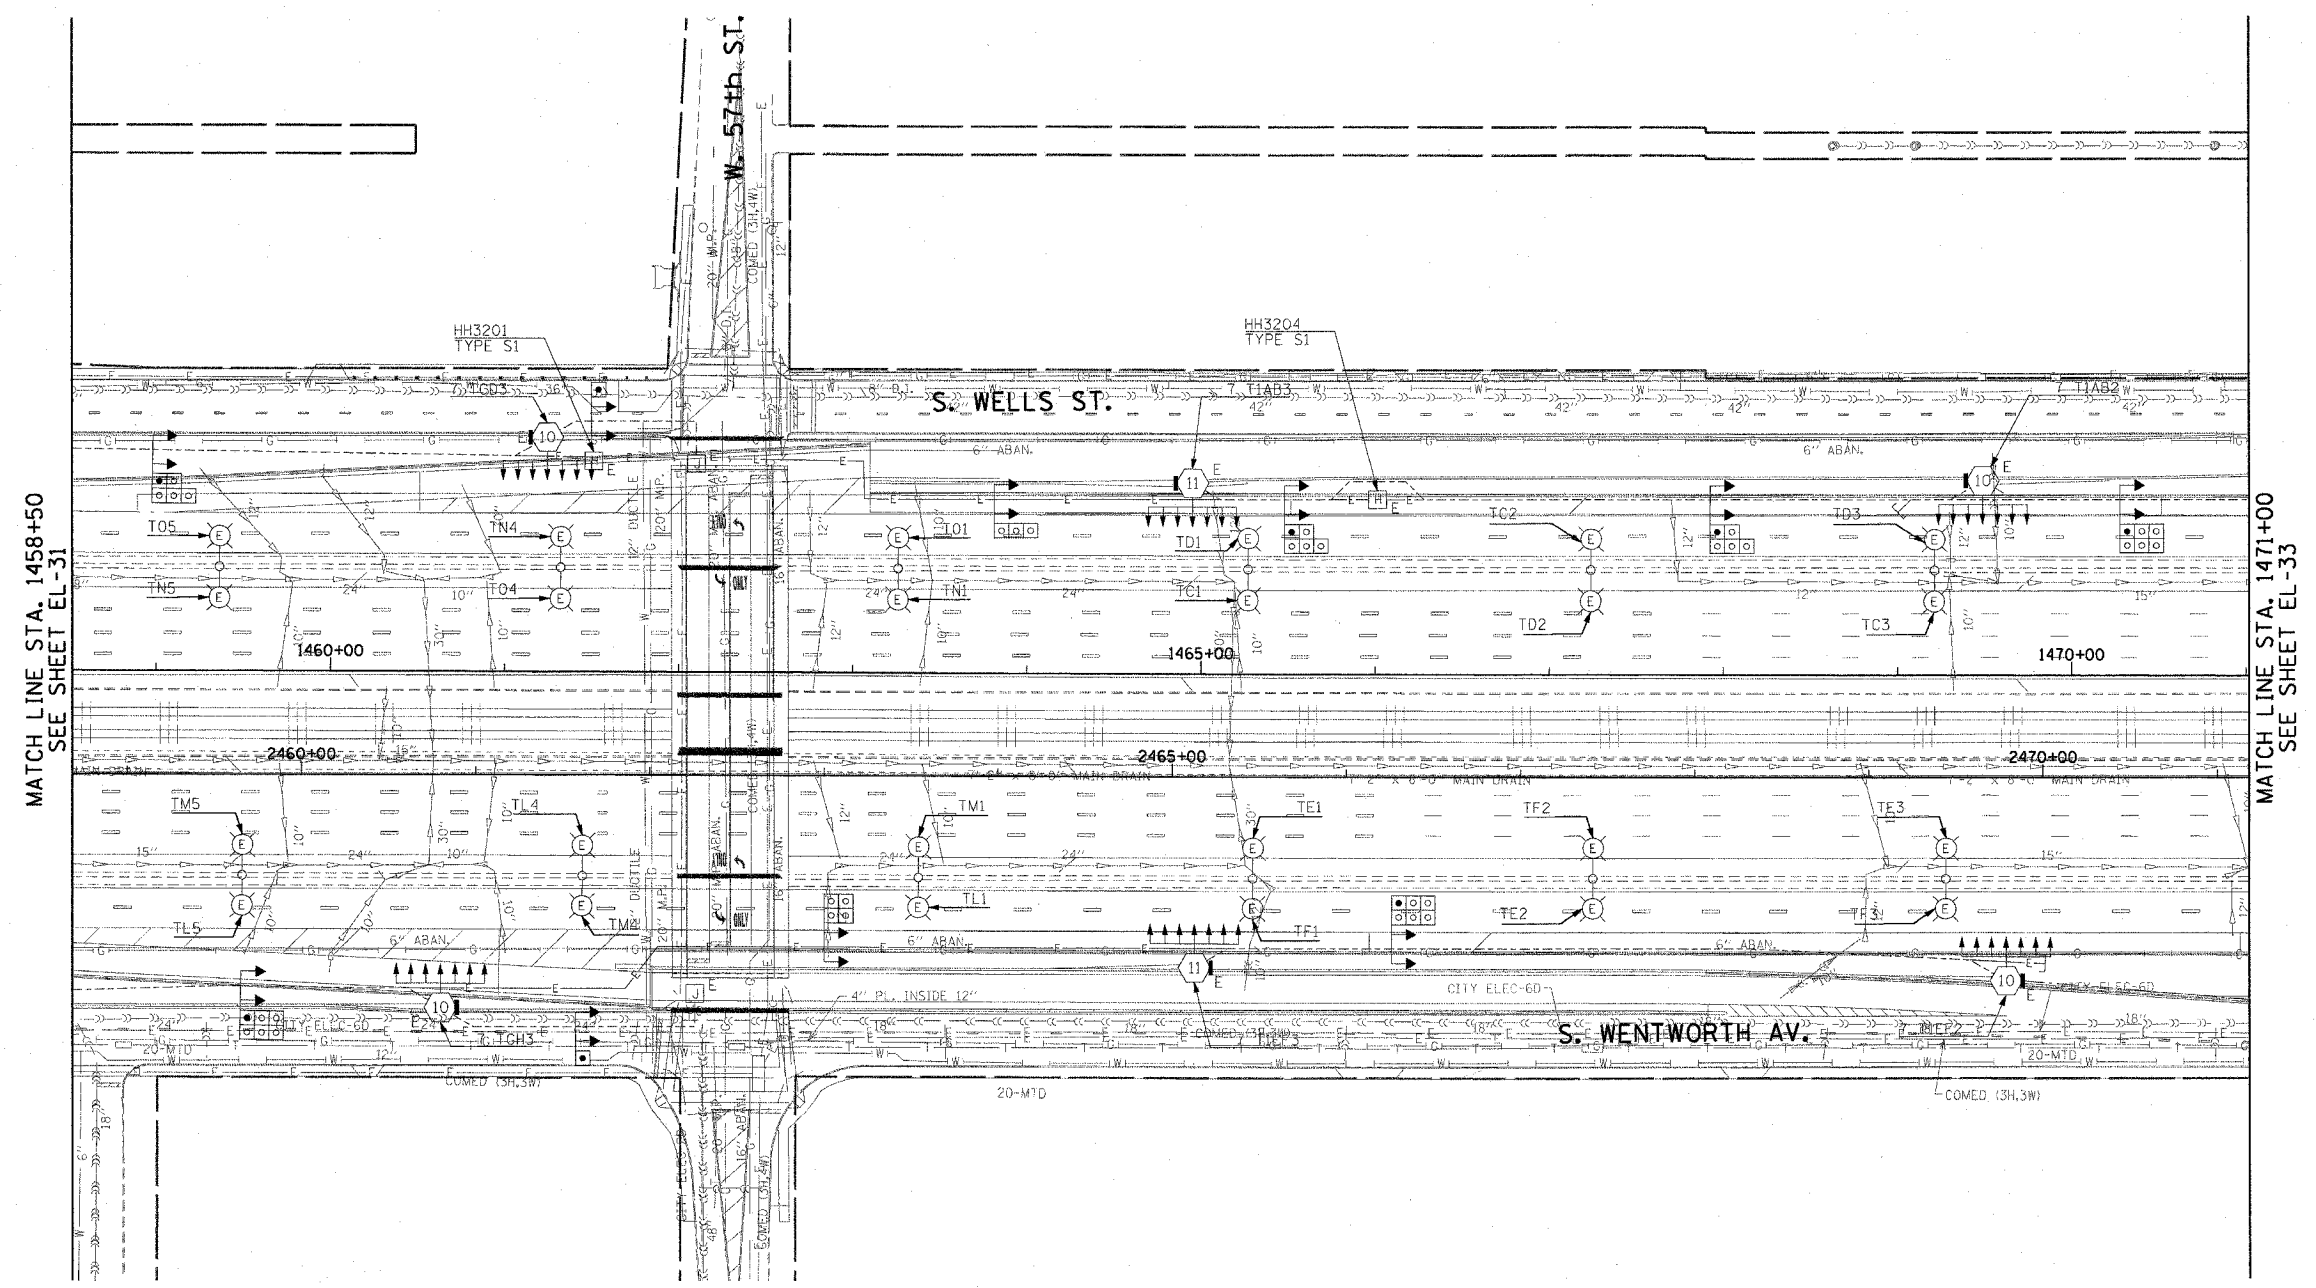

MATCH LINE STA. 1458+50  
SEE SHEET EL-31

MATCH LINE STA. 1471+00  
SEE SHEET EL-33

THIS SHEET IS FOR INFORMATIONAL PURPOSES ONLY. HIGH MAST LIGHT TOWERS, CONTROLLERS, AND WIRING ARE INSTALLED IN IDOT CONTRACT NO. 62733.



EL-32

| REVISIONS |      |
|-----------|------|
| NAME      | DATE |
|           |      |
|           |      |
ILLINOIS DEPARTMENT OF TRANSPORTATION  
 F.A.I. 90/94 (DAN RYAN EXPRESSWAY)  
 31st STREET TO I-57  
 ROADWAY LIGHTING PLANS  
 EXISTING CONDITIONS AND DEMOLITION  
 SCALE: 1"=50'  
 DATE: October 29, 2004  
 DRAWN BY: CJM  
 CHECKED BY: WDS

**CTE ENGINEERS**  
 CONSER TOWNSEND ENVIRONMENTAL ENGINEERS, INC.  
 303 EAST WACKER DRIVE, SUITE 600  
 CHICAGO ILLINOIS 60601-5212, PHONE: (312) 938-0300

10/15/2004 02:54:29 PM